



AGENDA
CITY OF GLENWOOD SPRINGS
SPECIAL CITY COUNCIL MEETING
NOVEMBER 10, 2020
101 W. 8TH STREET
6:00 PM

The agenda is subject to *change, including the addition of items 24 hours in advance or the deletion of items at any time.*
The order and times of agenda items listed are approximate and intended as a guideline for the City Council.

TIME	ITEM	ZOOM INSTRUCTIONS	ACTION
	1.	You are invited to a Zoom webinar. When: Nov 10, 2020 06:00 PM Mountain Time (US and Canada) Topic: 2020/11/10 Special Council Meeting Please click the link below to join the webinar: https://us02web.zoom.us/j/89095314772 Or iPhone one-tap : US: +16699006833,,89095314772# or +12532158782,,89095314772# Or Telephone: Dial(for higher quality, dial a number based on your current location): US: +1 669 900 6833 or +1 253 215 8782 or +1 346 248 7799 or +1 929 205 6099 or +1 301 715 8592 or +1 312 626 6799 Webinar ID: 890 9531 4772 International numbers available: https://us02web.zoom.us/j/kcFRP1CGuZ	Information
TIME	ITEM	SPECIAL CITY COUNCIL MEETING	ACTION
6:00pm	2.	Roll Call	
	3.	Pledge of Allegiance	Quorum
		ACTIONS AND/OR PRESENTATIONS	
	4.	Award South Midland Construction Contract	Discussion and/or Action
	5.	Adjournment	



City Council
STAFF REPORT
City of Glenwood Springs
November 10, 2020

Agenda Item: Award South Midland Construction Contract

Action Requested: Award South Midland Construction Contract.

The lowest responsible bidder was determined to be Gould Construction Inc. for a contract price of \$13,168,962.65.

Department: Engineering

Presented By: Terri Partch, City Engineer

Background Info: The South Midland Project bid was first advertised on October 30th, 2020. A mandatory pre-bid meeting was held on October 13th, 2020. The bids were opened on November 3rd, 2020. Five bids were received and reviewed for completeness and compliance with the bid documents. No major irregularities were noted in the review of documents. The bid results are listed below:

1. **Gould Construction - \$13,168,962.65**
2. Johnson Construction - \$13,749,263.10
3. Scott Contracting - \$14,044,169.65
4. United Companies - \$14,928,035.60
5. American Civil Constructors - \$15,745,076.0

The engineers estimate of probable cost was \$13,796,217.50

The funds allocated for this project are summarized below.



1. DOLA Grant - \$151,750.00
2. Garfield County Funds - \$850,000.00
3. BUILD Grant (US DOT) - \$7,007,562.00
4. City A/I funds - \$5,159,650.65

The City is responsible for all additional funding beyond the grant amounts, and for any cost overruns that may occur.

Issues: None at this time.

Staff Recommendation: Award the South Midland Construction to Gould Construction, Inc. in the amount of \$13,168,962.65.




I:\2017\2017-211-GWSSOMIDLAND\001-MIDLAND4MILERO27THST\H-DWGS\CIVIL\PS-SHEETSET\SMIDLAND-GEOMETRYPLAN.DWG Plotted: 7/14/2020 3:14 PM By: Ashley Cline

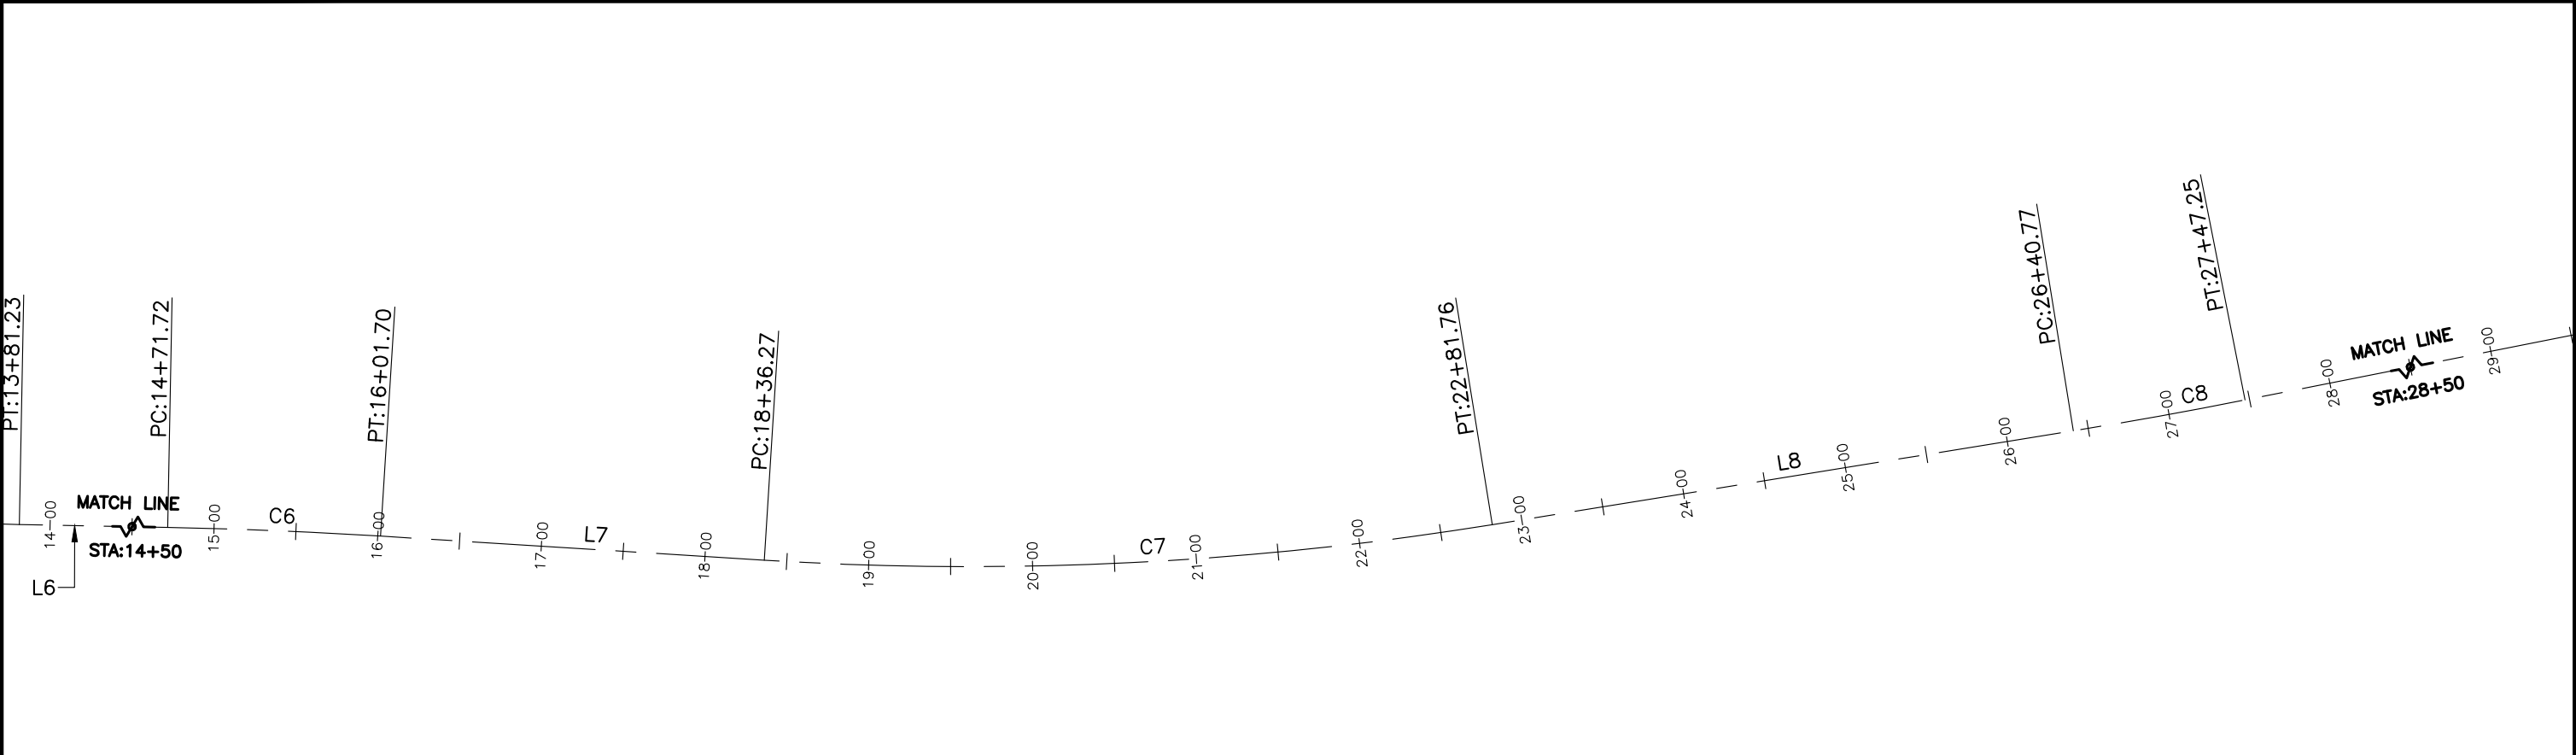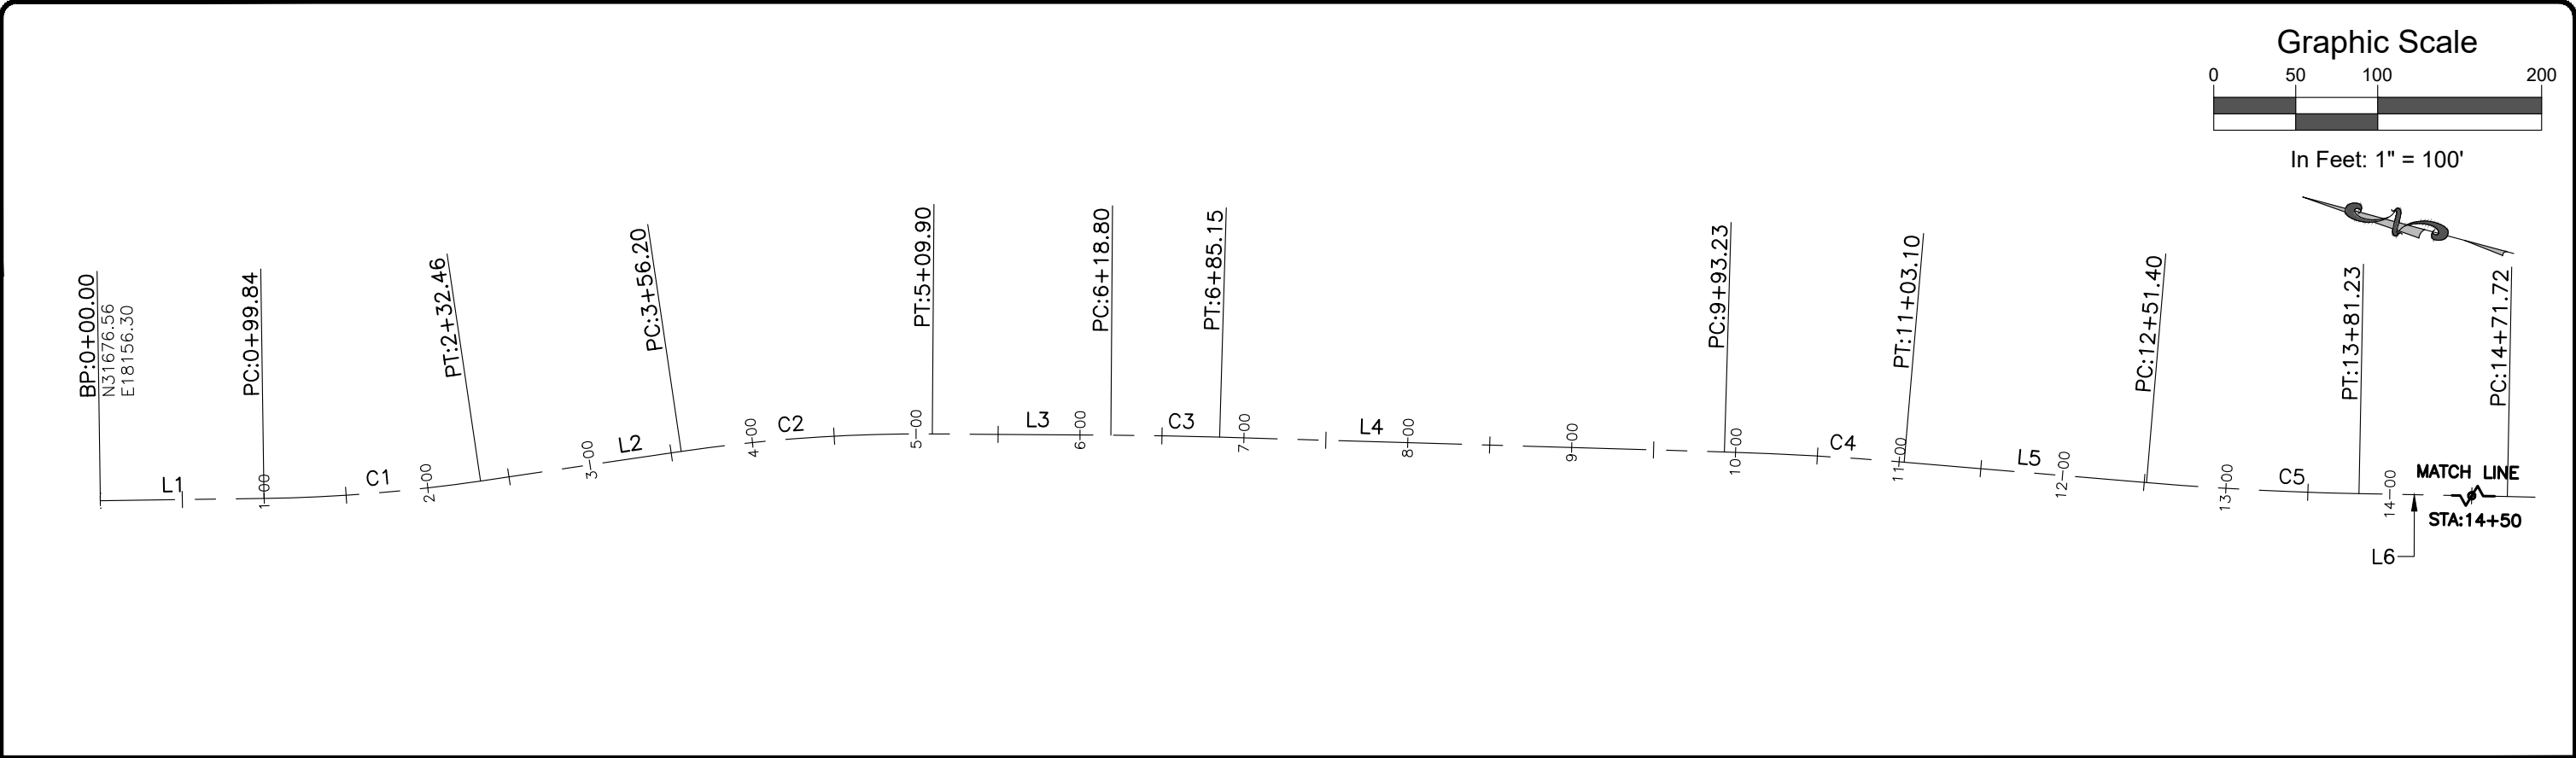

Computer File Information		Sheet Revisions					 118 West Sixth Street, Suite 200 Glenwood Springs, CO 81601 970.945.1004 www.sgm-inc.com	As Constructed		South Midland Ave. Improvements Geometry Plan (1)				Project No./Code	
Print Date: 7/14/20		Rev.	Date	Comments	Init.			No Revisions: -		Engineer: MDF Structure --- Drawn By: AMC Numbers --- Sheet Subset: GEOM Subset Sheets: 1 of 5				No.: BUILD M535-006	
Last Modification Date: 4/23/2019		1						Revised: -						Code: 22933	
Drawing File Name: SMidland-GeometryPlan								Void: -		Sheet Number: 40					
Autocad Ver. 2018 Scale: As Shown Units: English															
SGM Project No.: 2017-211.001 Quality Control: RGN															



I:\2017\2017-211-GWSSOMIDLAND\001-MIDLAND4MILERO27THST\H-DWGS\CIVIL\PS-SHEETSET\SMIDLAND-GEOMETRYPLAN.DWG Plotted: 7/14/2020 3:14 PM By: Ashley Cline

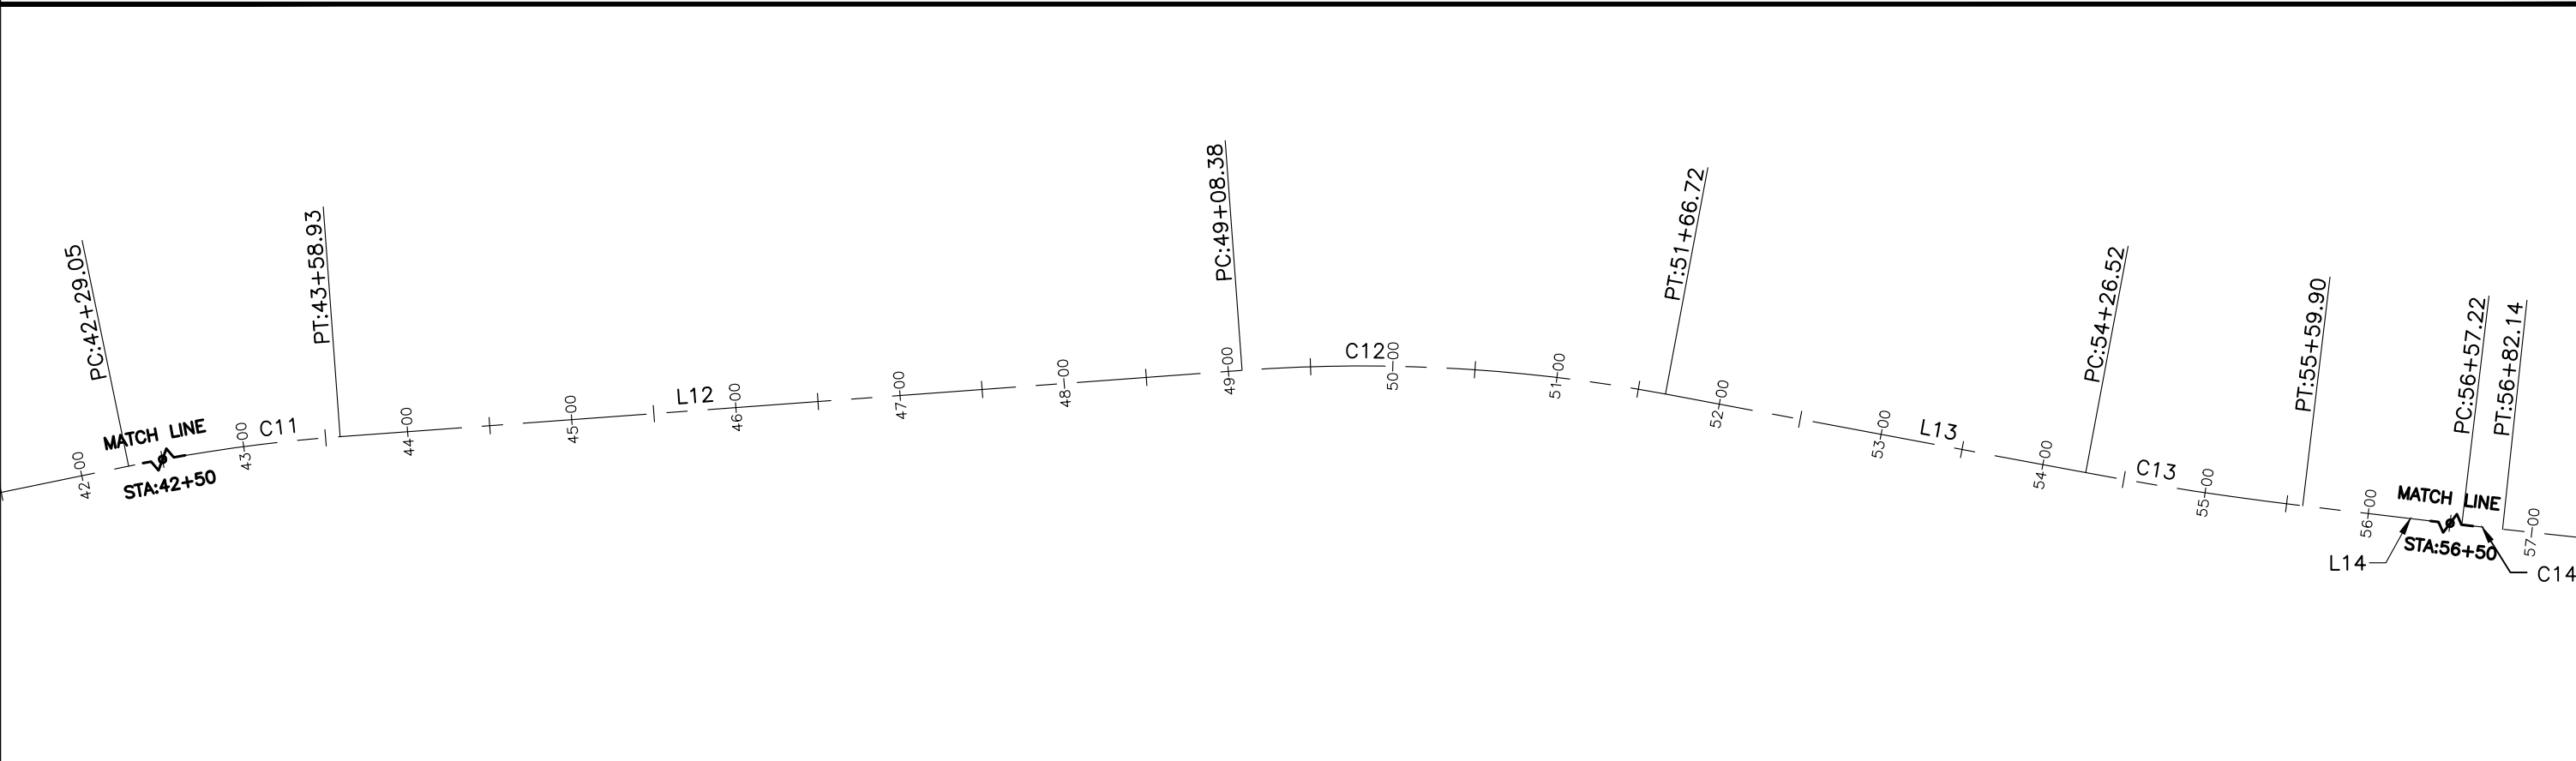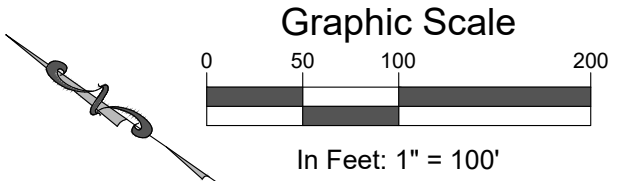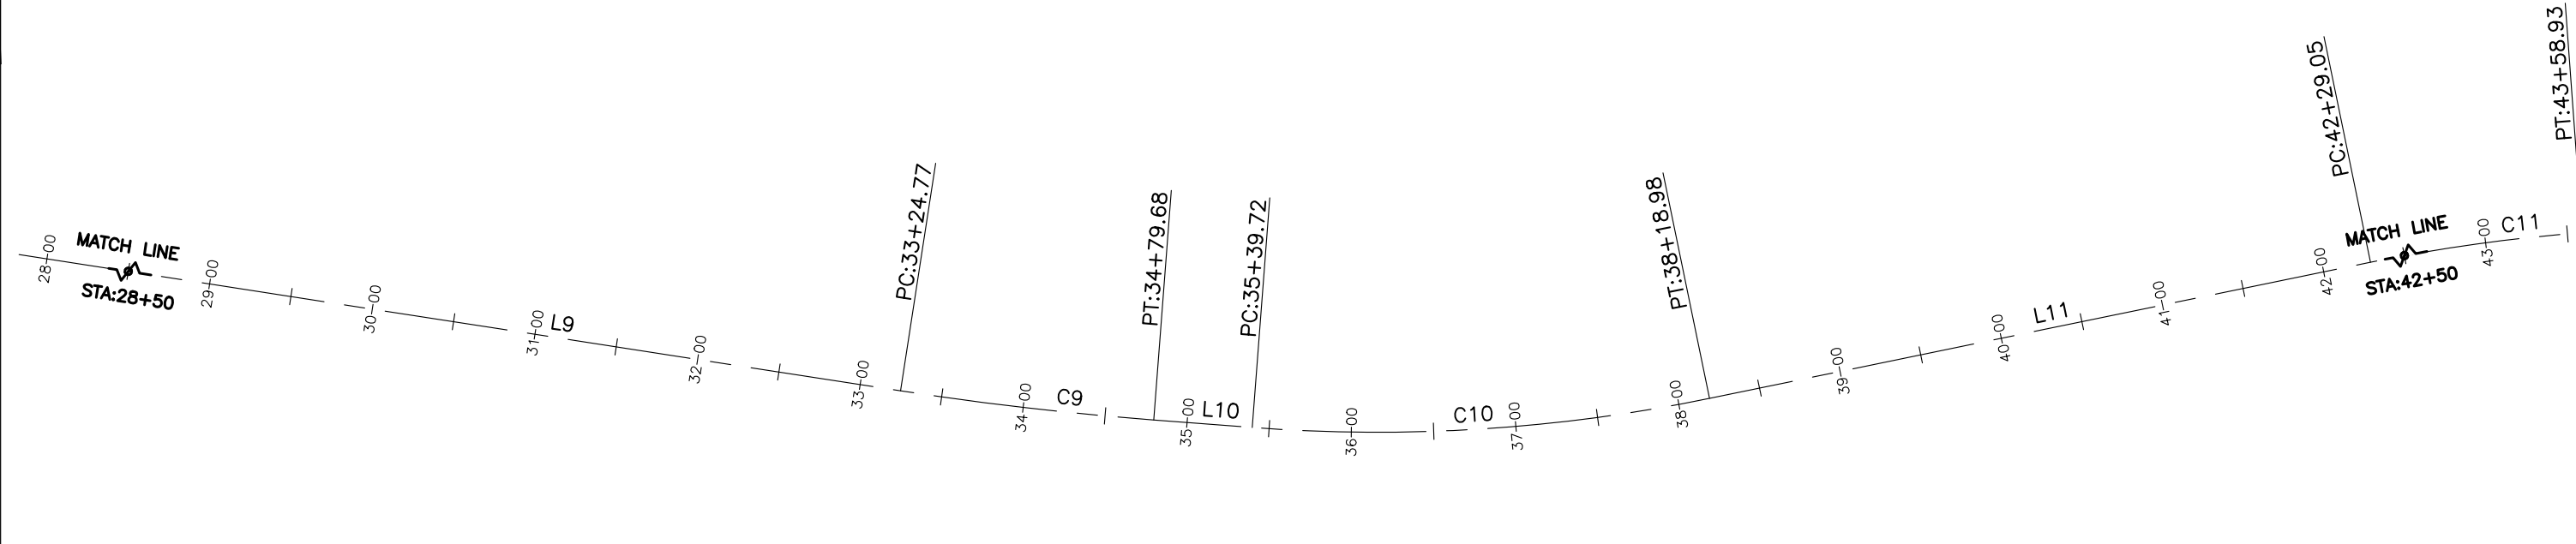


Computer File Information		Sheet Revisions				As Constructed		South Midland Ave. Improvements Geometry Plan (2)			Project No./Code	
Print Date: 7/14/20		Rev.	Date	Comments	Init.						No.: BUILD M535-006	
Last Modification Date: 4/23/2019		1				No Revisions:	-					
Drawing File Name: SMidland-GeometryPlan						Revised:	-	Engineer:	MDF	Structure	---	Code: 22933
Autocad Ver. 2018	Scale: As Shown					Void:	-	Drawn By:	AMC	Numbers	---	
SGM Project No.: 2017-211.001	Quality Control: RGN							Sheet Subset:	GEOM	Subset Sheets:	2 of 5	Sheet Number: 41





118 West Sixth Street, Suite 200
Glenwood Springs, CO 81601
970.945.1004 www.sgm-inc.com

I:\2017\2017-211-GWSSOMIDLAND\001-MIDLAND4MILERO27TH\H-DWGS\CIVIL\PS-SHEETSET\MIDLAND-GEOMETRYPLAN.DWG Plotted: 7/14/2020 3:14 PM By: Ashley Cline

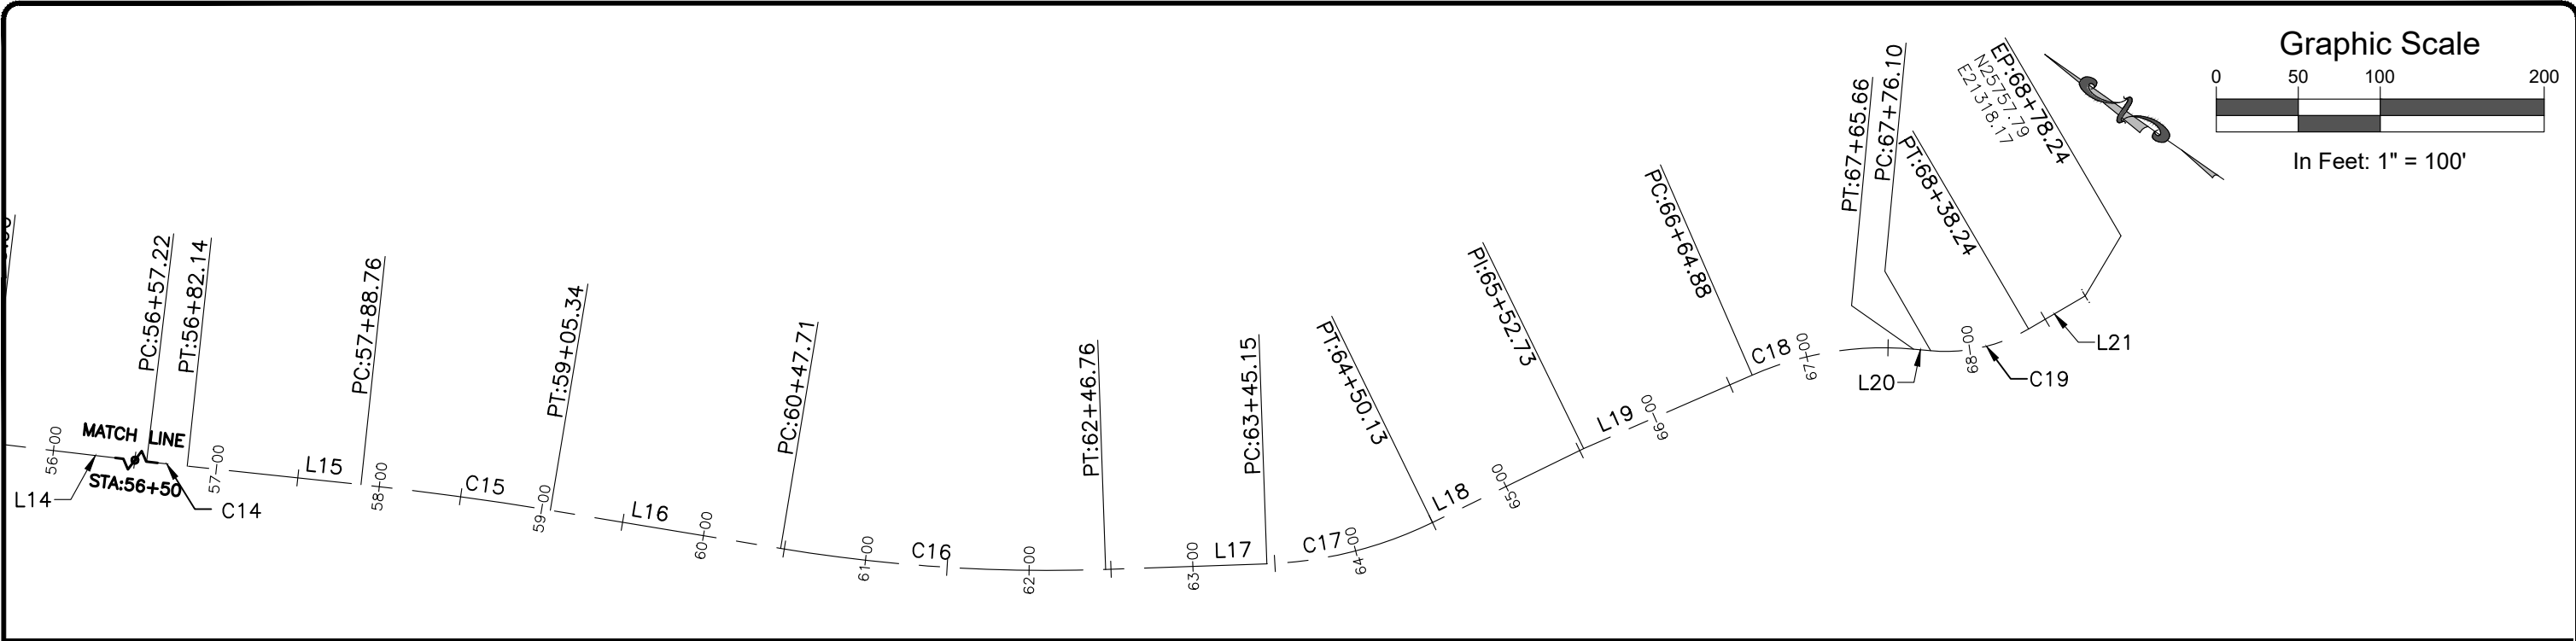

LINE TABLE		
LINE	BEARING	LENGTH
L1	S15°47'47"E	99.84'
L2	S23°23'41"E	123.74'
L3	S14°35'18"E	108.89'
L4	S13°19'15"E	308.07'
L5	S10°10'24"E	148.30'
L6	S13°53'34"E	90.49'
L7	S11°24'38"E	234.57'
L8	S24°10'22"E	359.01'
L9	S26°12'23"E	577.52'
L10	S30°38'39"E	60.04'
L11	S46°38'41"E	410.07'

L12	S39°12'12"E	549.45'
L13	S24°24'06"E	259.80'
L14	S28°13'22"E	97.32'
L15	S28°56'12"E	106.61'
L16	S25°35'49"E	142.38'
L17	S37°00'06"E	98.39'
L18	S61°03'33"E	102.60'
L19	S58°34'13"E	112.15'
L20	S29°41'56"E	10.44'
L21	S65°18'14"E	40.00'










CURVE TABLE						
CURVE	RADIUS	LENGTH	TANGENT	CHORD	BEARING	DELTA
C1	1000.00'	132.62'	66.41'	132.52'	S19°35'44"E	7° 35' 54"
C2	1000.00'	153.70'	77.00'	153.55'	S18°59'30"E	8° 48' 24"
C3	3000.00'	66.36'	33.18'	66.35'	S13°57'17"E	1° 16' 02"
C4	2000.00'	109.87'	54.95'	109.86'	S11°44'50"E	3° 08' 51"
C5	2000.00'	129.83'	64.94'	129.81'	S12°01'59"E	3° 43' 10"
C6	3000.00'	129.98'	65.00'	129.97'	S12°39'06"E	2° 28' 57"
C7	2000.00'	445.49'	223.67'	444.57'	S17°47'30"E	12° 45' 45"
C8	3000.00'	106.47'	53.24'	106.47'	S25°11'23"E	2° 02' 00"
C9	2000.00'	154.91'	77.49'	154.87'	S28°25'31"E	4° 26' 16"
C10	1000.00'	279.26'	140.55'	278.36'	S38°38'40"E	16° 00' 02"

CURVE TABLE						
CURVE	RADIUS	LENGTH	TANGENT	CHORD	BEARING	DELTA
C11	1000.00'	129.88'	65.03'	129.79'	S42°55'26"E	7° 26' 29"
C12	1000.00'	258.34'	129.89'	257.62'	S31°48'09"E	14° 48' 06"
C13	2000.00'	133.38'	66.72'	133.36'	S26°18'44"E	3° 49' 16"
C14	2000.00'	24.92'	12.46'	24.92'	S28°34'47"E	0° 42' 50"
C15	2000.00'	116.58'	58.31'	116.56'	S27°16'01"E	3° 20' 23"
C16	1000.00'	199.05'	99.85'	198.72'	S31°17'58"E	11° 24' 17"
C17	250.00'	104.97'	53.27'	104.20'	S49°01'50"E	24° 03' 27"
C18	200.00'	100.78'	51.48'	99.72'	S44°08'05"E	28° 52' 17"
C19	100.00'	62.14'	32.11'	61.15'	S47°30'05"E	35° 36' 18"

Computer File Information		Sheet Revisions				As Constructed		South Midland Ave. Improvements Geometry Plan (3)				Project No./Code	
Print Date: 7/14/20		Rev.	Date	Comments	Init.	No Revisions:	-	Engineer: MDF Structure --- Drawn By: AMC Numbers --- Sheet Subset: GEOM Subset Sheets: 3 of 5				No.: BUILD M535-006	
Last Modification Date: 4/23/2019		1				Revised:	-					Code: 22933	
Drawing File Name: SMidland-GeometryPlan						Void:	-					Sheet Number: 42	
Autocad Ver. 2018	Scale: As Shown	Units: English											
SGM Project No.: 2017-211.001	Quality Control: RGN												



I:\2017\2017-211-GWSSMIDLAND\001-MIDLAND4MILERO27THST\H-DWGS\CIVIL\PS-SHEETSET\SMIDLAND-GEOMETRYPLAN-INTERSECTIONS.DWG Plotted: 7/14/2020 3:15 PM By: Ashley Cline

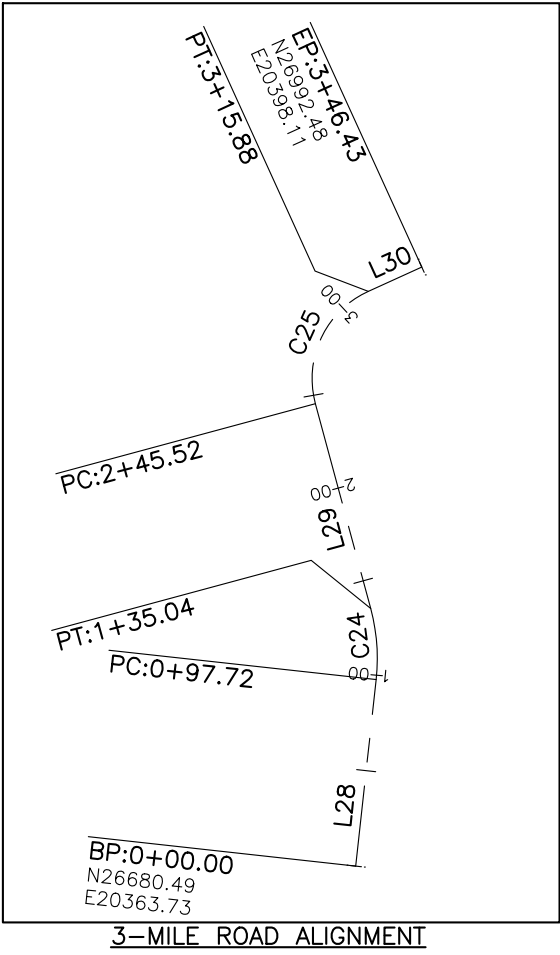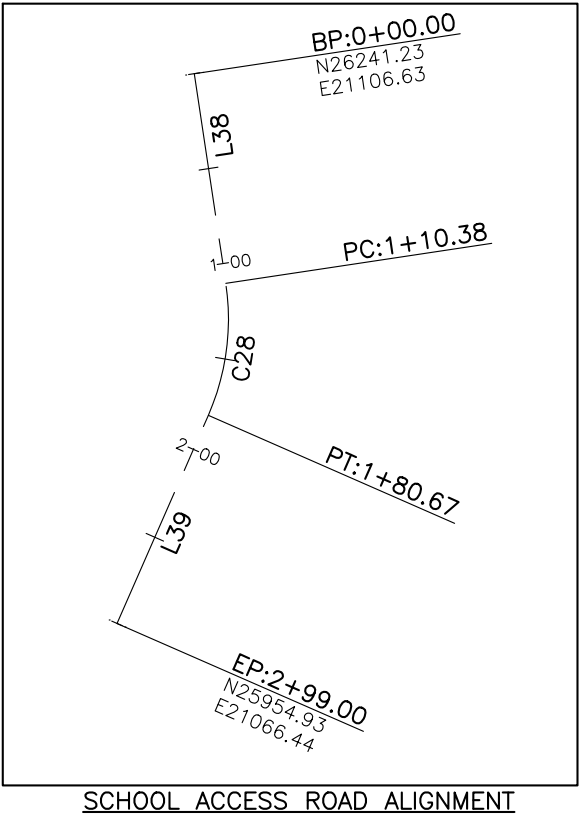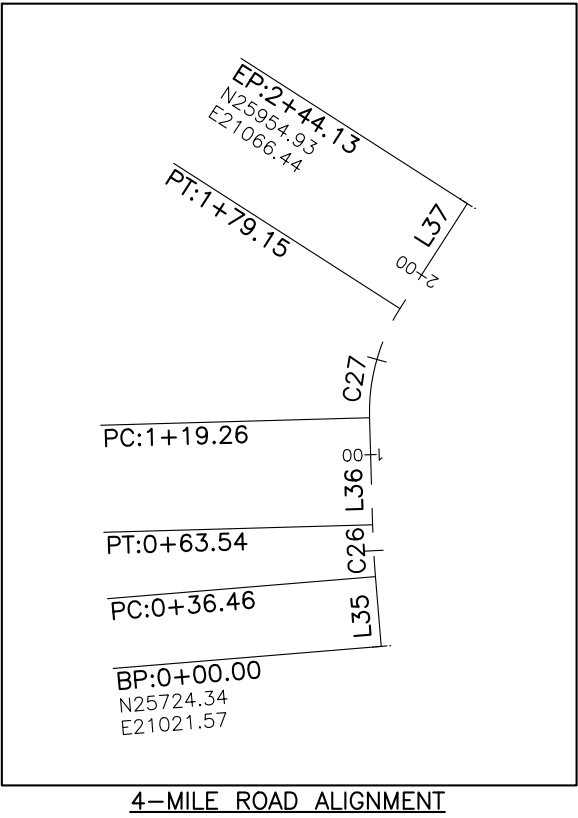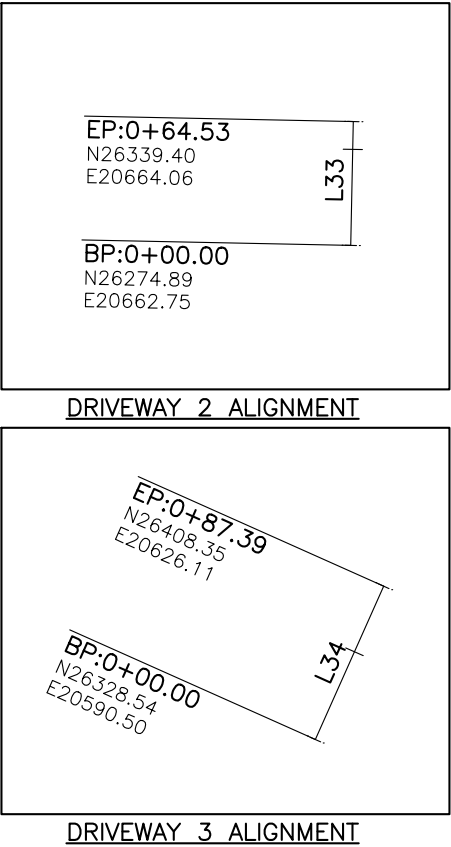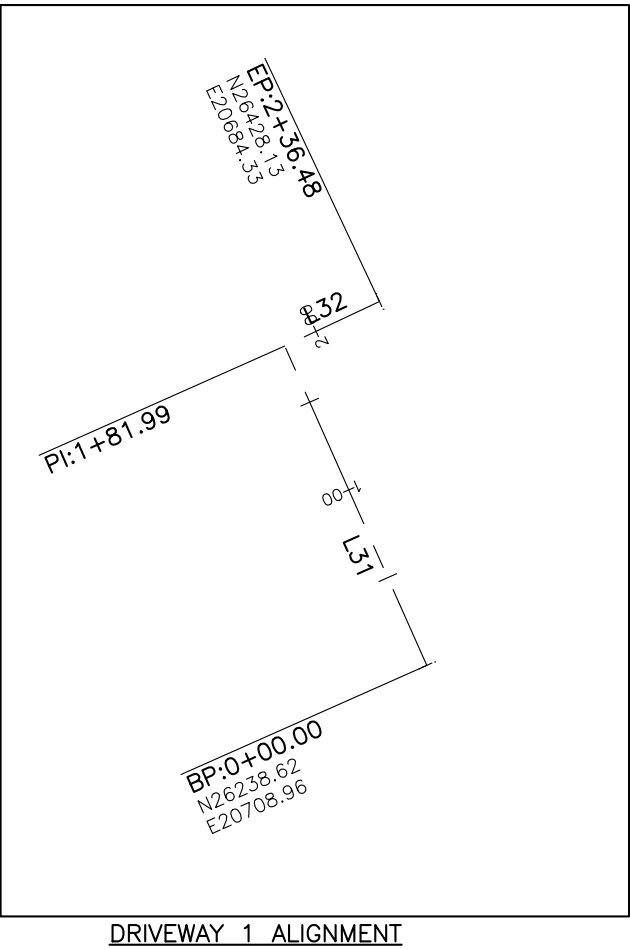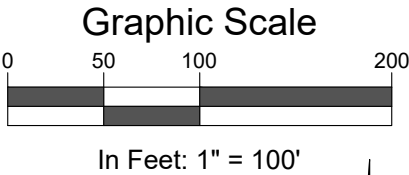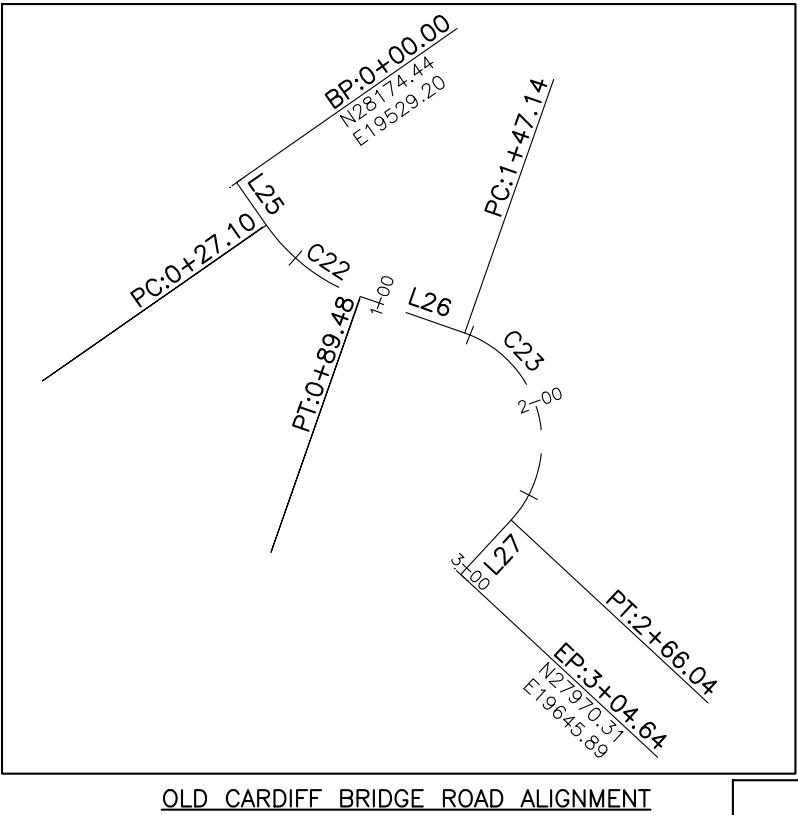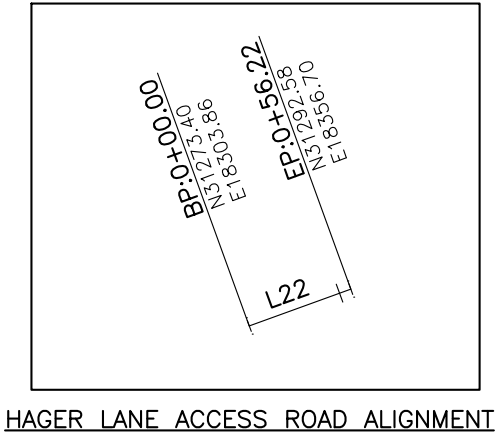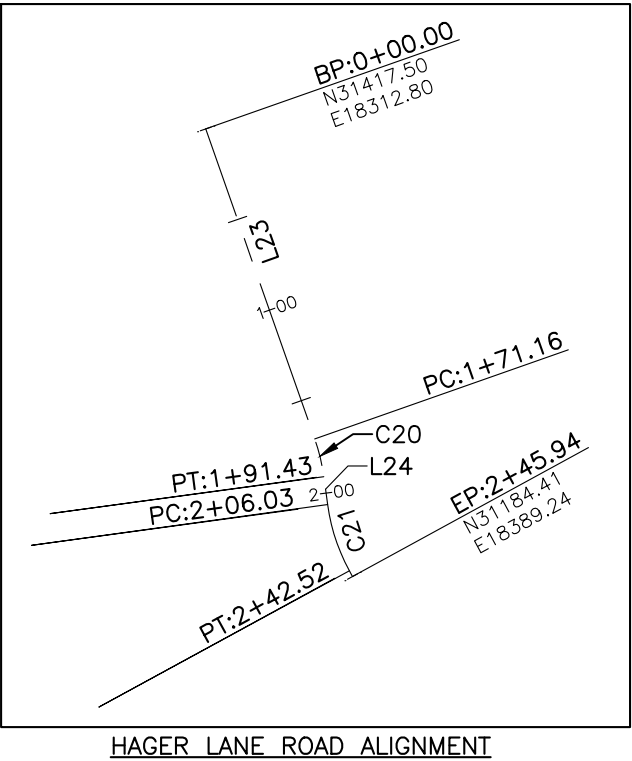

Computer File Information		Sheet Revisions			
Print Date:	7/14/20	Rev.	Date	Comments	Init.
Last Modification Date:	4/23/2019	1			
Drawing File Name:	SMidland-GeometryPlan-Intersections				
Autocad Ver.	2018				
Scale:	As Shown				
Units:	English				
SGM Project No.:	2017-211.001				
Quality Control:	RGN				

 GLENWOOD SPRINGS COLORADO	 SGM 118 West Sixth Street, Suite 200 Glenwood Springs, CO 81601 970.945.1004 www.sgm-inc.com	As Constructed		South Midland Ave. Improvements			Project No./Code		
		No Revisions: -		Geometry Plan (4)			No.: BUILD M535-006		
		Revised: -		Engineer:	MDF	Structure	---	Code: 22933	
		Void: -		Drawn By:	AMC	Numbers	---	Sheet Number: 43	
				Sheet Subset:	GEOM	Subset Sheets: 4 of 5			


I:\2017\2017-211-GWSSOMIDLAND\001-MIDLAND4MILERO27THST\H-DWGS\CIVIL\PS-SHEETSET\SMIDLAND-GEOMETRYPLAN-INTERSECTIONS.DWG Plotted: 7/14/2020 3:15 PM By: Ashley Cline

LINE TABLE		
LINE	BEARING	LENGTH
L25	S34°55'56"E	27.10'
L26	S70°40'28"E	57.67'
L27	S42°51'34"W	38.60'
L28	N6°16'24"E	97.72'
L29	N15°06'24"W	110.48'
L30	N65°31'00"E	30.55'
L31	N23°58'04"W	181.99'
L32	N64°47'19"E	54.49'
L33	N1°09'54"E	64.53'
L34	N24°02'49"E	87.39'
L35	N4°42'55"W	36.46'
L36	N1°36'46"W	55.72'
L37	N32°42'22"E	64.98'
L38	S8°33'18"E	110.38'
L39	S23°39'47"W	118.33'



CURVE TABLE						
CURVE	RADIUS	LENGTH	TANGENT	CHORD	BEARING	DELTA
C20	100.00'	20.27'	10.17'	20.23'	S13°33'22"E	11° 36' 45"
C21	100.00'	36.49'	18.45'	36.28'	S18°12'08"E	20° 54' 19"
C22	100.00'	62.38'	32.24'	61.38'	S52°48'12"E	35° 44' 32"
C23	60.00'	118.89'	91.57'	100.37'	S13°54'27"E	113° 32' 02"
C24	100.00'	37.32'	18.88'	37.10'	N4°25'00"W	21° 22' 49"
C25	50.00'	70.36'	42.42'	64.69'	N25°12'18"E	80° 37' 24"
C26	500.00'	27.07'	13.54'	27.07'	N3°09'51"W	3° 06' 08"
C27	100.00'	59.90'	30.88'	59.01'	N15°32'48"E	34° 19' 08"
C28	125.00'	70.29'	36.10'	69.37'	S7°33'15"W	32° 13' 05"

Computer File Information		Sheet Revisions				As Constructed		South Midland Ave. Improvements Geometry Plan (5)			Project No./Code	
Print Date: 7/14/20		Rev.	Date	Comments	Init.						No.: BUILD M535-006	
Last Modification Date: 4/23/2019		1				No Revisions:	-					
Drawing File Name: SMidland-GeometryPlan-Intersections						Revised:	-	Engineer: MDF	Structure	---	Code: 22933	
Autocad Ver. 2018 Scale: As Shown Units: English						Void:	-	Drawn By: AMC	Numbers	---		
SGM Project No.: 2017-211.001 Quality Control: RGN								Sheet Subset: GEOM	Subset Sheets:	5 of 5	Sheet Number: 44	

I:\2017\2017-211-GWSSMIDLAND\001-MIDLAND4MILERO27THST\H-DWGS\CIVIL\PS-SHEETSET\SMIDLAND-PP(1).DWG Plotted: 7/14/2020 3:16 PM By: Ashley Cline


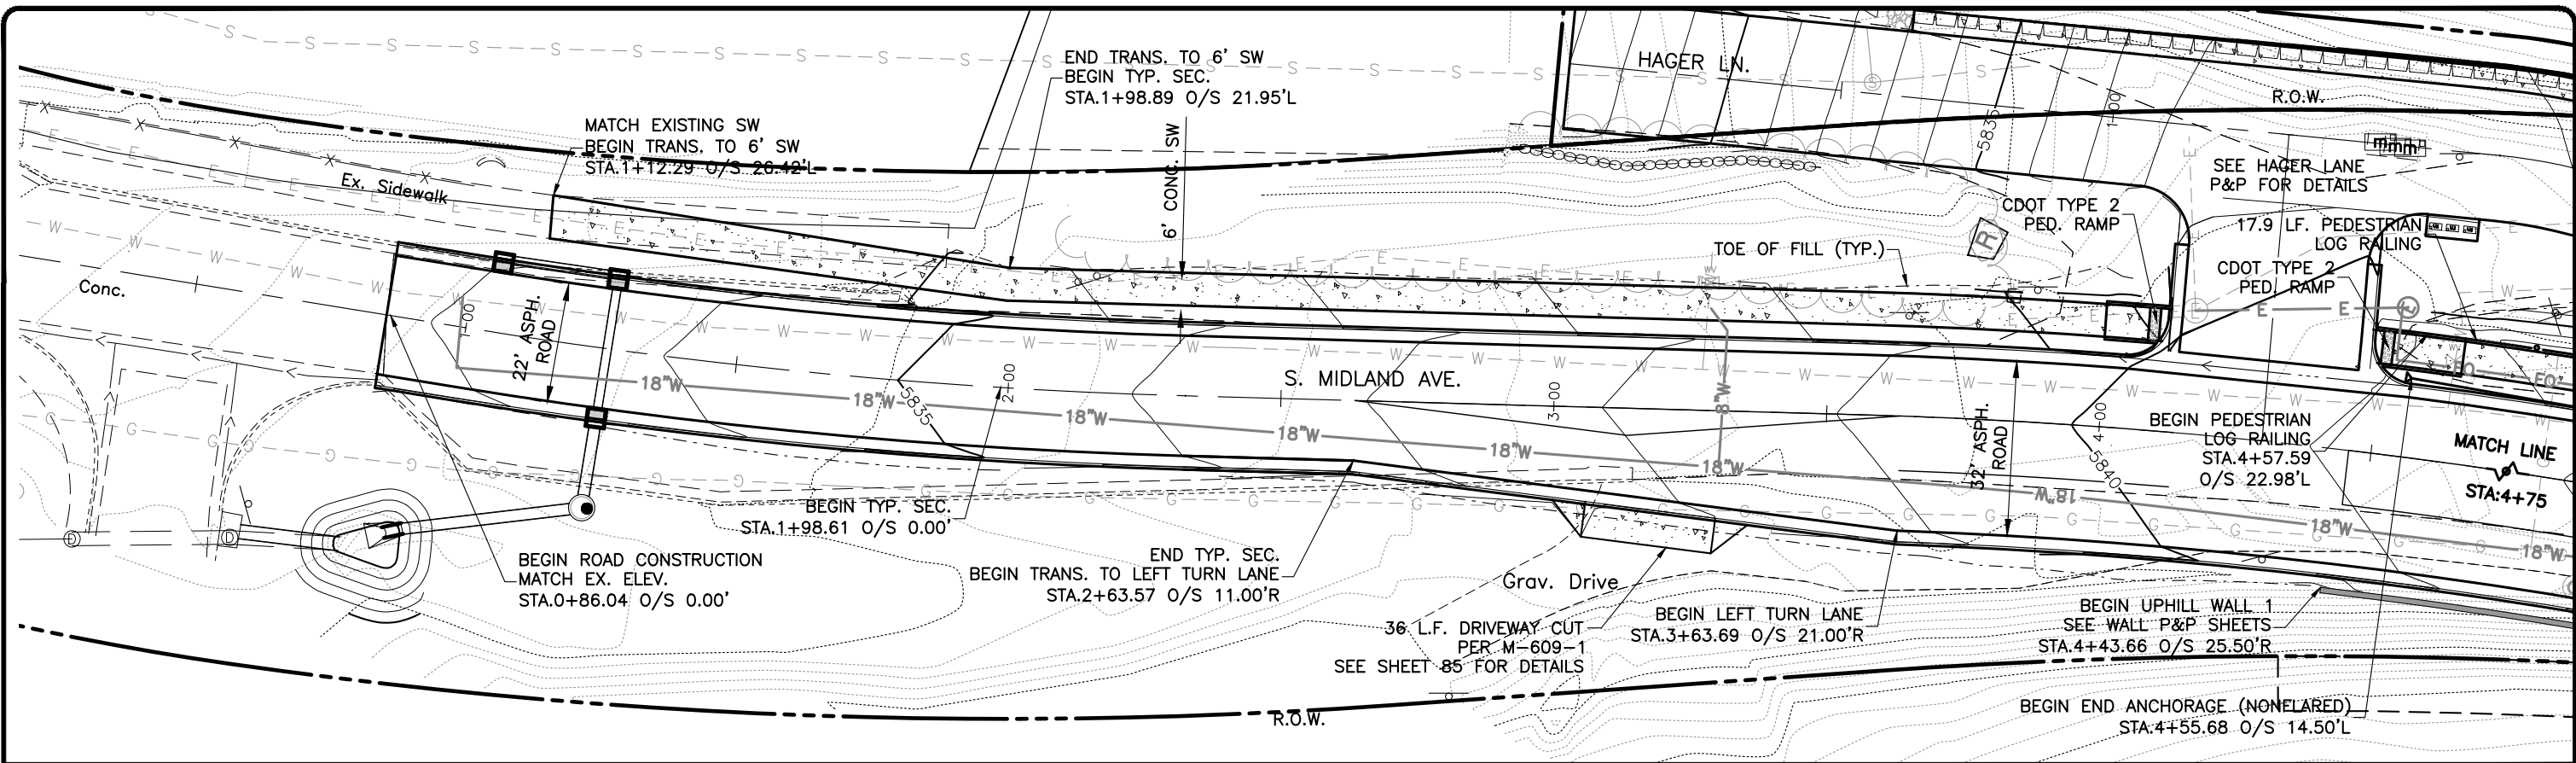


Graphic Scale

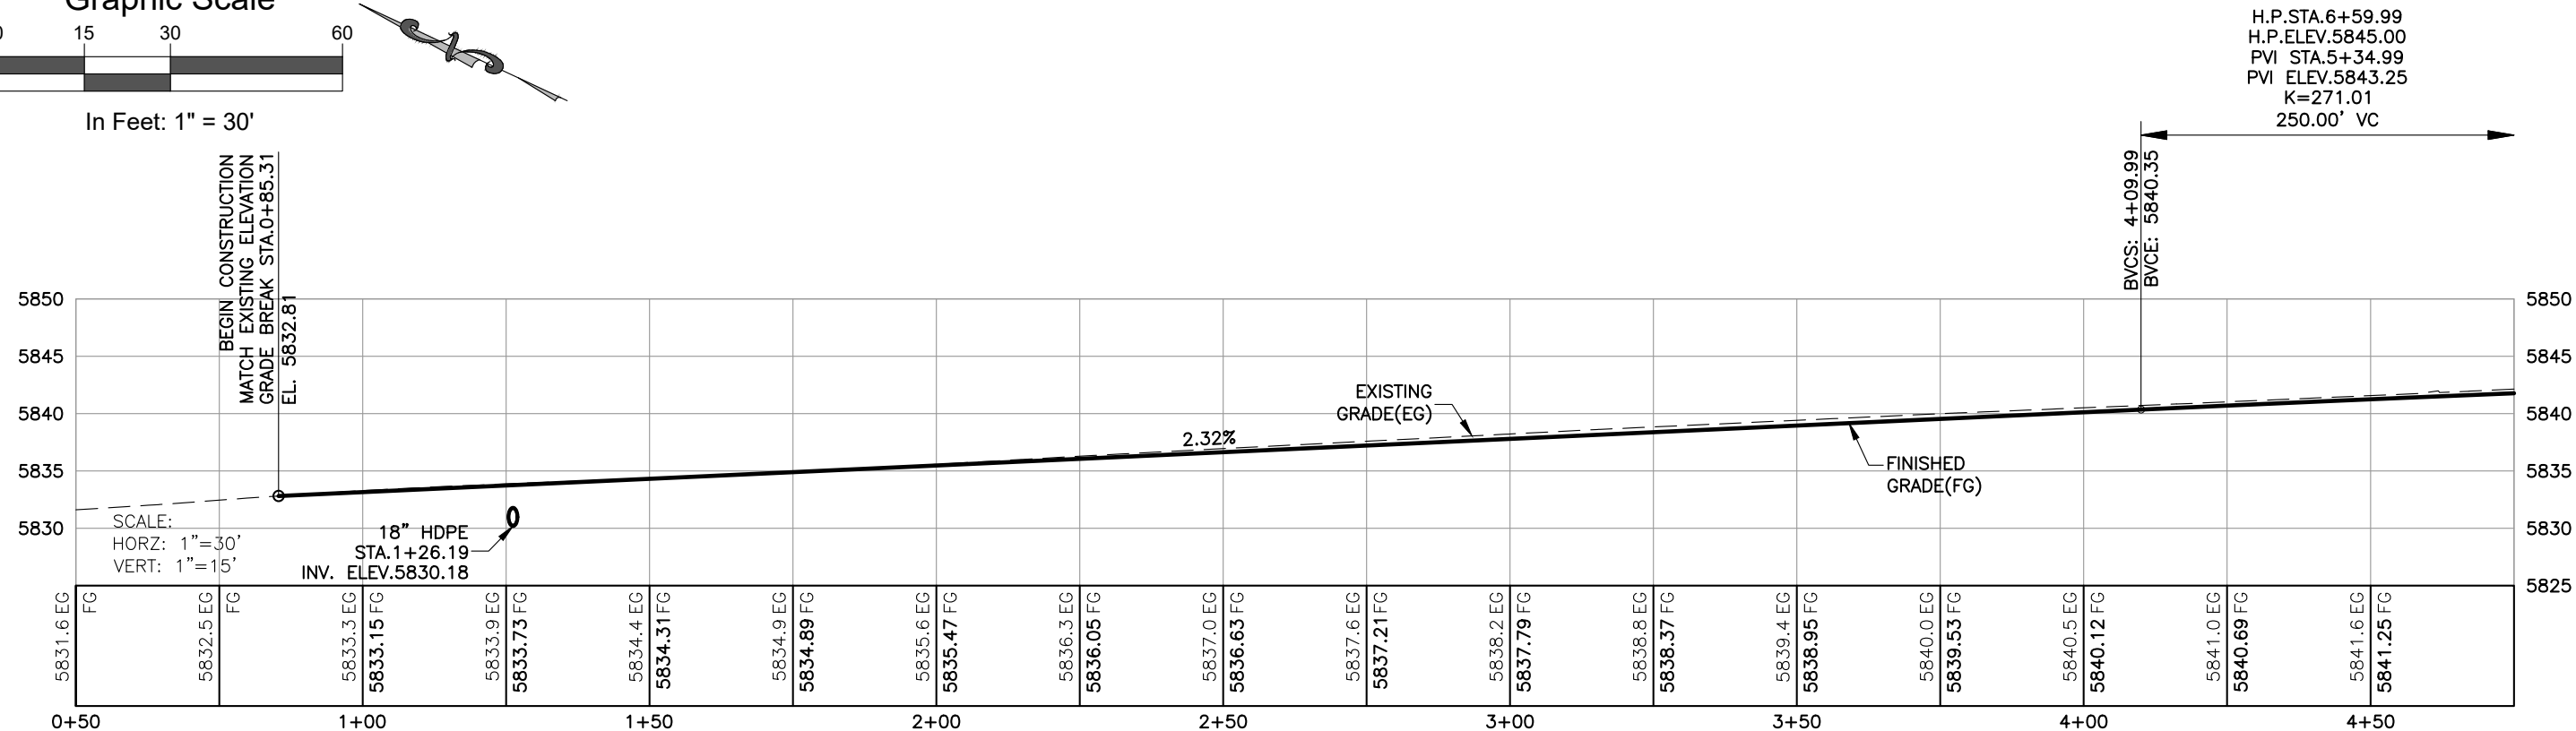 

Computer File Information		Sheet Revisions			GLENWOOD SPRINGS COLORADO	SGM	As Constructed		South Midland Ave. Improvements			Project No./Code	
Print Date: 7/14/20	Last Modification Date: 4/23/2019	Rev.	Date	Comments			No Revisions:	-	Plan & Profile 0+00 - 4+75			No.:	BUILD M535-006
Drawing File Name: SMidland-PP(1)	Autocad Ver. 2018	Scale: As Shown	Units: English	SGM Project No.: 2017-211.001	Quality Control: RGN	118 West Sixth Street, Suite 200 Glenwood Springs, CO 81601 970.945.1004 www.sgm-inc.com	Revised:	-	Engineer: MDF	Structure: ---	Code: 22933	Sheet Number:	45
							Void:	-	Drawn By: AMC	Numbers: ---			
									Sheet Subset: RDWY	Subset Sheets: 1 of 45			

I:\2017\2017-211-GWSSMIDLAND\001-MIDLAND4MILERD27THST\H-DWGS\CIVIL\PS-SHEETSET\SMIDLAND-PP(1).DWG Plotted: 7/15/2020 11:15 AM By: Ashley Cline

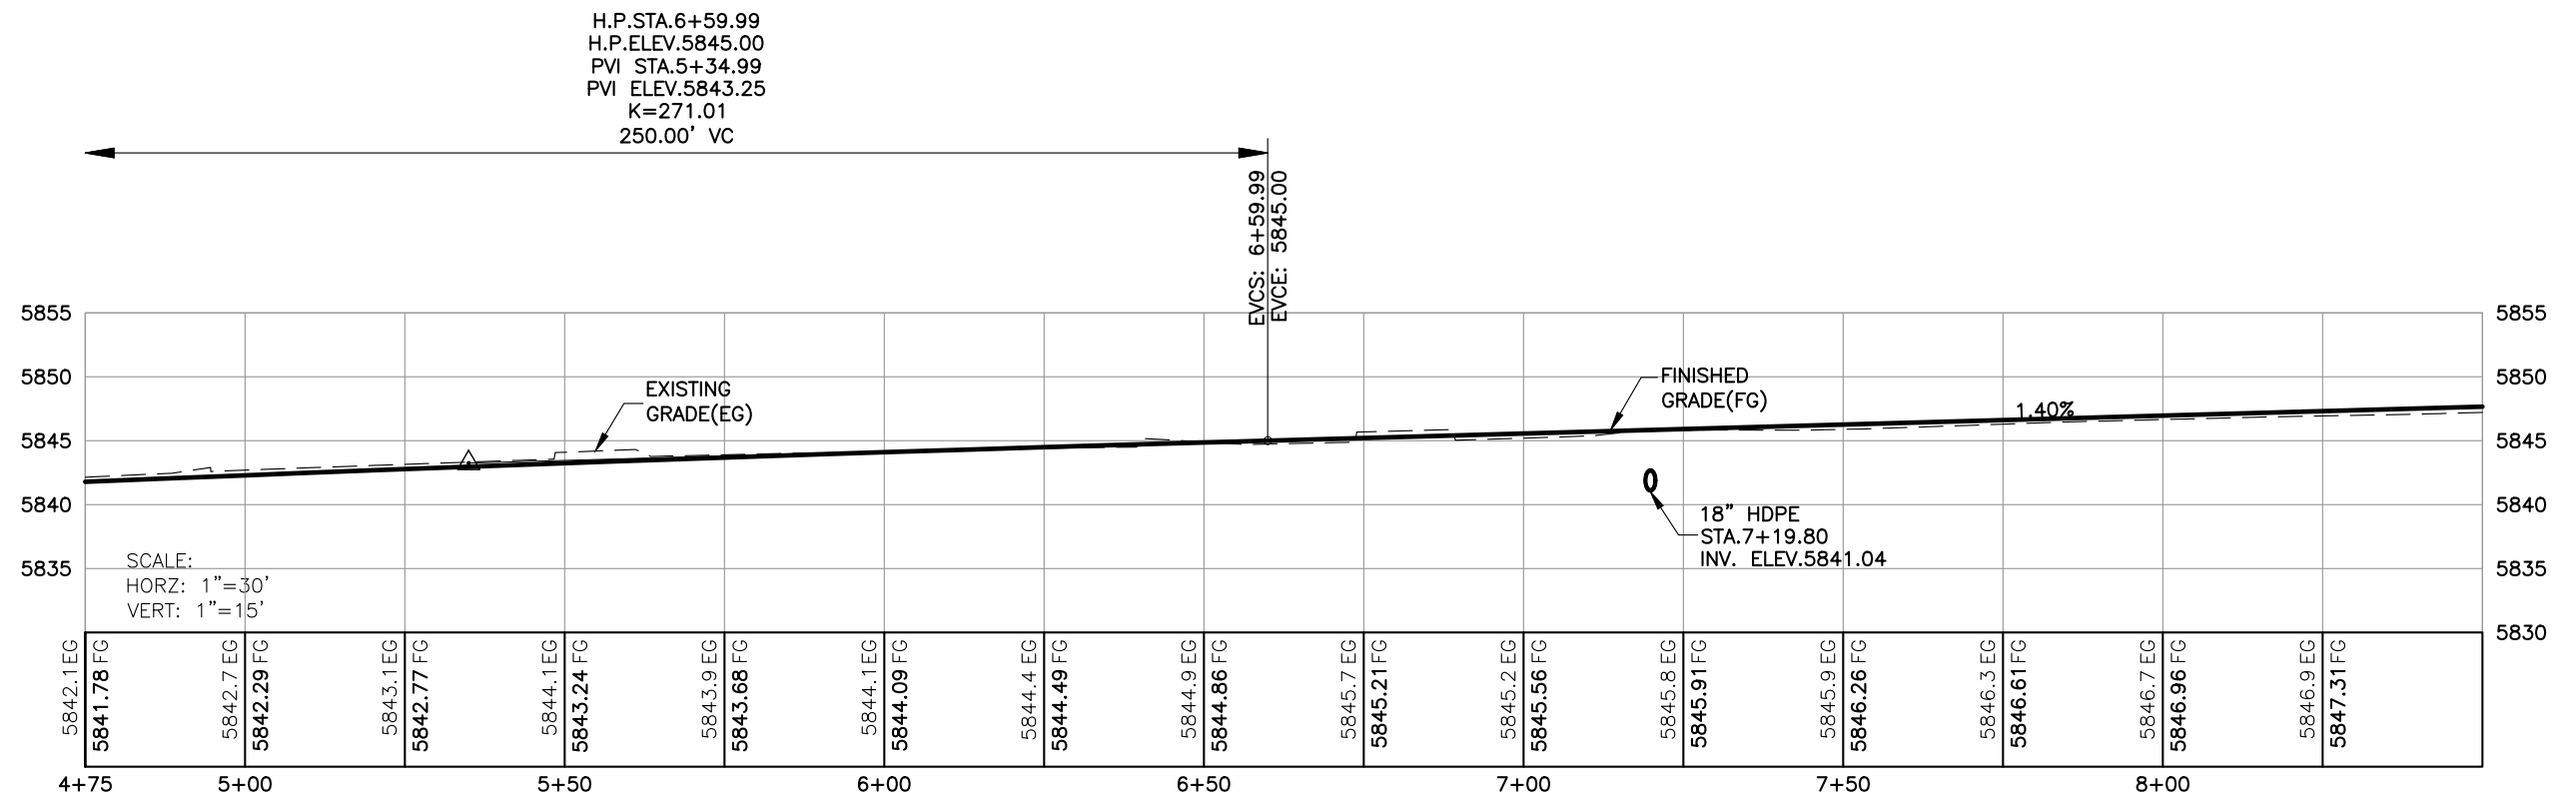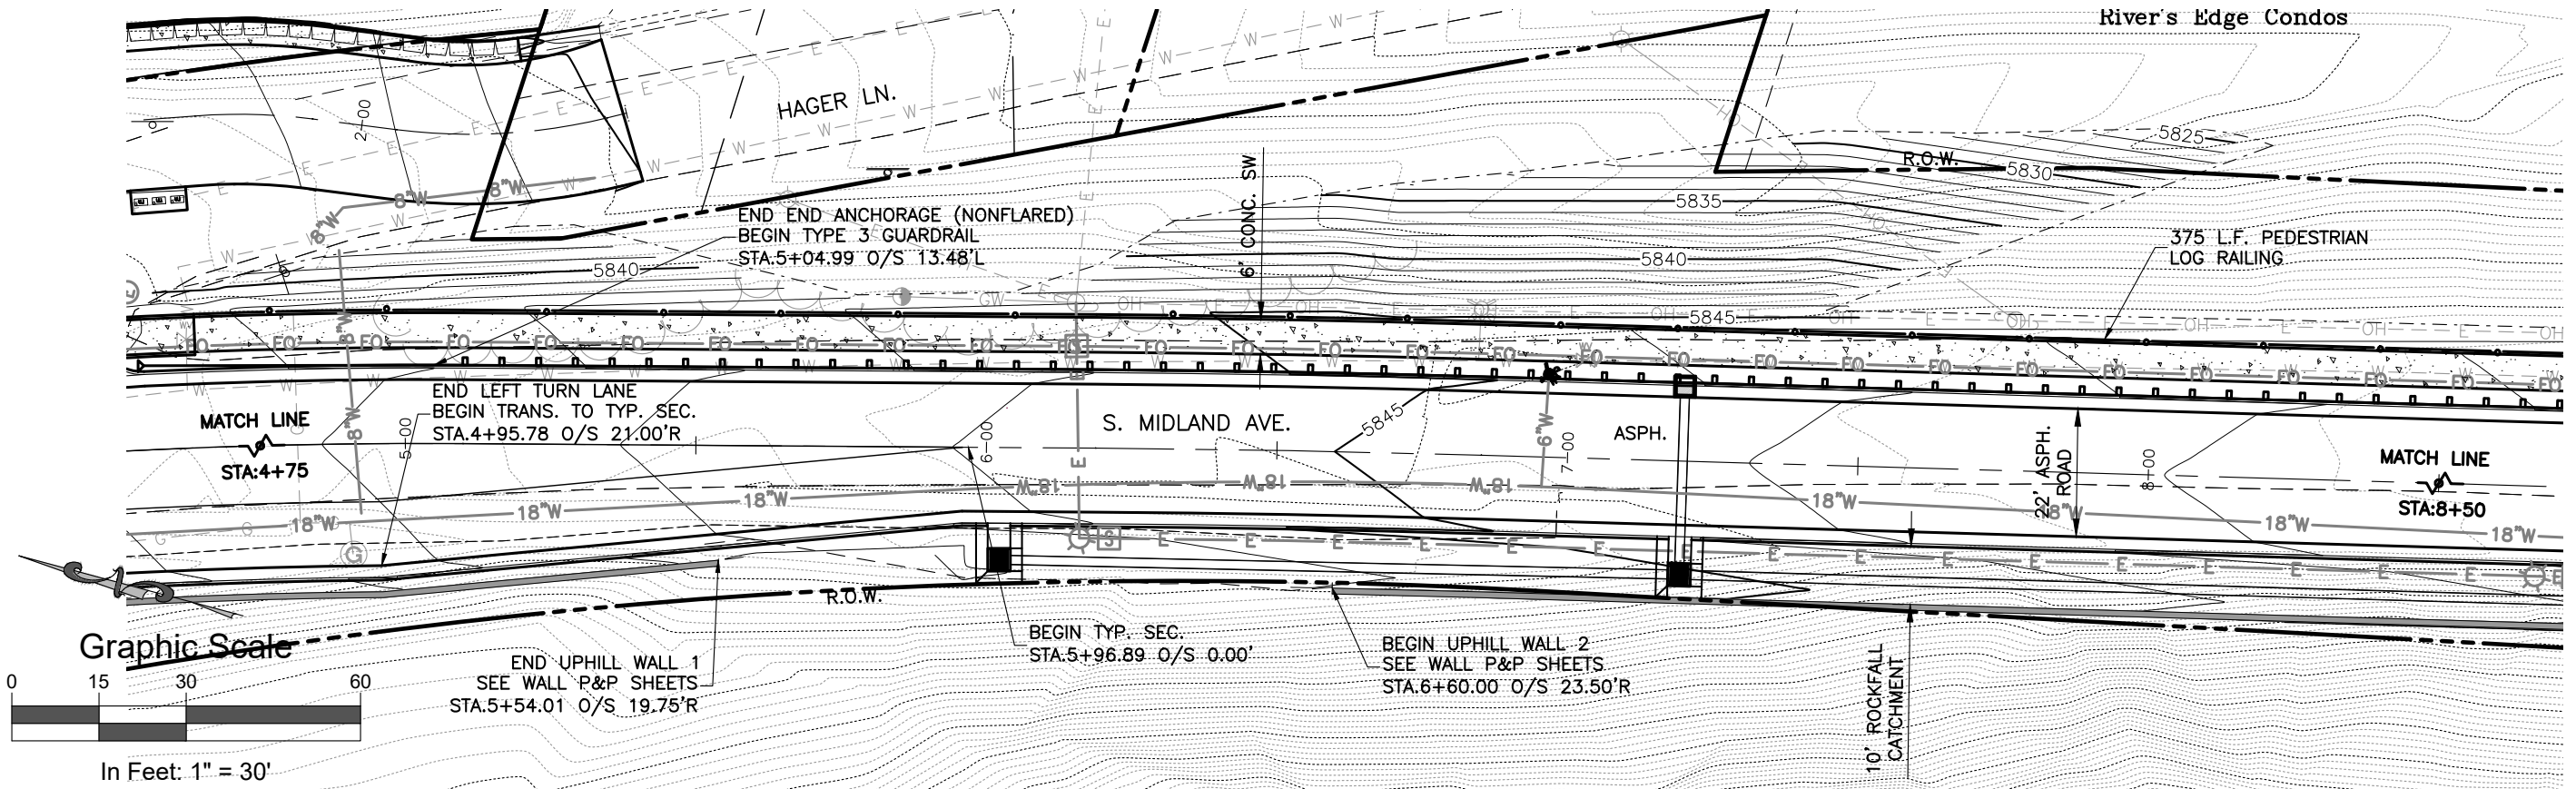



Computer File Information	
Print Date:	7/15/20
Last Modification Date:	4/23/2019
Drawing File Name:	SMidland-PP(1)
Autocad Ver.	2018
Scale:	As Shown
Units:	English
SGM Project No.:	2017-211.001
Quality Control:	RGN

Sheet Revisions			
Rev.	Date	Comments	Init.
1			

118 West Sixth Street, Suite 200
Glenwood Springs, CO 81601
970.945.1004 www.sgm-inc.com

As Constructed		South Midland Ave. Improvements			Project No./Code	
No Revisions:		Plan & Profile 4+75 - 8+50			No.:	BUILD M535-006
Revised:		Engineer:	MDF	Structure	Code: 22933	
Void:		Drawn By:	AMC	Numbers	Sheet Number: 46	
		Sheet Subset:	RDWY	Subset Sheets:	2 of 45	

I:\2017\2017-211-GWSSOMIDLAND\001-MIDLAND4MILERD27THST\H-DWGS\CIVIL\PS-SHEETSET\SMIDLAND-PP(1).DWG Plotted: 7/15/2020 11:15 AM By: Ashley Cline

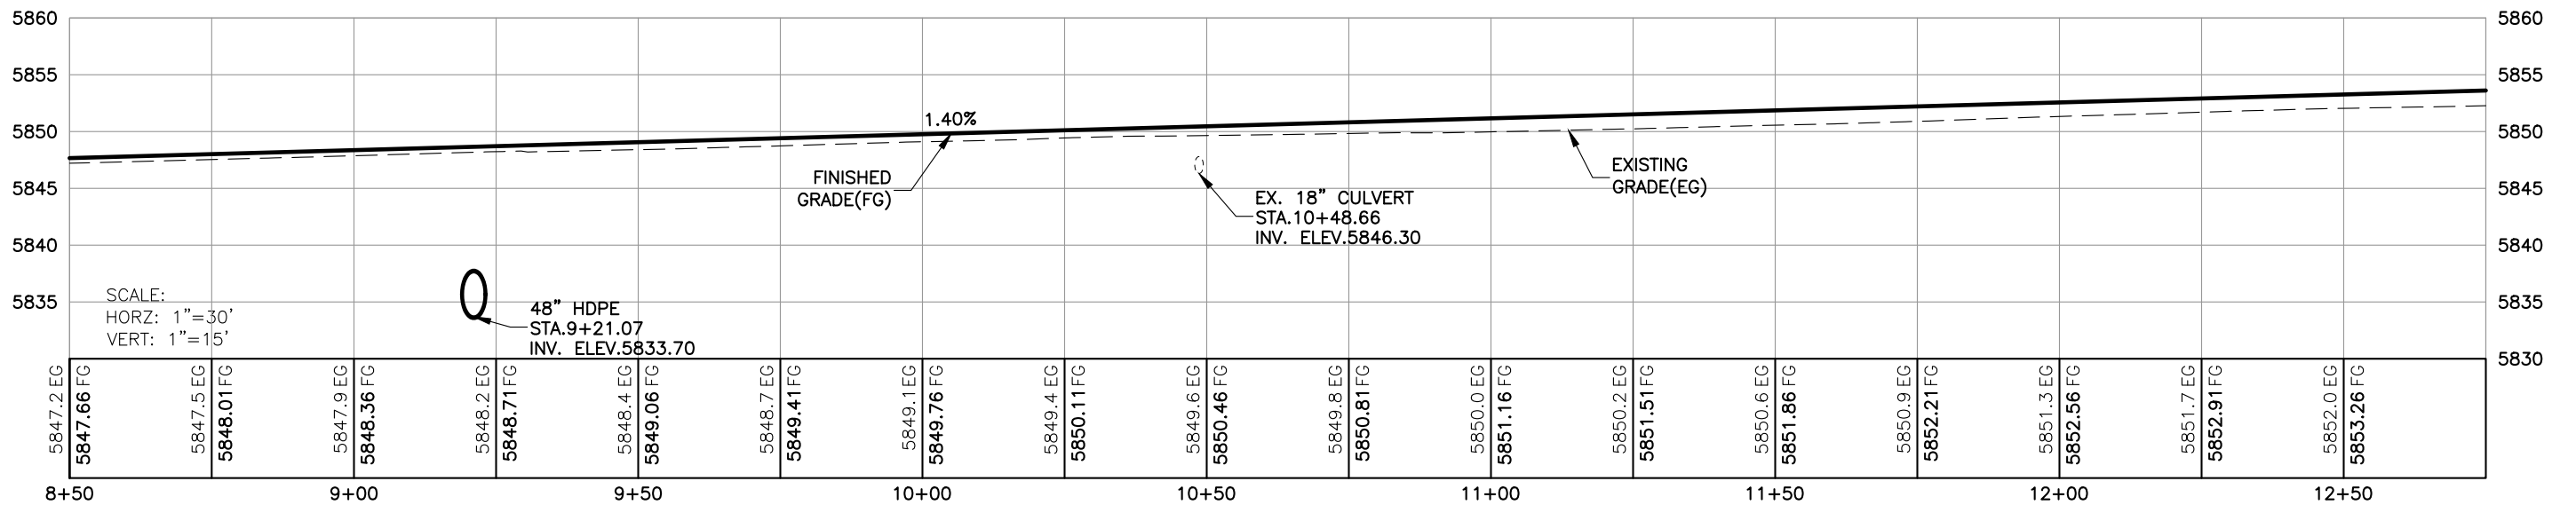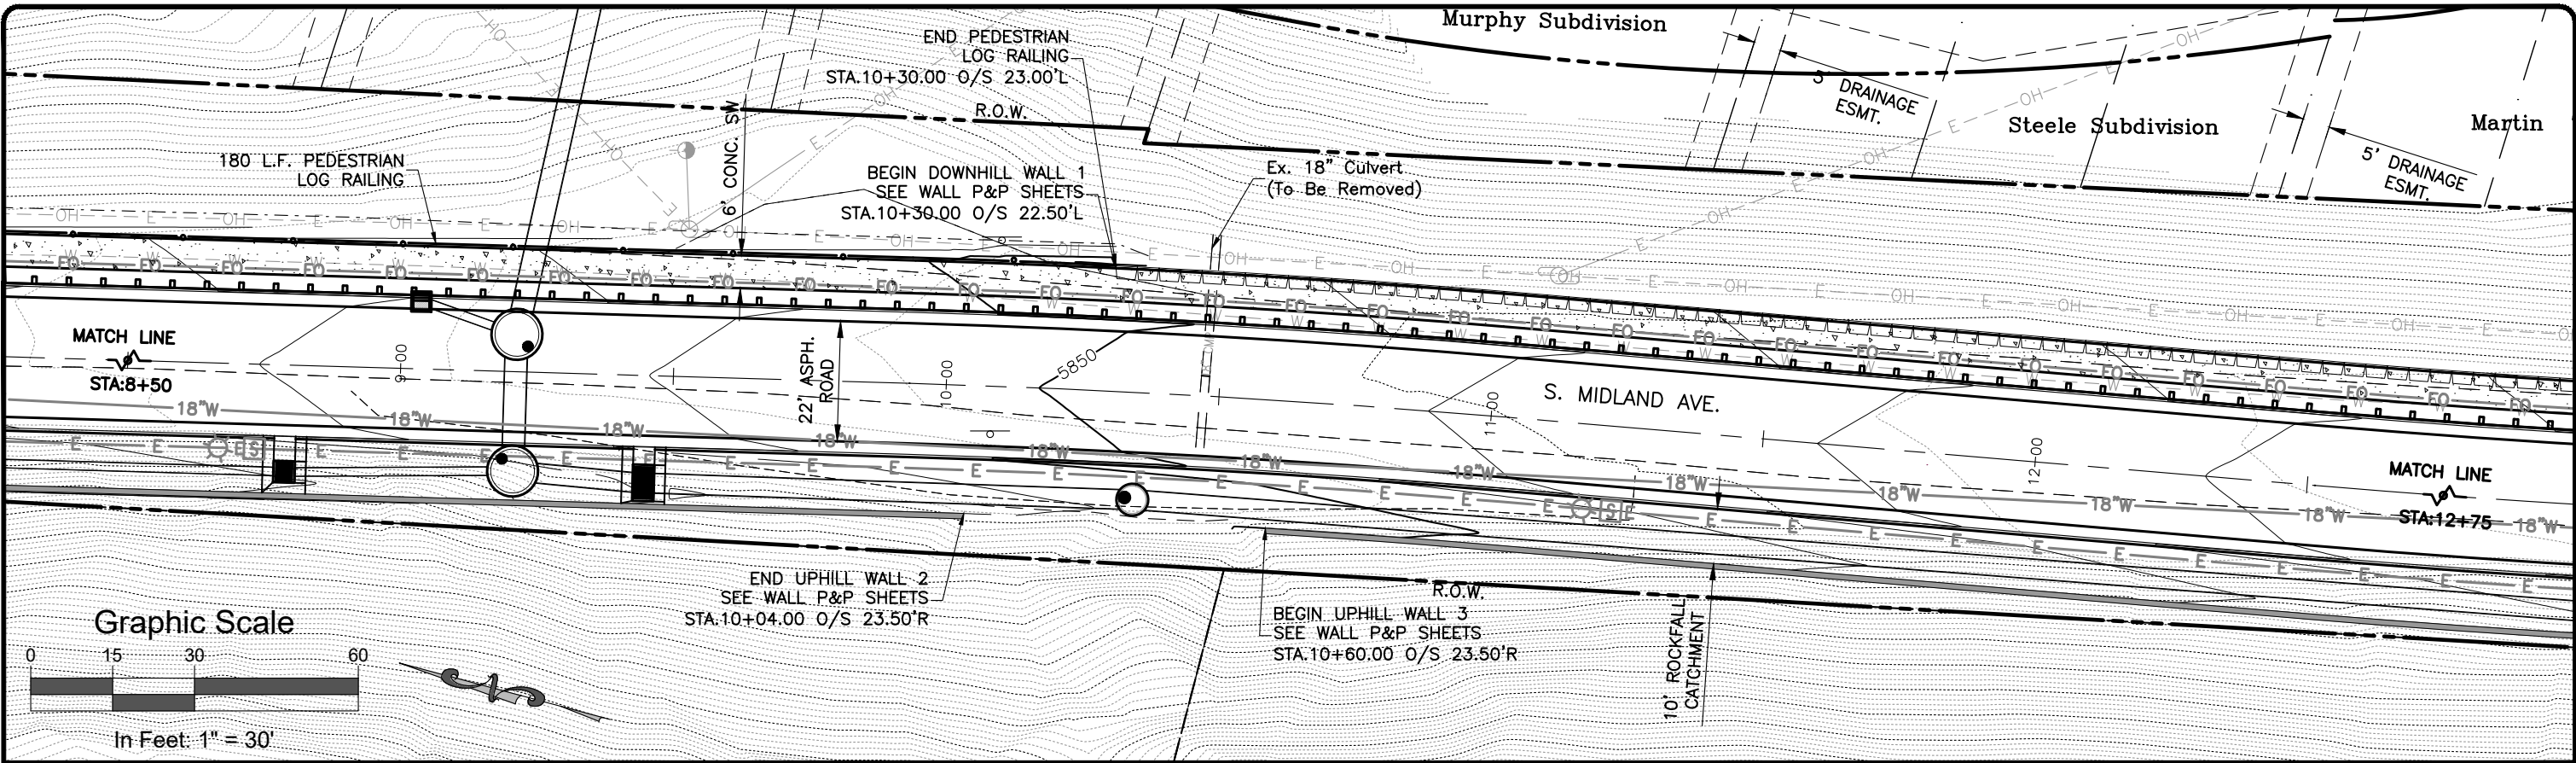

Computer File Information		Sheet Revisions					 118 West Sixth Street, Suite 200 Glenwood Springs, CO 81601 970.945.1004 www.sgm-inc.com	As Constructed		South Midland Ave. Improvements Plan & Profile 8+50 - 12+75			Project No./Code	
Print Date: 7/15/20		Rev.	Date	Comments	Init.			No Revisions: -		Engineer: MDF Structure --- Drawn By: AMC Numbers ---			No.: BUILD M535-006	
Last Modification Date: 4/23/2019		1						Revised: -					Code: 22933	
Drawing File Name: SMidland-PP(1)								Void: -		Sheet Subset: RDWY Subset Sheets: 3 of 45		Sheet Number: 47		
Autocad Ver. 2018 Scale: As Shown Units: English														
SGM Project No.: 2017-211.001 Quality Control: RGN														





GLENWOOD
SPRINGS
COLORADO



118 West Sixth Street, Suite 200
Glenwood Springs, CO 81601
970.945.1004 www.sgm-inc.com



I:\2017\211-GWSSMIDLAND\001-MIDLAND4MILRD27THST\H-DWGS\CIVIL\PS-SHEETSET\SMIDLAND-PP(1).DWG Plotted: 7/15/2020 11:16 AM By: Ashley Cline

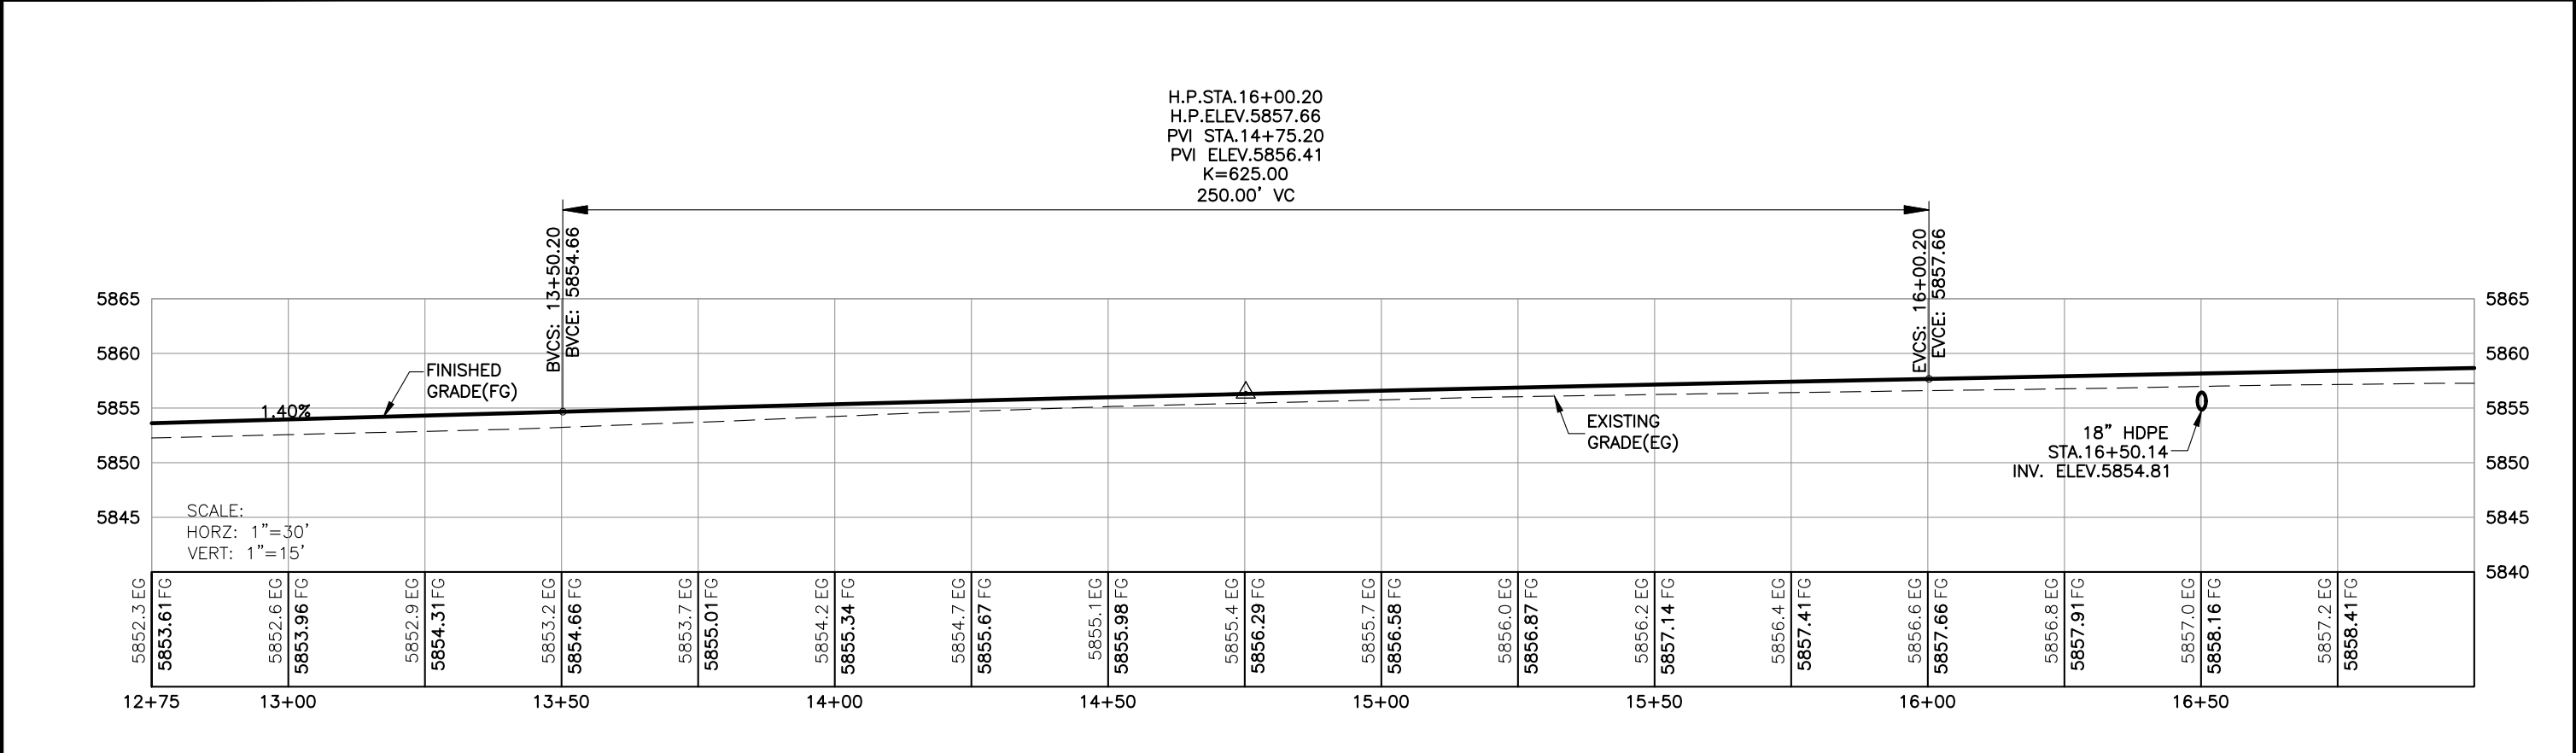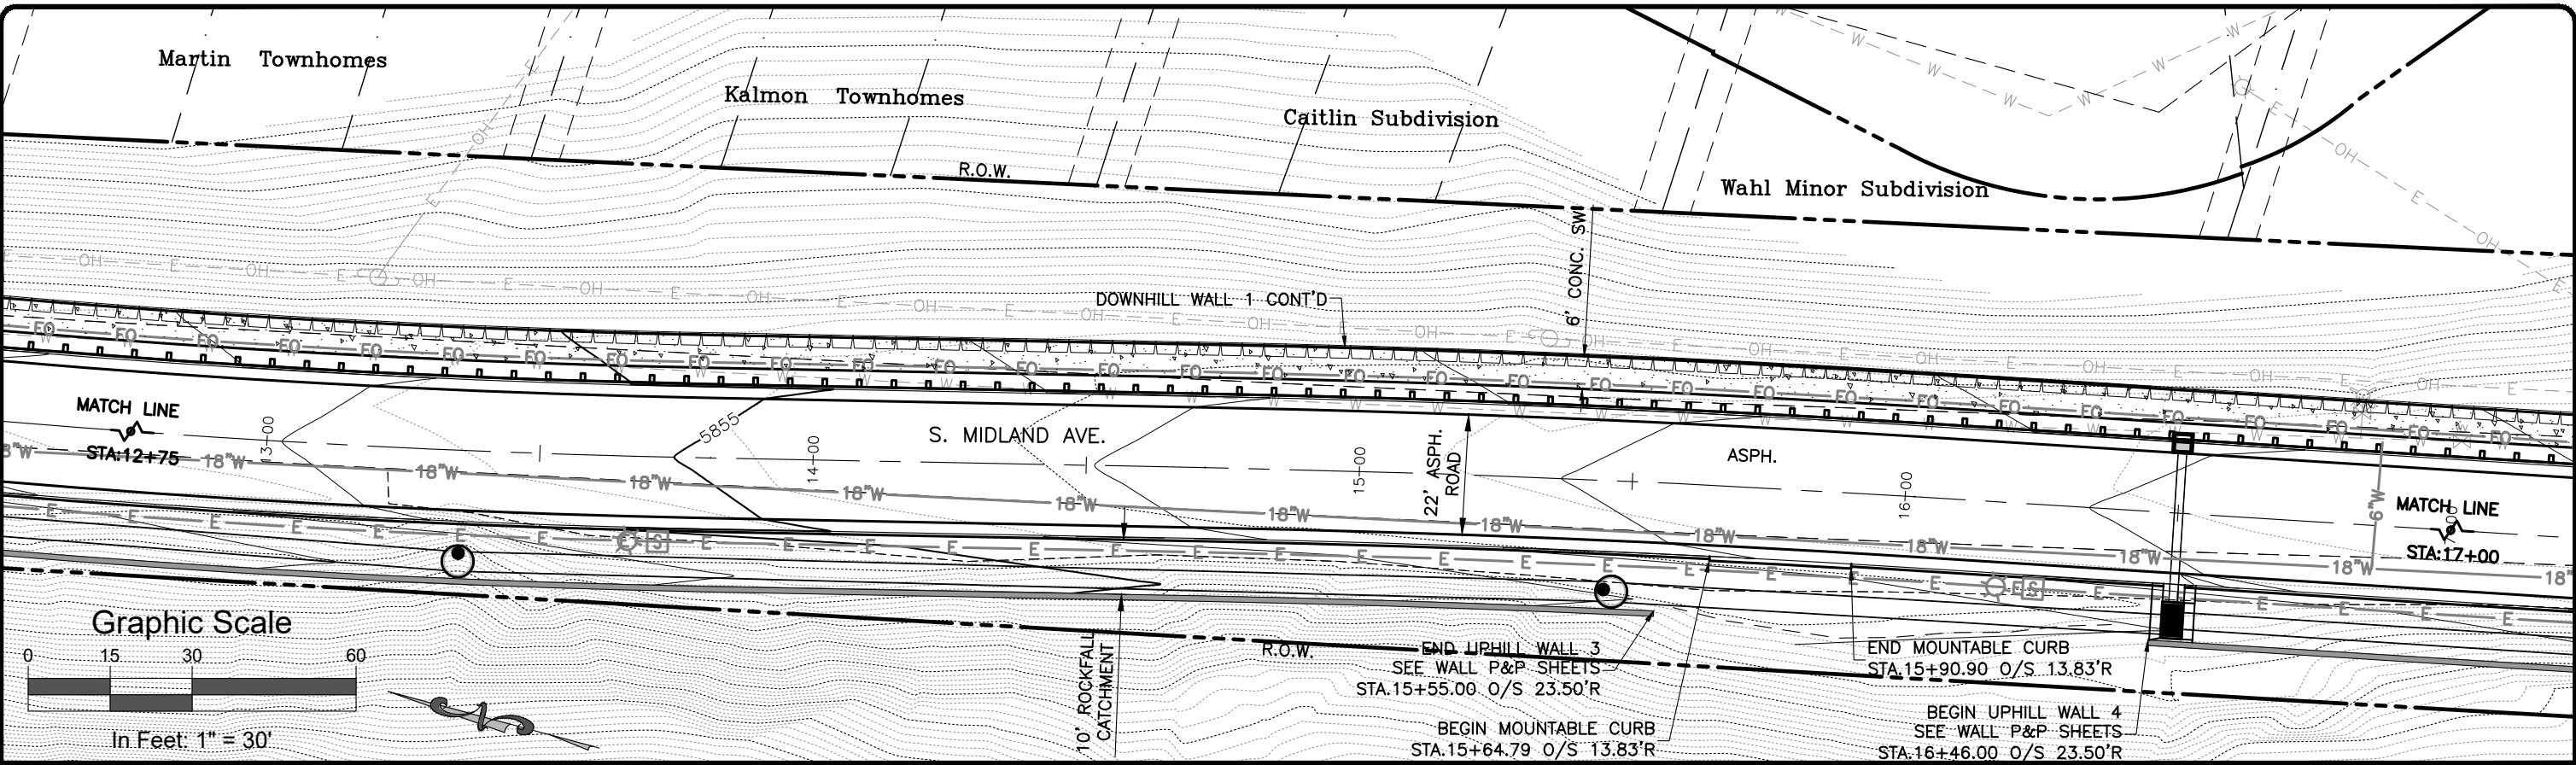

Computer File Information		Sheet Revisions					 118 West Sixth Street, Suite 200 Glenwood Springs, CO 81601 970.945.1004 www.sgm-inc.com	As Constructed		South Midland Ave. Improvements Plan & Profile 12+75 - 17+00			Project No./Code	
Print Date: 7/15/20		Rev.	Date	Comments	Init.			No Revisions: -		Engineer: MDF Structure --- Drawn By: AMC Numbers --- Sheet Subset: RDWY Subset Sheets: 4 of 45			No.: BUILD M535-006	
Last Modification Date: 4/23/2019		1						Revised: -					Code: 22933	
Drawing File Name: SMidland-PP(1)								Void: -		Sheet Number: 48				
Autocad Ver. 2018 Scale: As Shown Units: English														
SGM Project No.: 2017-211.001 Quality Control: RGN														





I:\2017\2017-211-GWSSOMIDLAND\001-MIDLAND4MILERO27THST\H-DWGS\CIVIL\PS-SHEETSET\SMIDLAND-PP(1).DWG Plotted: 7/14/2020 3:18 PM By: Ashley Cline

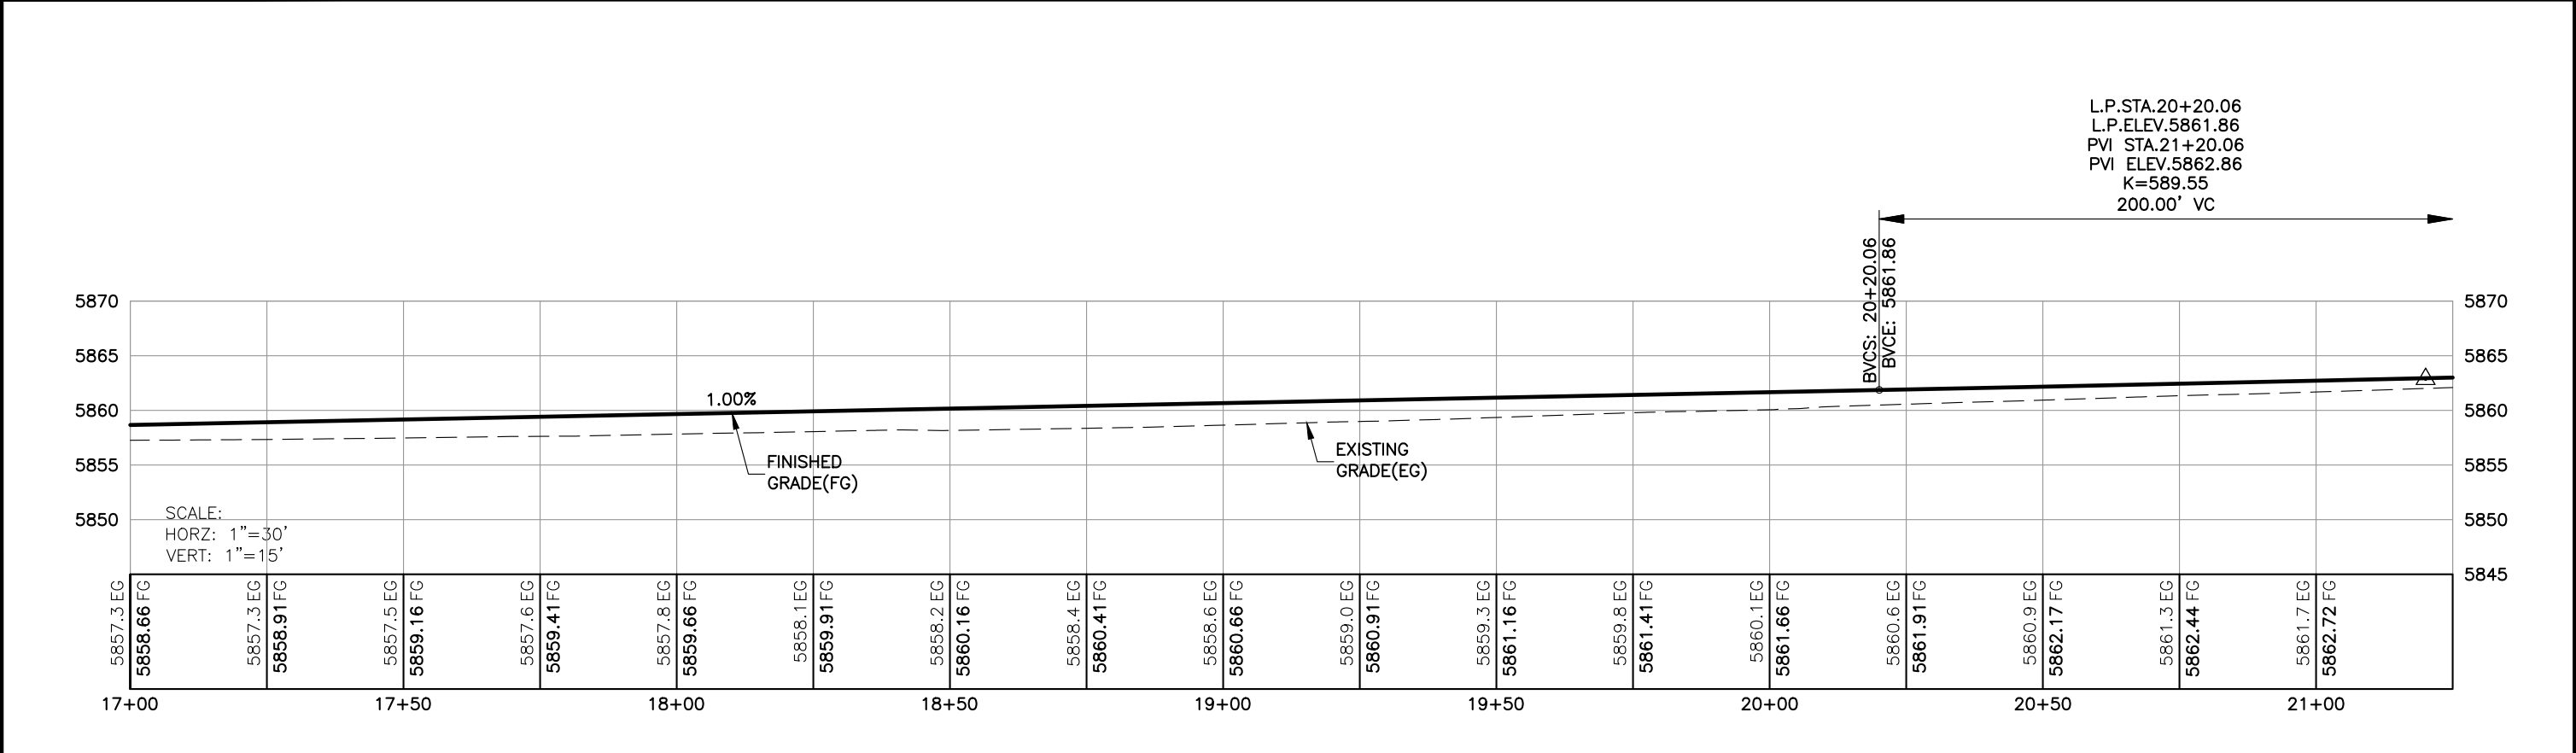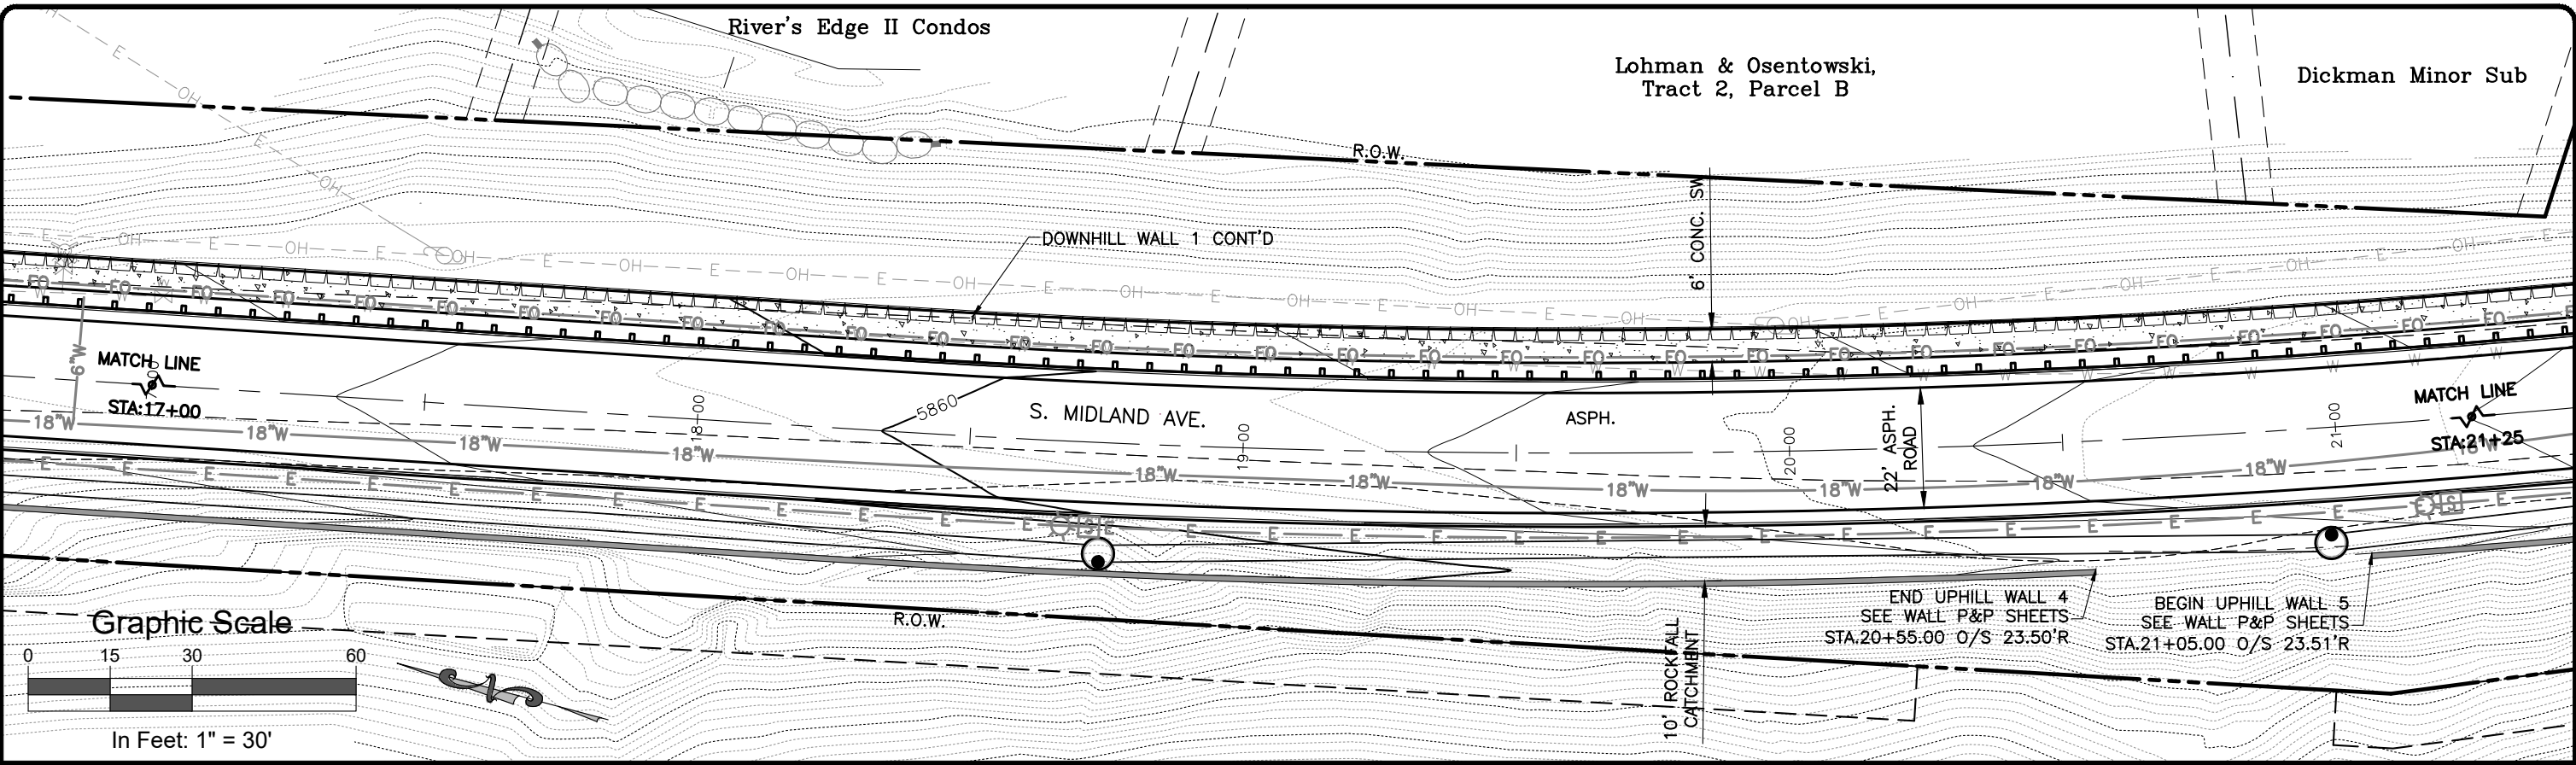

Computer File Information		Sheet Revisions					 118 West Sixth Street, Suite 200 Glenwood Springs, CO 81601 970.945.1004 www.sgm-inc.com	As Constructed		South Midland Ave. Improvements Plan & Profile 17+00 - 21+25				Project No./Code													
Print Date: 7/14/20		Rev.	Date	Comments	Init.			No Revisions: -		<table><tr><td>Engineer:</td><td>MDF</td><td>Structure</td><td>---</td></tr><tr><td>Drawn By:</td><td>AMC</td><td>Numbers</td><td>---</td></tr><tr><td>Sheet Subset:</td><td>RDWY</td><td>Subset Sheets:</td><td>5 of 46</td></tr></table>				Engineer:	MDF	Structure	---	Drawn By:	AMC	Numbers	---	Sheet Subset:	RDWY	Subset Sheets:	5 of 46	No.: BUILD M535-006	
Engineer:	MDF	Structure	---																								
Drawn By:	AMC	Numbers	---																								
Sheet Subset:	RDWY	Subset Sheets:	5 of 46																								
Last Modification Date: 4/23/2019		1				Revised: -		Code: 22933																			
Drawing File Name: SMidland-PP(1)						Void: -		Sheet Number: 49																			
Autocad Ver. 2018 Scale: As Shown Units: English																											
SGM Project No.: 2017-211.001 Quality Control: RGN																											




I:\2017\211-GWSSMIDLAND\001-MIDLAND4MILERO27THST\H-DWGS\CIVIL\PS-SHEETSET\SMIDLAND-PP(1).DWG Plotted: 7/14/2020 3:18 PM By: Ashley Cline

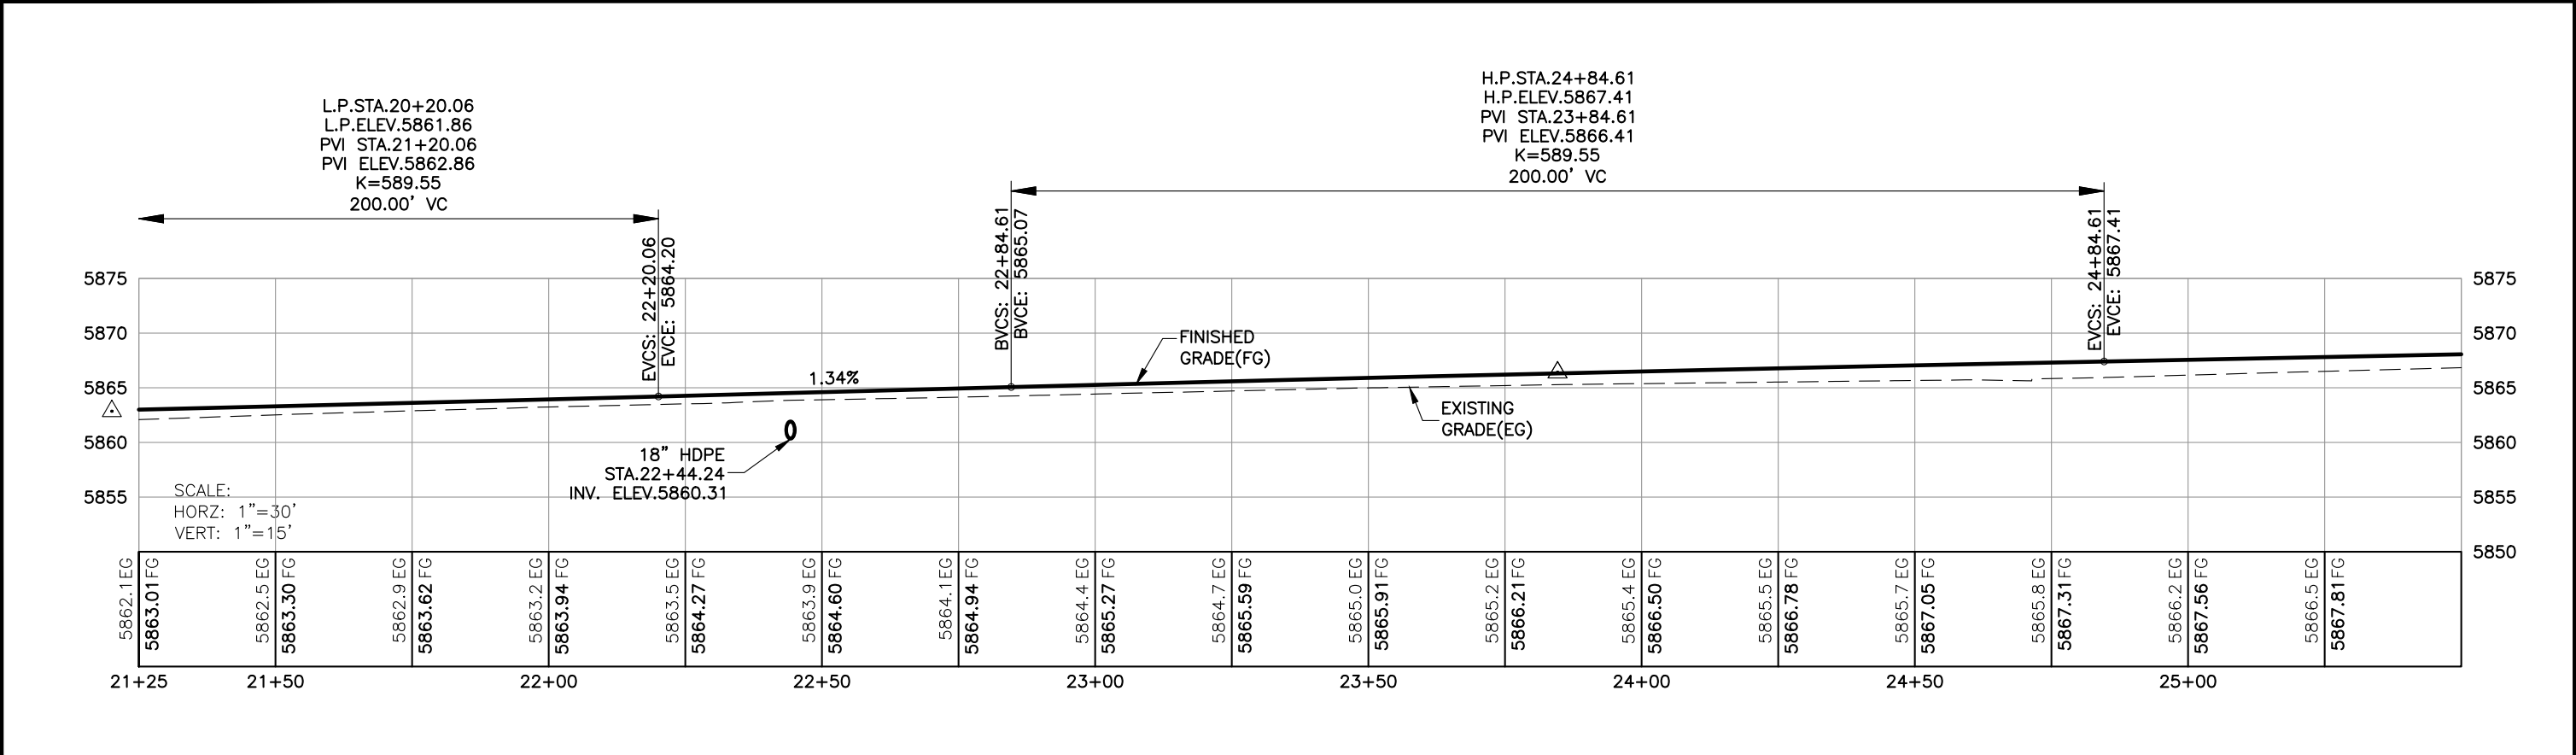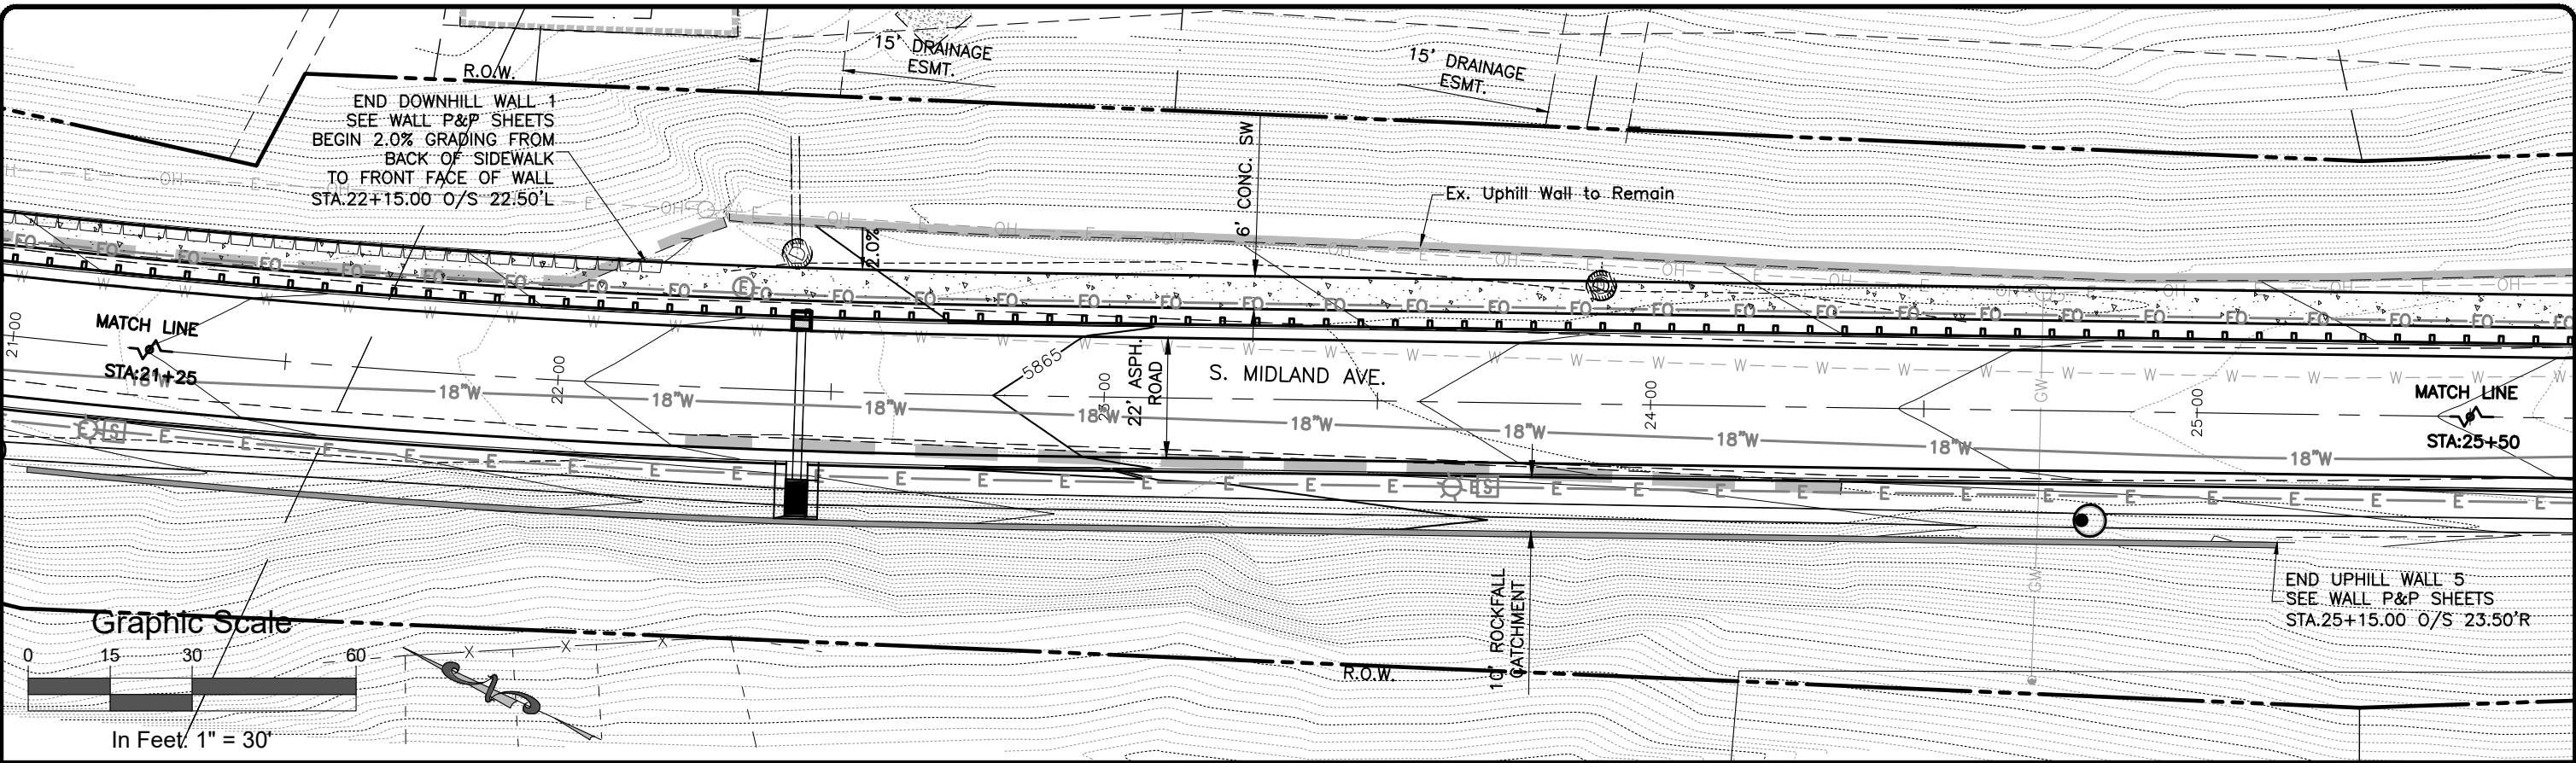

Computer File Information				Sheet Revisions				As Constructed				South Midland Ave. Improvements				Project No./Code	
Print Date: 7/14/20				Rev.	Date	Comments	Init.	No Revisions: -				Plan & Profile 21+25 - 25+50				No.: BUILD M535-006	
Last Modification Date: 4/23/2019				1				Revised: -				Engineer: MDF		Structure	---	Code: 22933	
Drawing File Name: SMidland-PP(1)								Void: -				Drawn By: AMC		Numbers	---	Sheet Number: 50	
Autocad Ver. 2018 Scale: As Shown Units: English												Sheet Subset: RDWY		Subset Sheets:	6 of 45		
SGM Project No.: 2017-211.001 Quality Control: RGN																	



I:\2017\2017-211-GWSSMIDLAND\001-MIDLAND4MILERO27THST\H-DWGS\CIVIL\PS-SHEETSET\SMIDLAND-PP(1).DWG Plotted: 7/14/2020 3:19 PM By: Ashley Cline

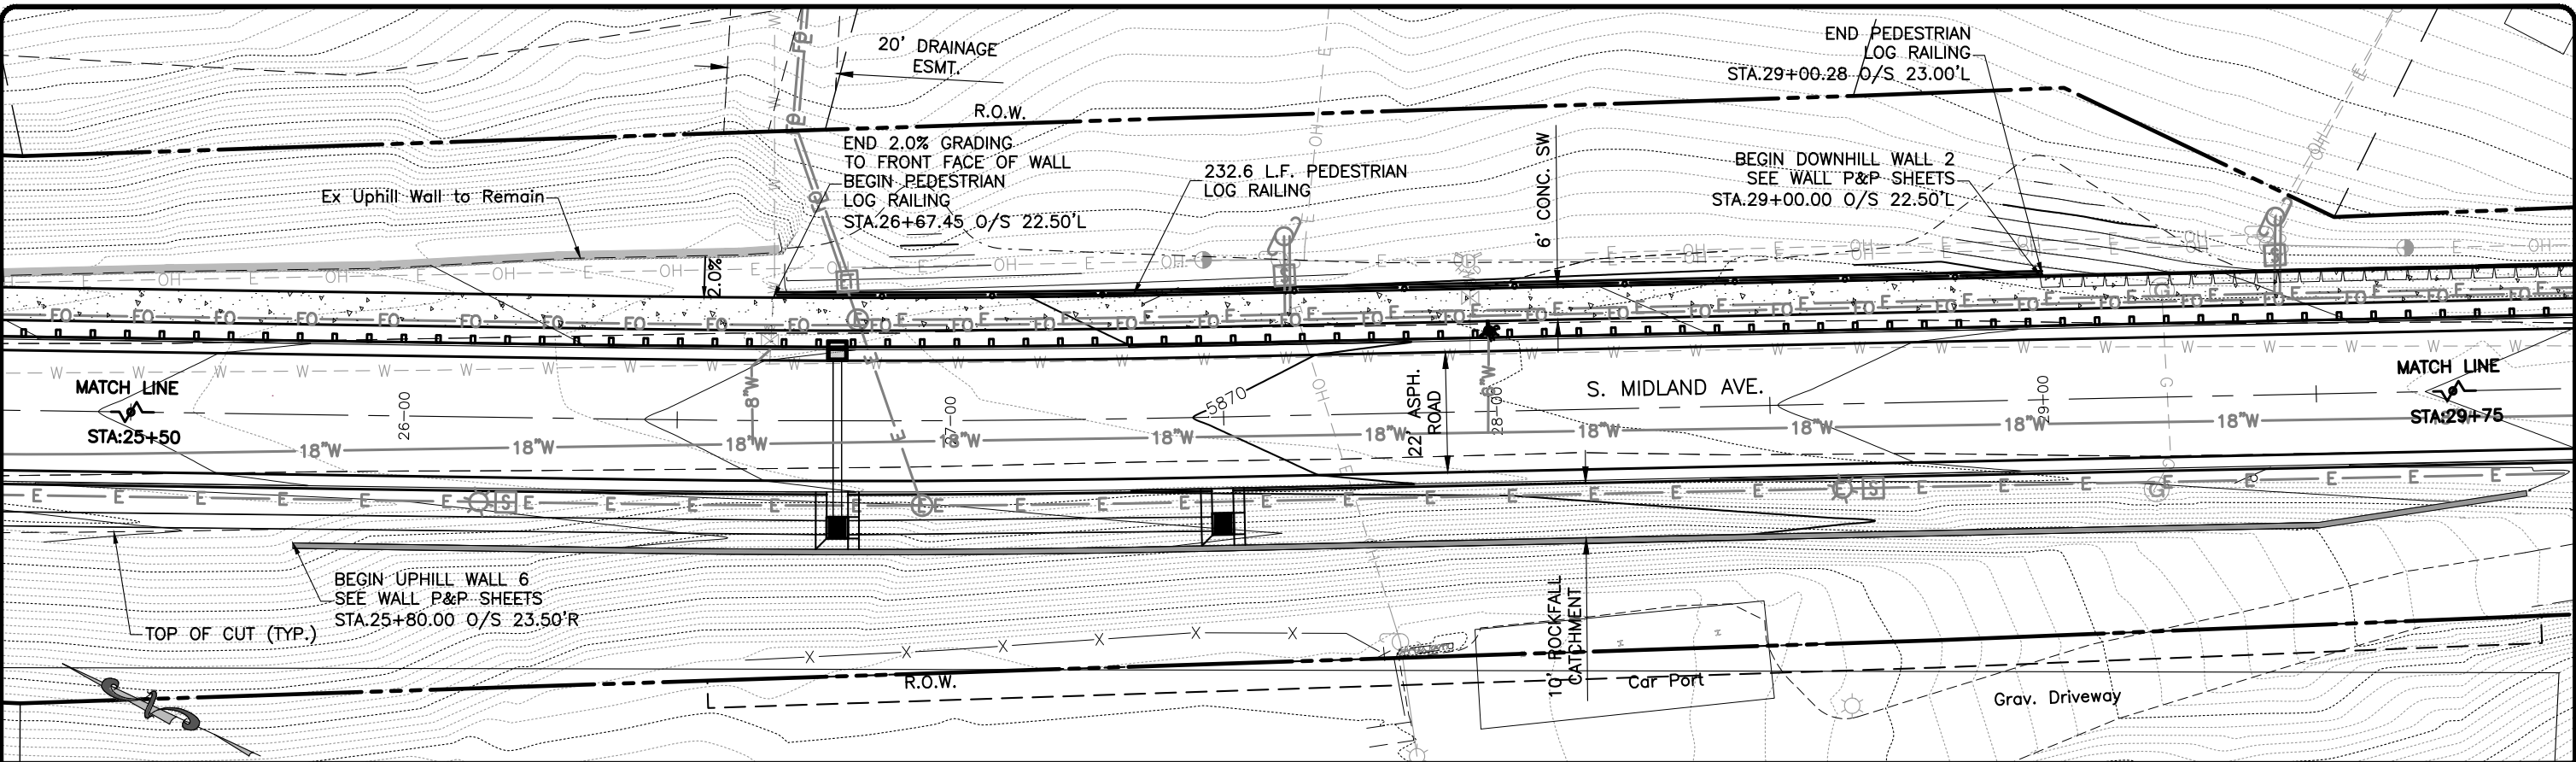


Graphic Scale



In Feet: 1" = 30'



H.P.STA.29+65.72
H.P.ELEV.5871.97
PVI STA.28+40.72
PVI ELEV.5870.97
K=1250.00
250.00' VC

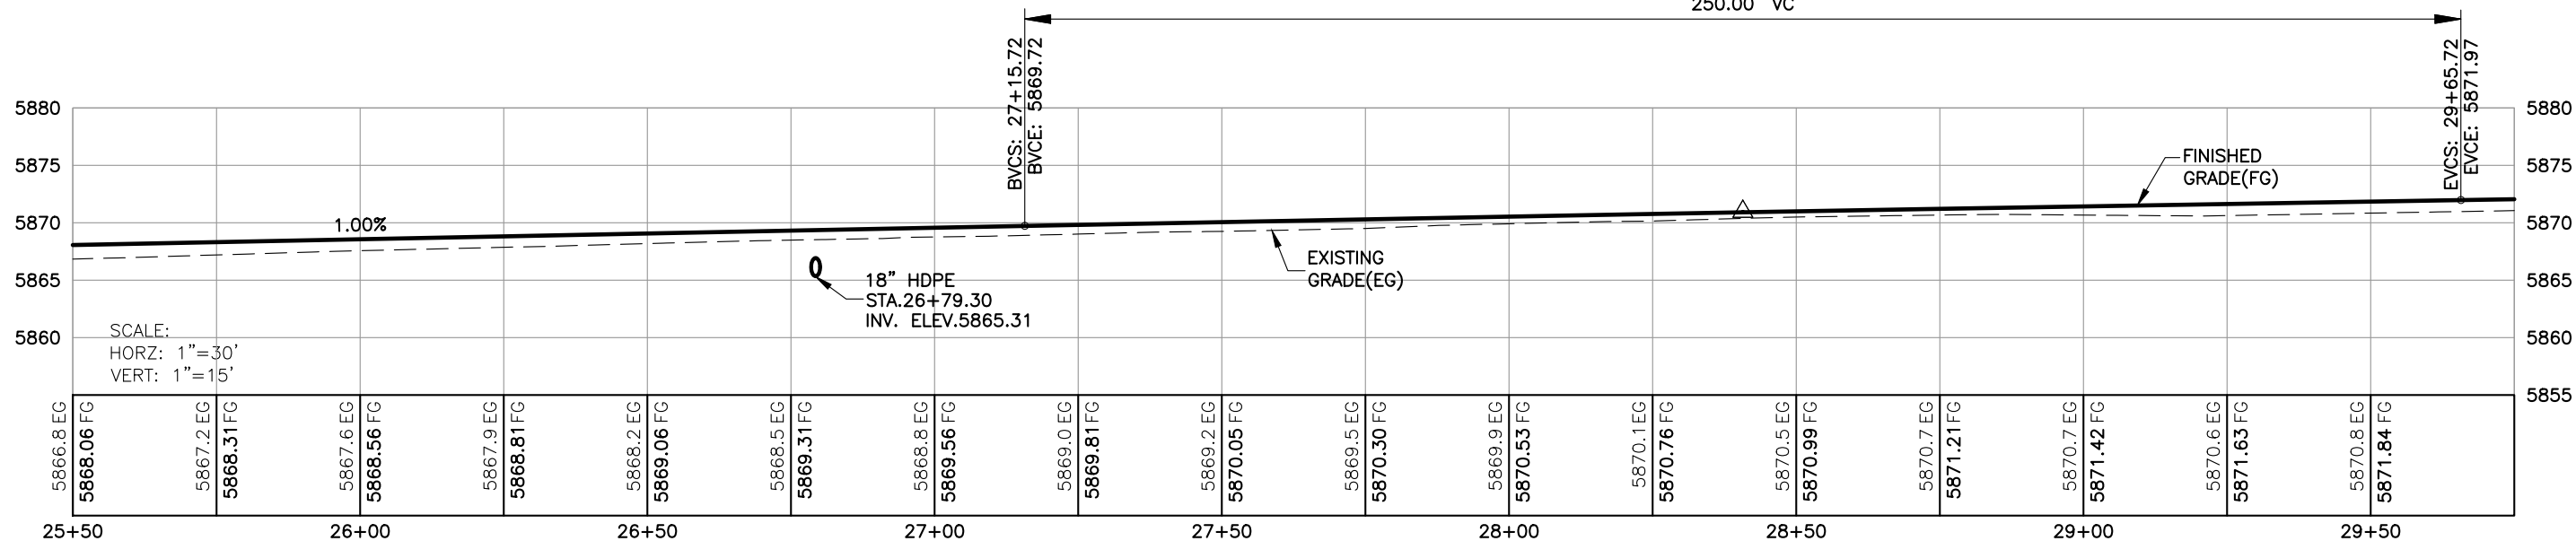

Computer File Information				Sheet Revisions				As Constructed				South Midland Ave. Improvements Plan & Profile 25+50 - 29+75				Project No./Code	
Print Date: 7/14/20				Rev.	Date	Comments	Init.	No Revisions: -				Engineer: MDF				No.: BUILD M535-006	
Last Modification Date: 4/23/2019				1				Revised: -				Structure: ---				Code: 22933	
Drawing File Name: SMidland-PP(1)								Void: -				Drawn By: AMC				Sheet Number: 51	
Autocad Ver. 2018 Scale: As Shown Units: English												Sheet Subset: RDWY					
SGM Project No.: 2017-211.001 Quality Control: RGN												Subset Sheets: 7 of 45					





I:\2017\2017-211-GWSSMIDLAND\001-MIDLAND4MILERO27THST\H-DWGS\CIVIL\PS-SHEETSET\SMIDLAND-PP(2).DWG Plotted: 7/14/2020 3:20 PM By: Ashley Cline

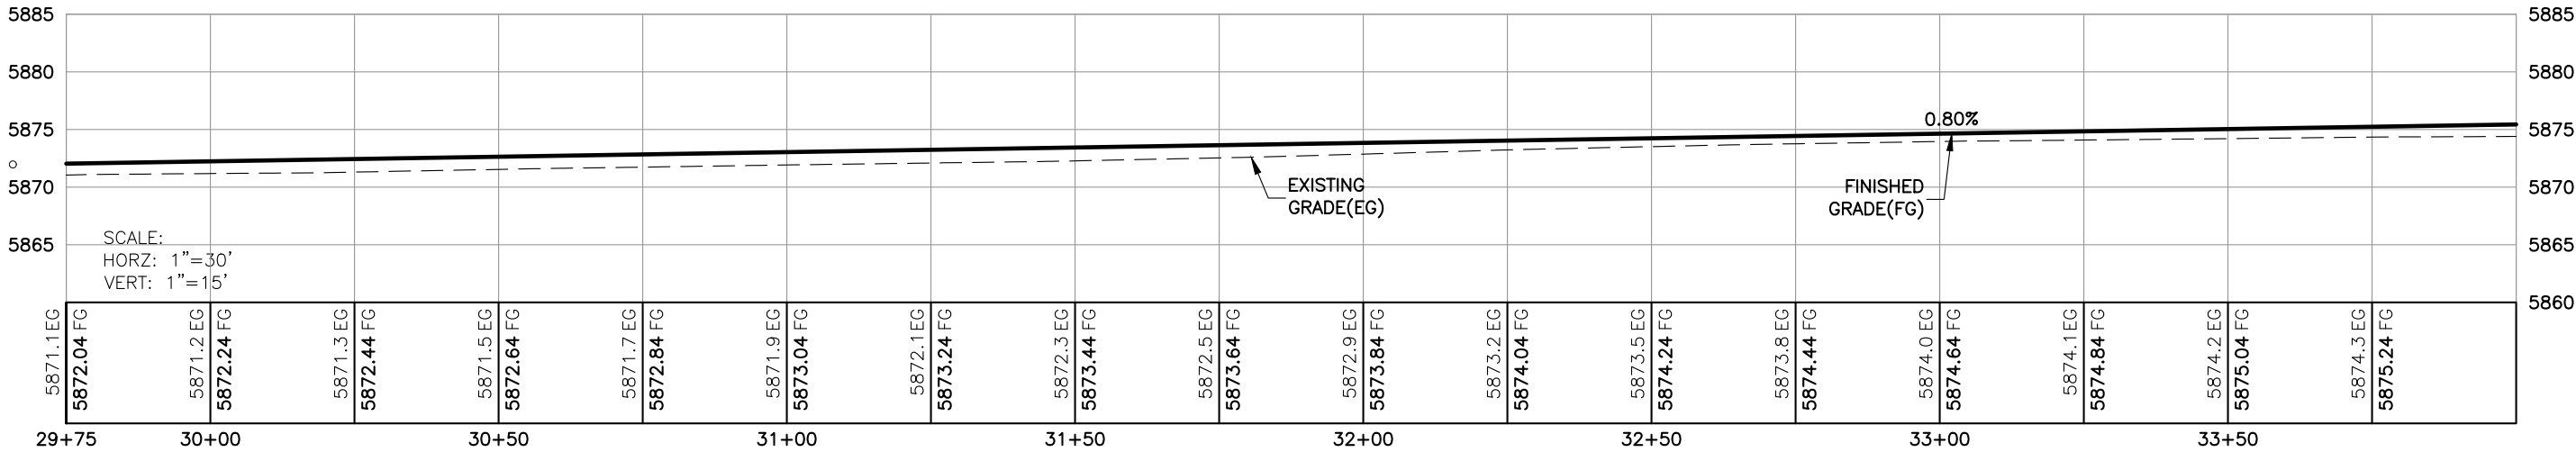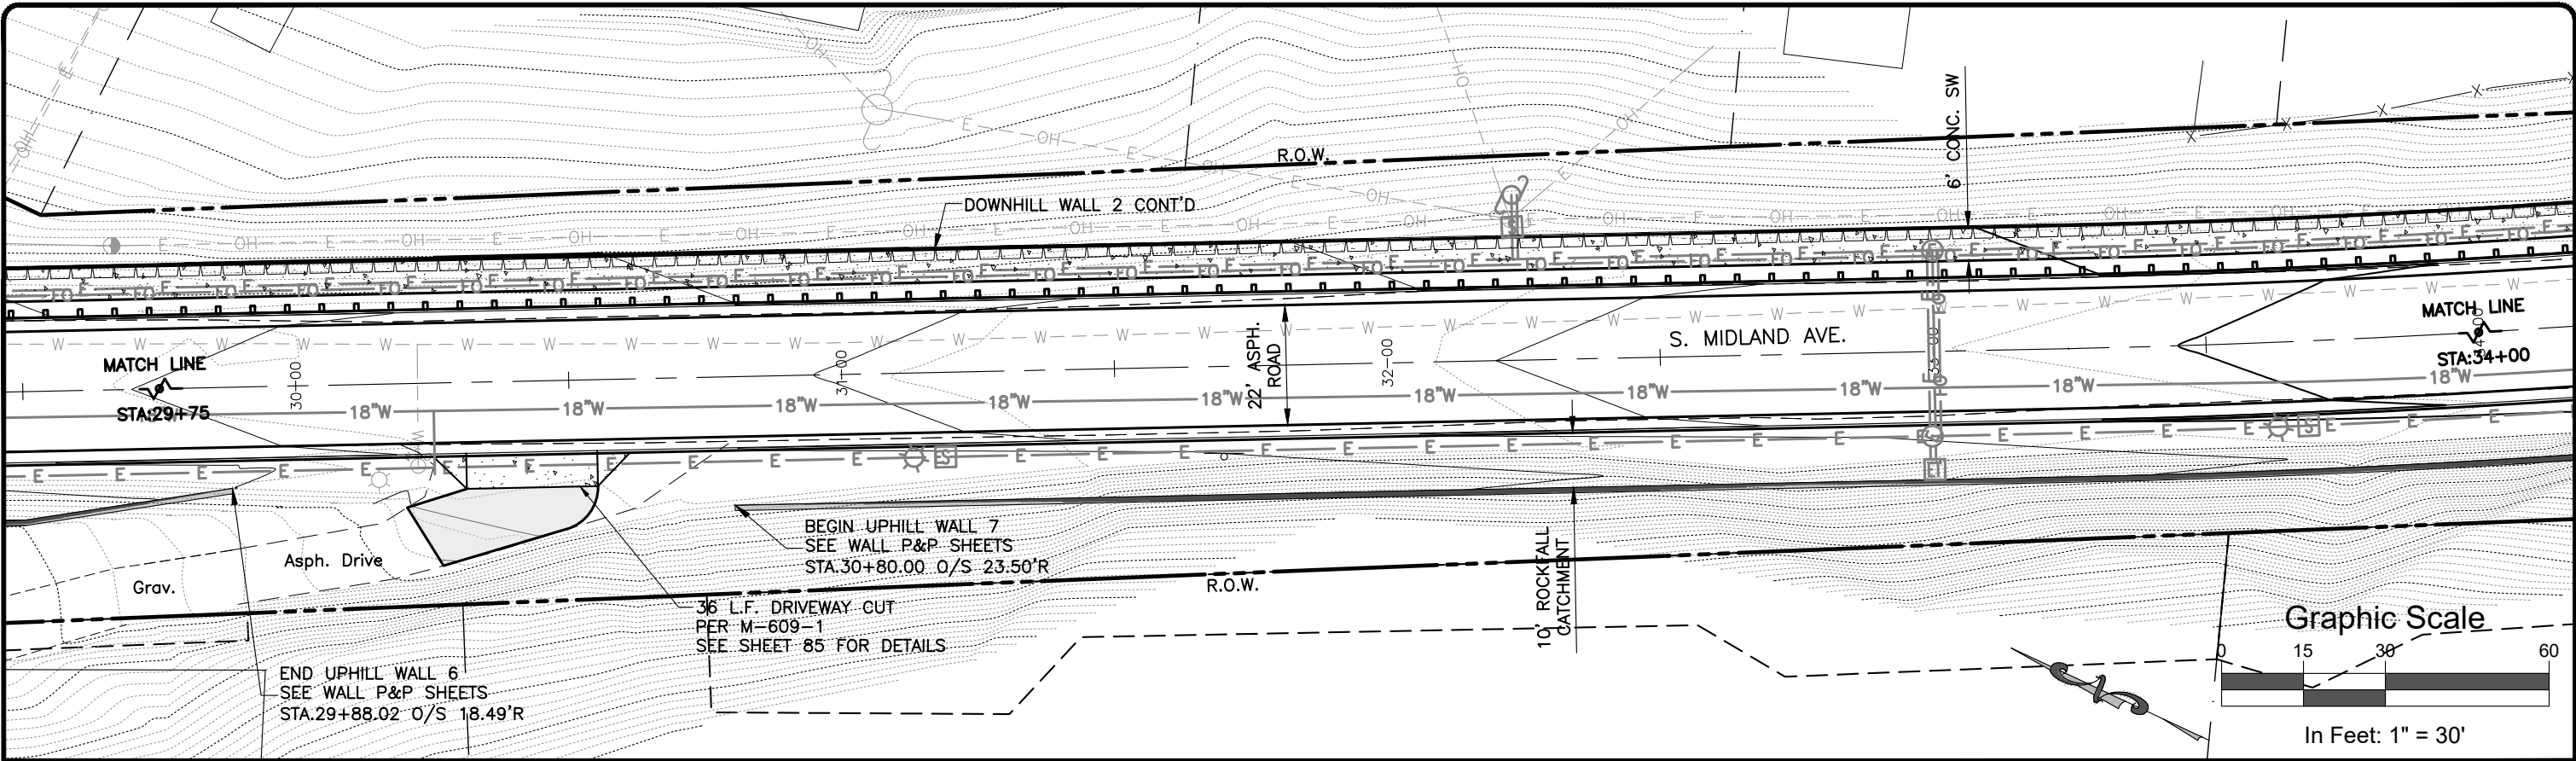

Computer File Information				Sheet Revisions				As Constructed				South Midland Ave. Improvements Plan & Profile 29+75 - 34+00				Project No./Code	
Print Date:	7/14/20	Last Modification Date:	4/23/2019	Rev.	Date	Comments	Init.	No Revisions:	-	Engineer:	MDF	Structure	---	No.:	BUILD M535-006		
Drawing File Name:	SMidland-PP(2)	Autocad Ver.	2018	Scale:	As Shown	Units:	English	Revised:	-	Drawn By:	AMC	Numbers	---	Code:	22933		
SGM Project No.:	2017-211.001	Quality Control:	RGH					Void:	-	Sheet Subset:	RDWY	Subset Sheets:	8 of 45	Sheet Number:	52		




I:\2017\2017-211-GWSSMIDLAND\001-MIDLAND4MILERO27THST\H-DWGS\CIVIL\PS-SHEETSET\SMIDLAND-PP(2).DWG Plotted: 7/14/2020 3:21 PM By: Ashley Cline

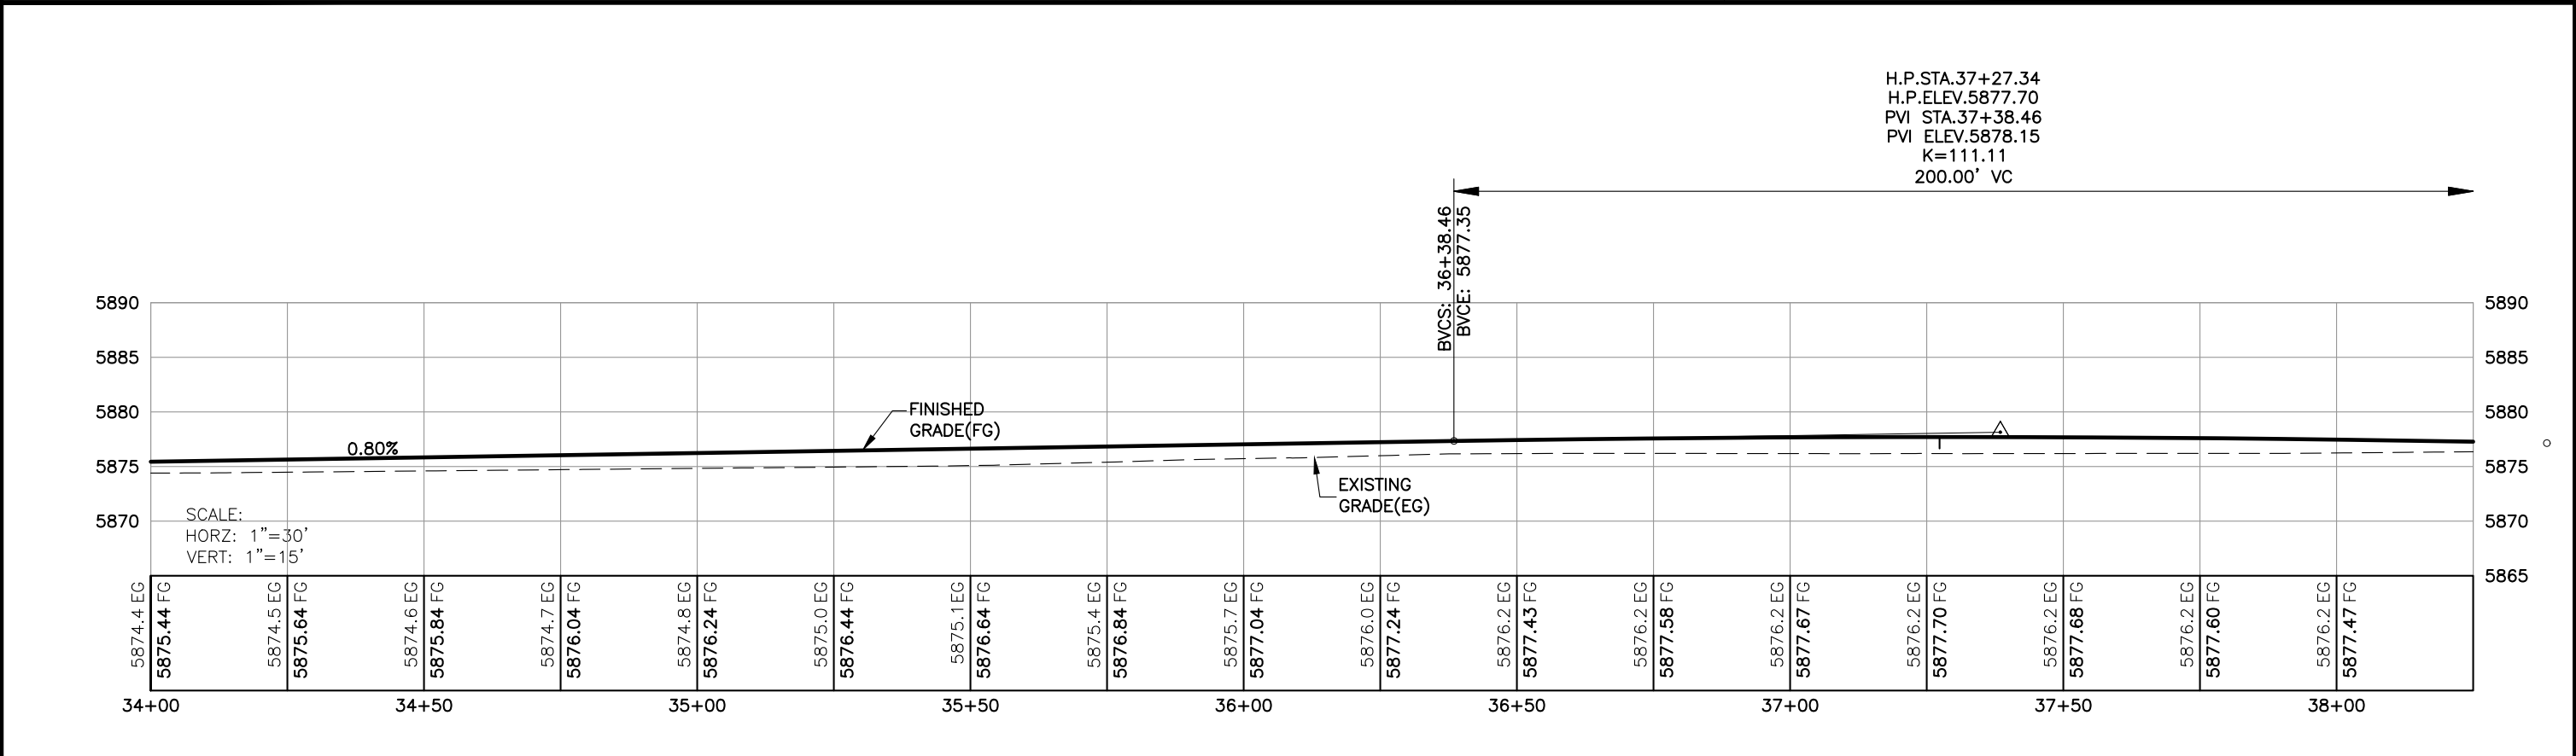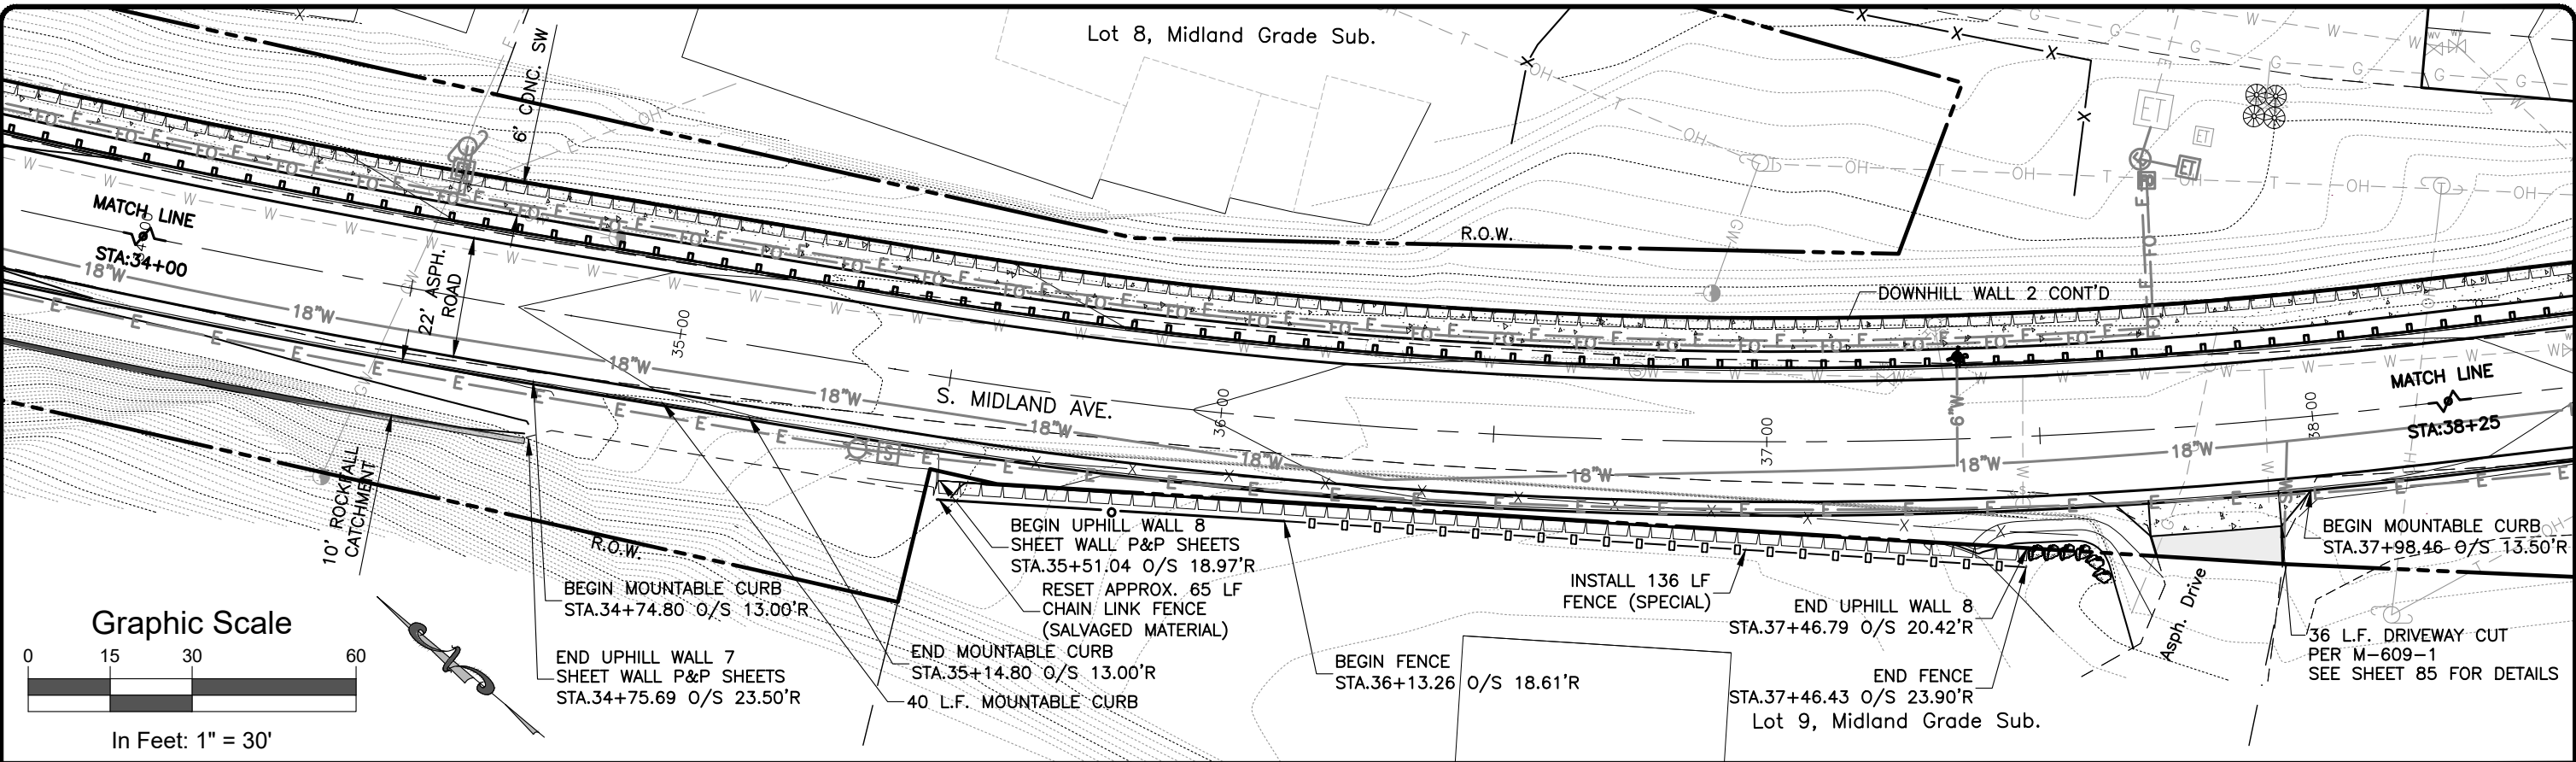


Computer File Information				Sheet Revisions				As Constructed				South Midland Ave. Improvements				Project No./Code	
Print Date: 7/14/20				Rev.	Date	Comments	Init.	No Revisions: -				Plan & Profile 34+00 - 38+25				No.: BUILD M535-006	
Last Modification Date: 4/23/2019				1				Revised: -				Engineer: MDF		Structure	---	Code: 22933	
Drawing File Name: SMidland-PP(2)								Void: -				Drawn By: AMC		Numbers	---	Sheet Number: 53	
Autocad Ver. 2018 Scale: As Shown Units: English												Sheet Subset: RDWY		Subset Sheets:	9 of 45		
SGM Project No.: 2017-211.001 Quality Control: RGN																	



I:\2017\2017-211-GWSSMIDLAND\001-MIDLAND4MILERO27THST\H-DWGS\CIVIL\PS-SHEETSET\SMIDLAND-PP(2).DWG Plotted: 7/14/2020 3:21 PM By: Ashley Cline

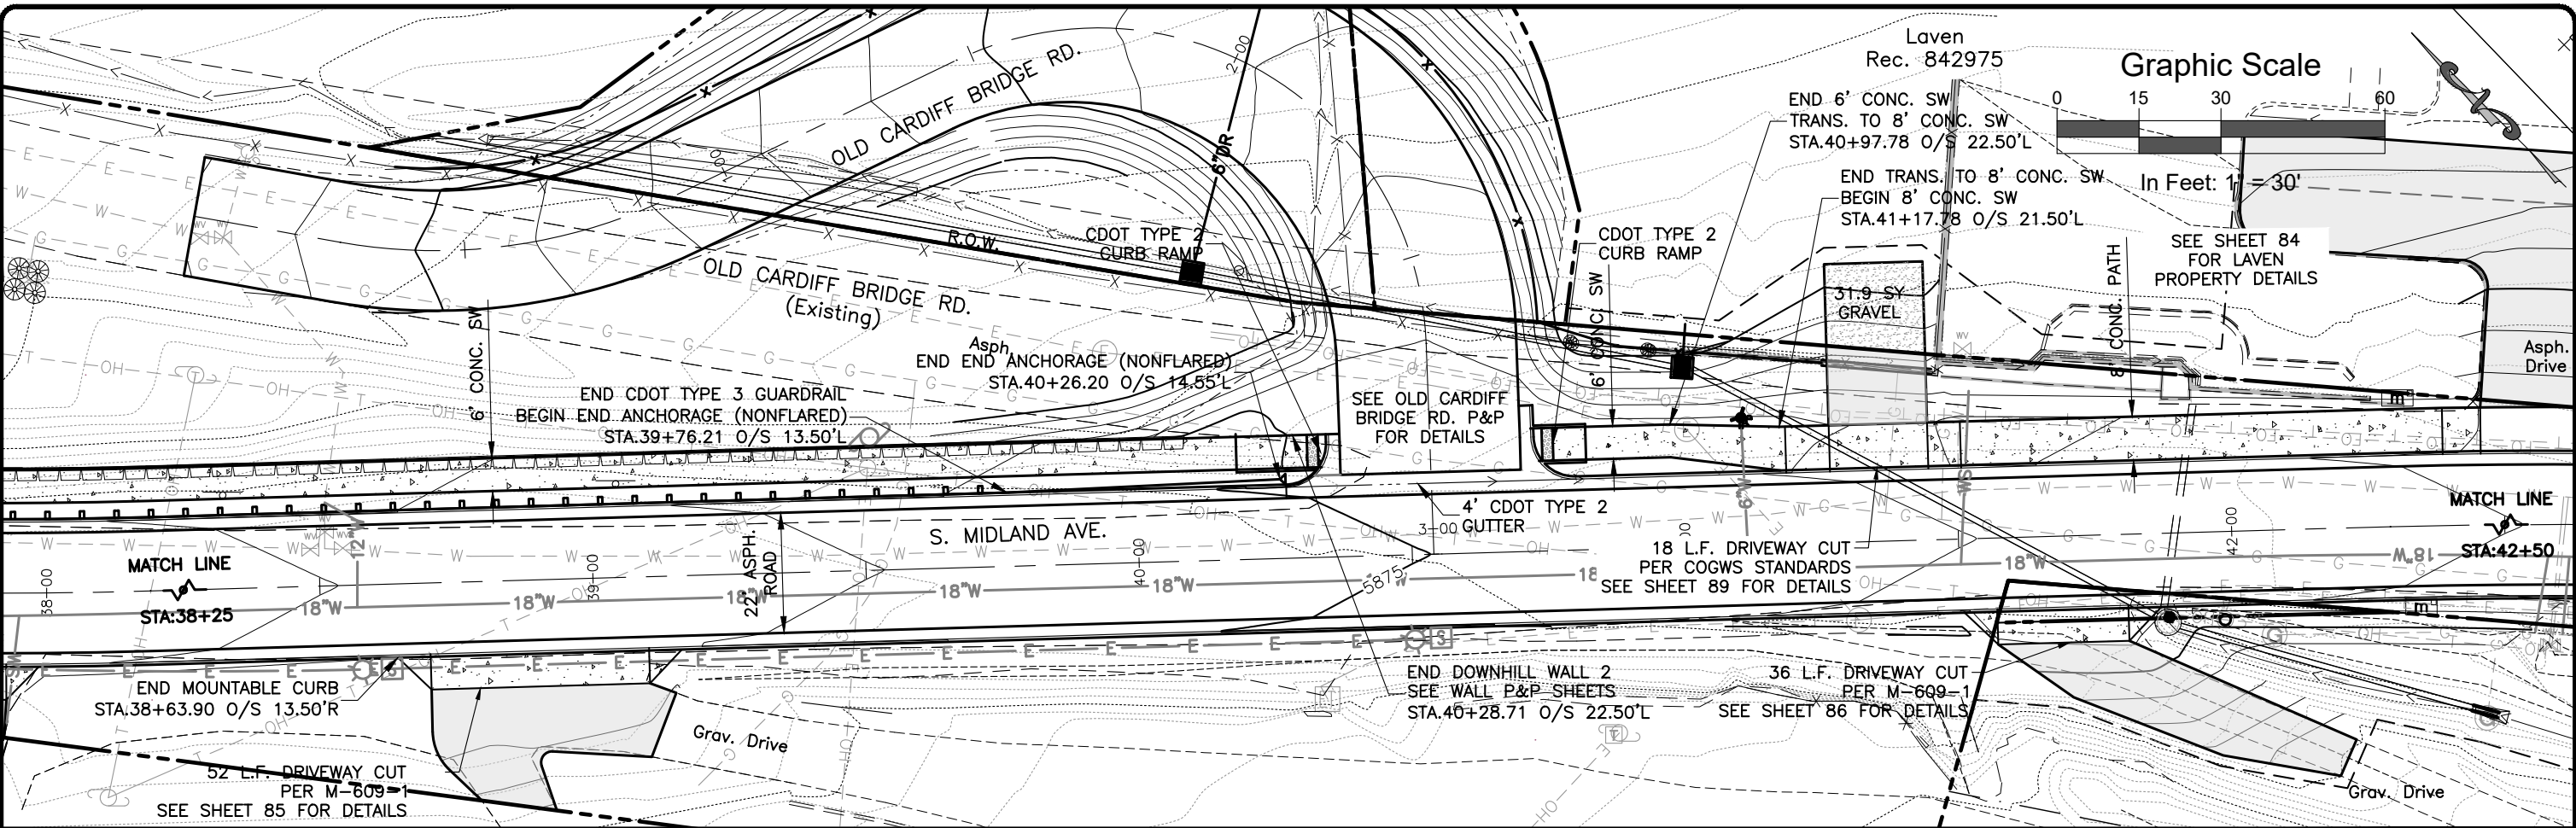



H.P. STA. 37+27.34
H.P. ELEV. 5877.70
PVI STA. 37+38.46
PVI ELEV. 5878.15
K=111.11
200.00' VC
EVCS: 38+38.46
EVCE: 5877.15

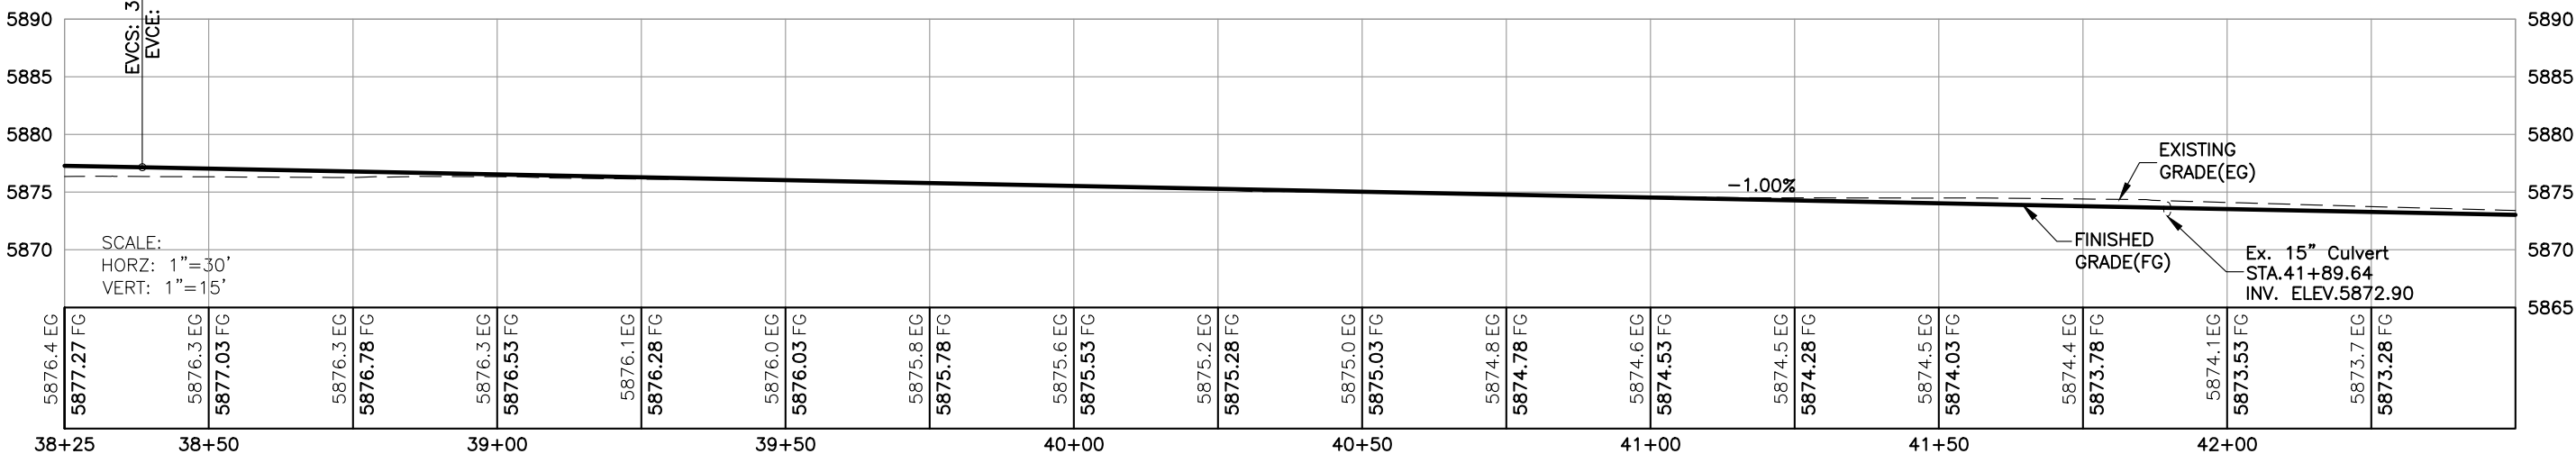

Computer File Information		Sheet Revisions				 SGM 118 West Sixth Street, Suite 200 Glenwood Springs, CO 81601 970.945.1004 www.sgm-inc.com	As Constructed		South Midland Ave. Improvements Plan & Profile 38+25 - 42+50				Project No./Code	
Print Date: 7/14/20		Rev.	Date	Comments	Init.		No Revisions:	-					No.: BUILD M535-006	
Last Modification Date: 4/23/2019		1												
Drawing File Name: SMidland-PP(2)														
Autocad Ver. 2018 Scale: As Shown Units: English														
SGM Project No.: 2017-211.001 Quality Control: RGN														
									Engineer:	MDF	Structure	---	Code: 22933	
									Drawn By:	AMC	Numbers	---	Sheet Number: 54	
									Sheet Subset:	RDWY	Subset Sheets:	10 of 45		





I:\2017\2017-211-GWSSMIDLAND\001-MIDLAND4MILERO27THST\H-DWGS\CIVIL\PS-SHEETSET\SMIDLAND-PP(2).DWG Plotted: 7/14/2020 3:22 PM By: Ashley Cline

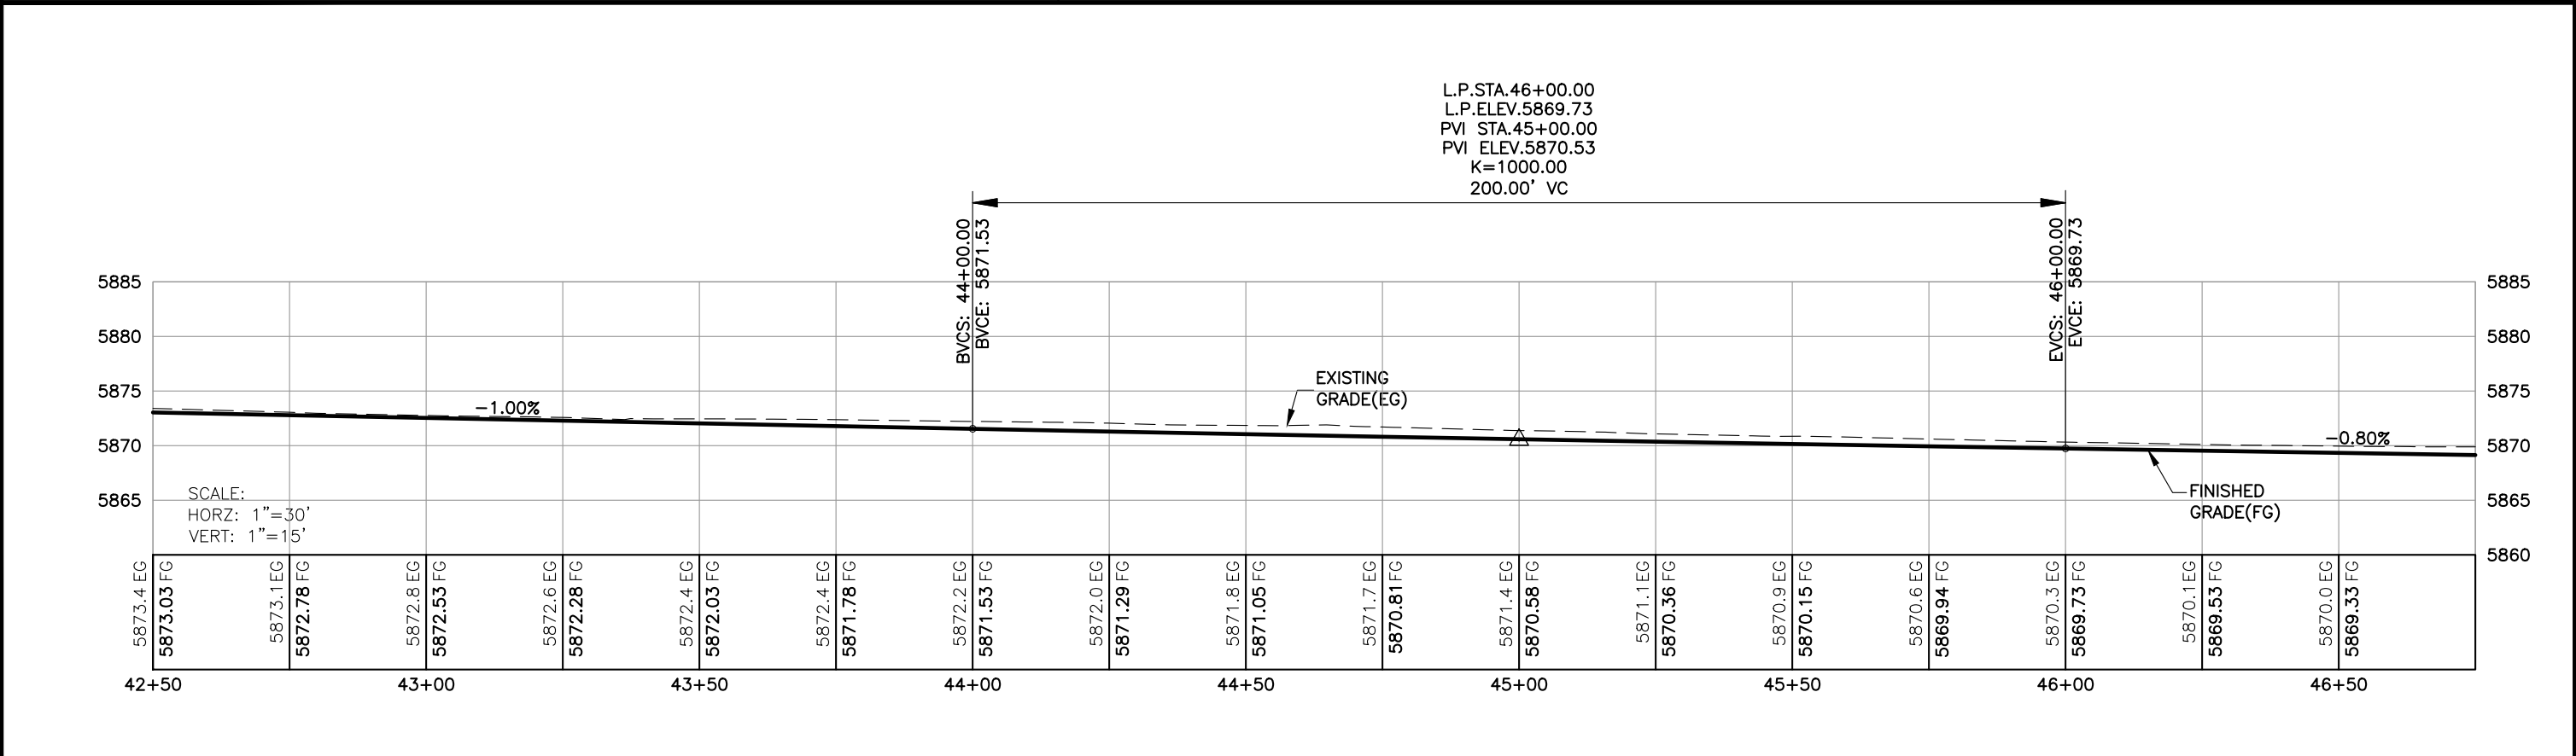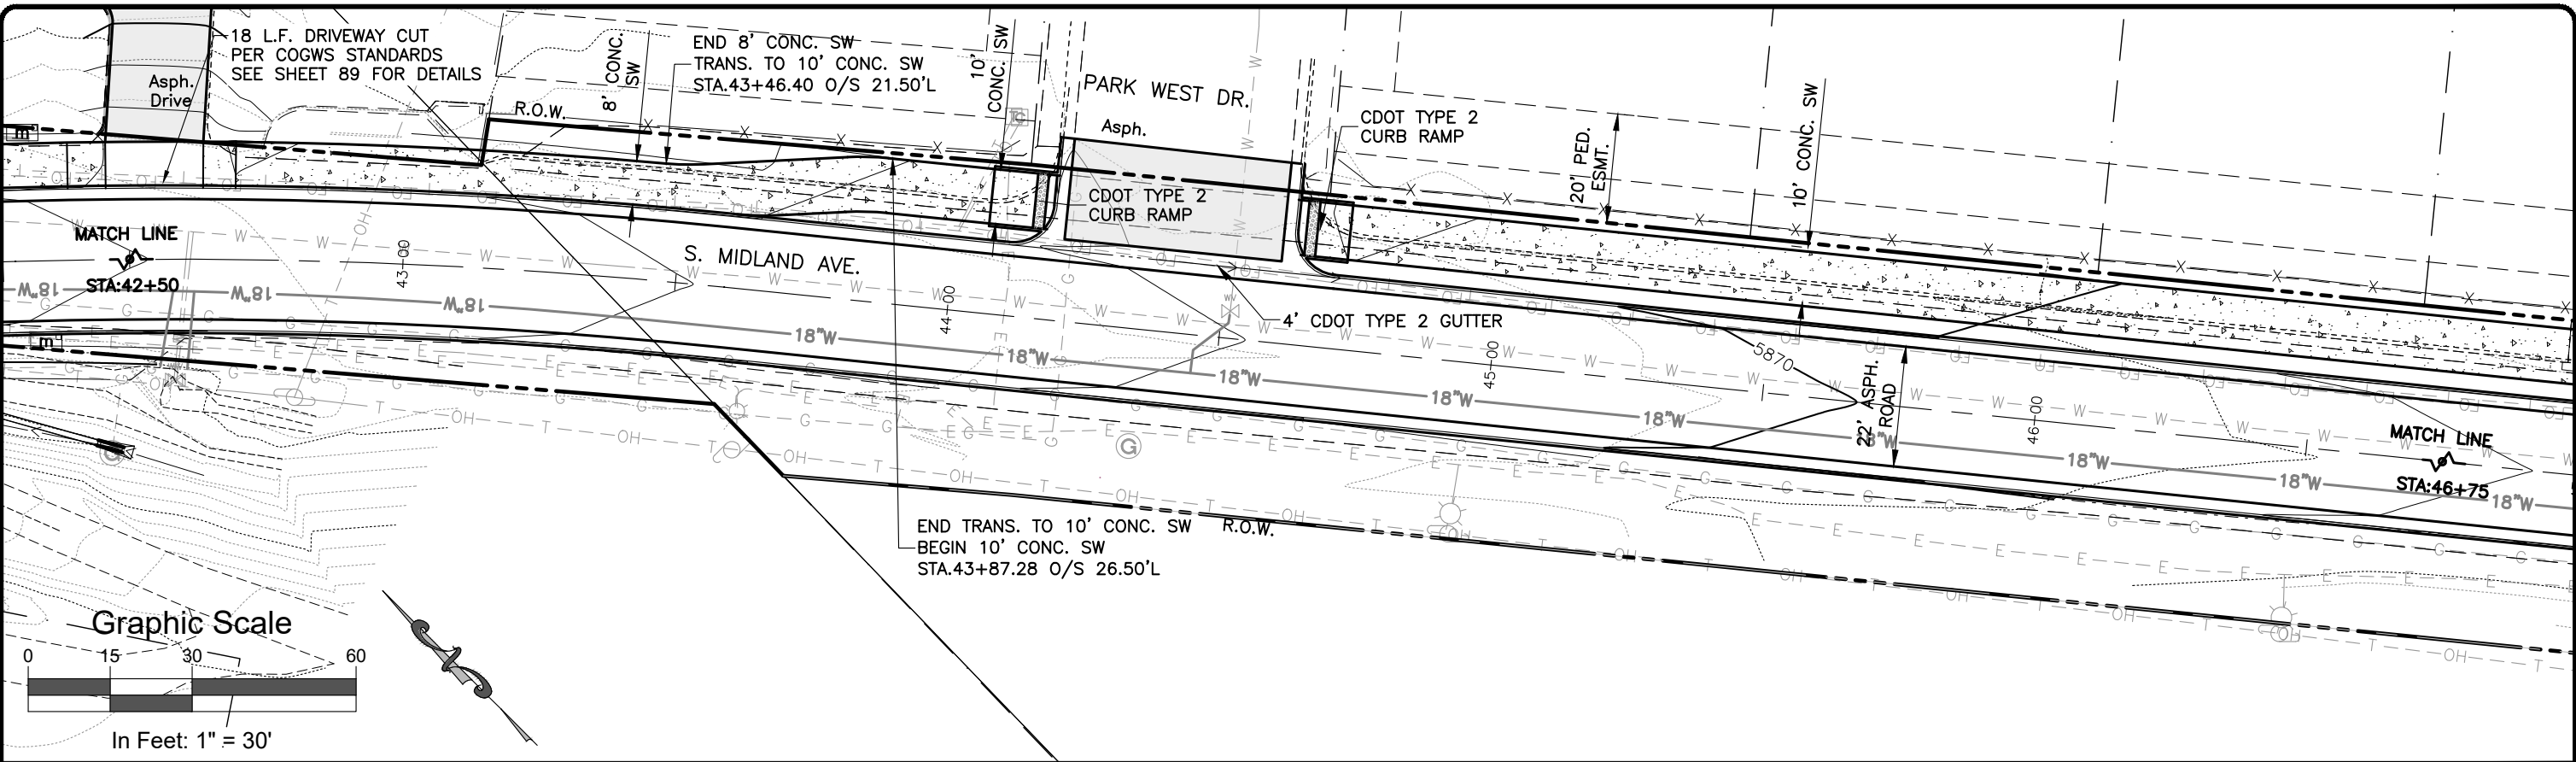

Computer File Information				Sheet Revisions				As Constructed				South Midland Ave. Improvements				Project No./Code	
Print Date: 7/14/20				Rev.	Date	Comments	Init.	No Revisions: -				Plan & Profile 42+50 - 46+75				No.: BUILD M535-006	
Last Modification Date: 4/23/2019				1				Revised: -				Engineer: MDF				Code: 22933	
Drawing File Name: SMidland-PP(2)								Void: -				Drawn By: AMC				Sheet Number: 55	
Autocad Ver. 2018 Scale: As Shown Units: English												Sheet Subset: RDWY					
SGM Project No.: 2017-211.001 Quality Control: RGN												Subset Sheets: 11 of 45					





I:\2017\2017-211-GWSSOMIDLAND\001-MIDLAND4MILRD27THST\H-DWGS\CIVIL\PS-SHEETSET\SMIDLAND-PP(2).DWG Plotted: 7/14/2020 3:22 PM By: Ashley Cline

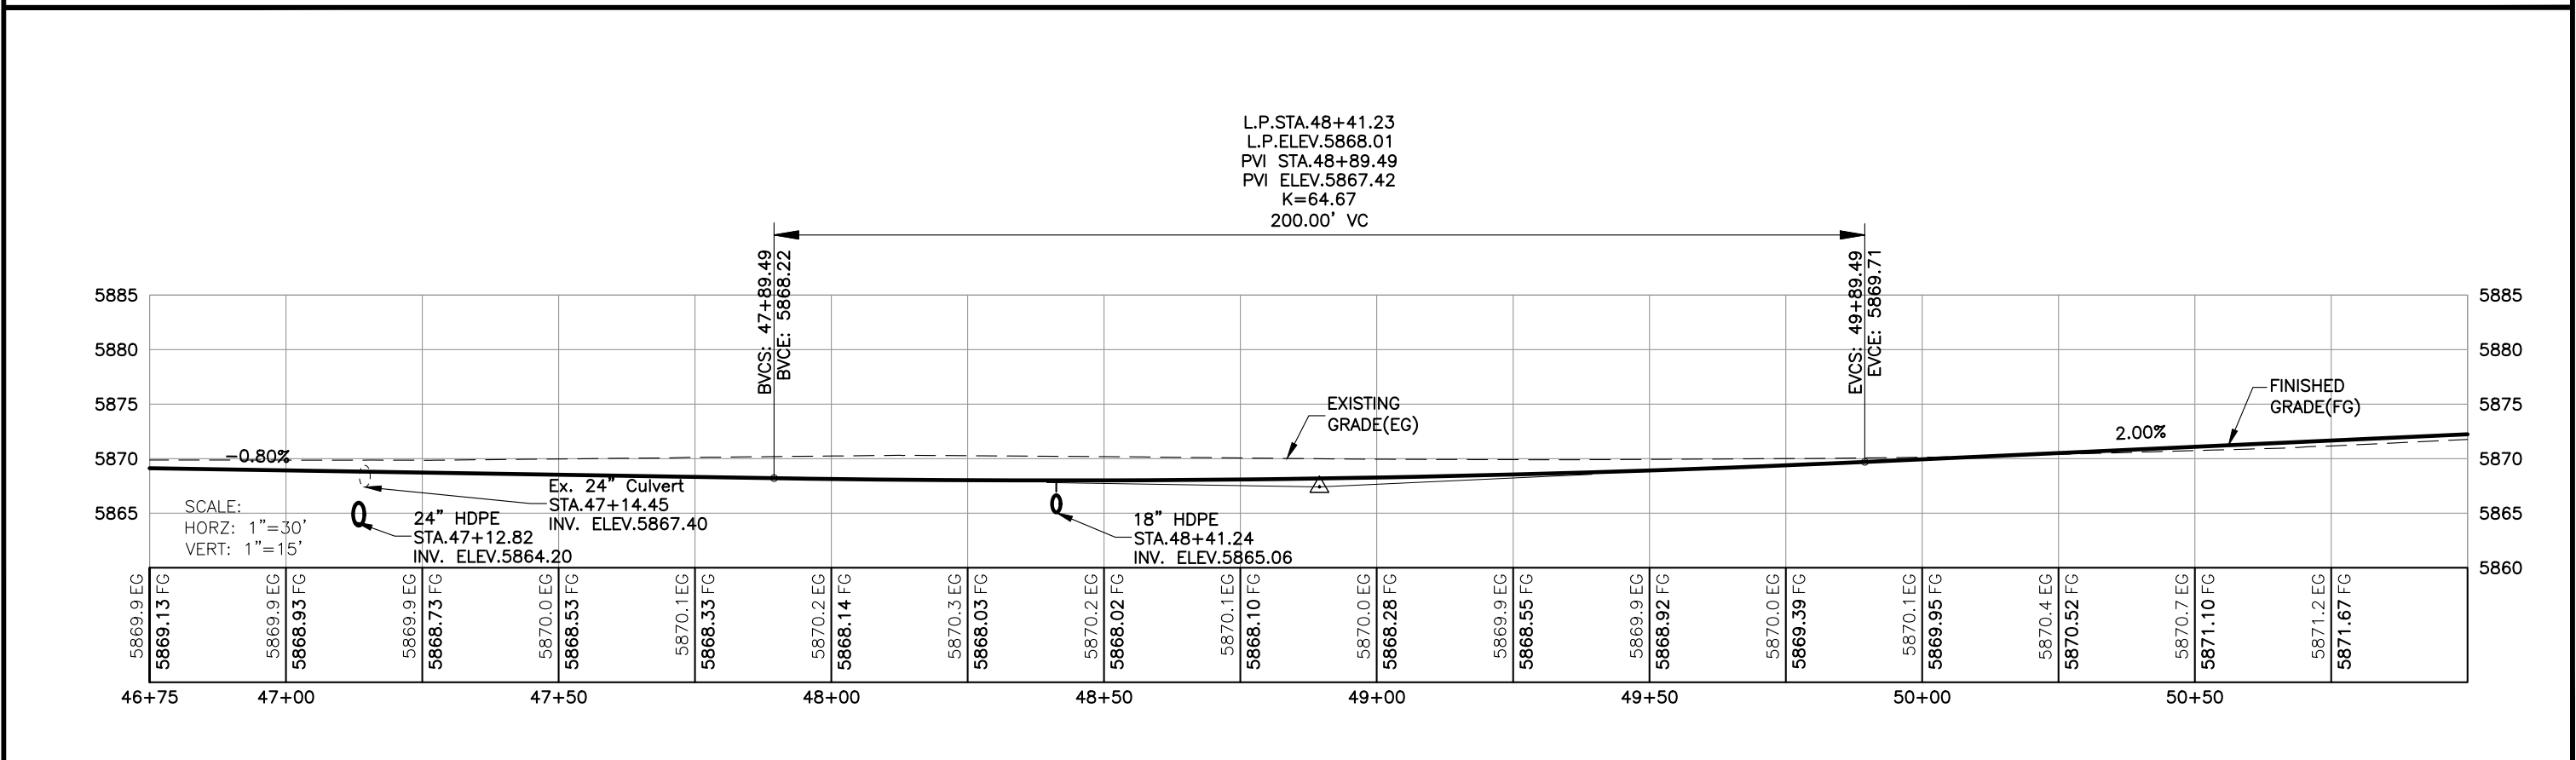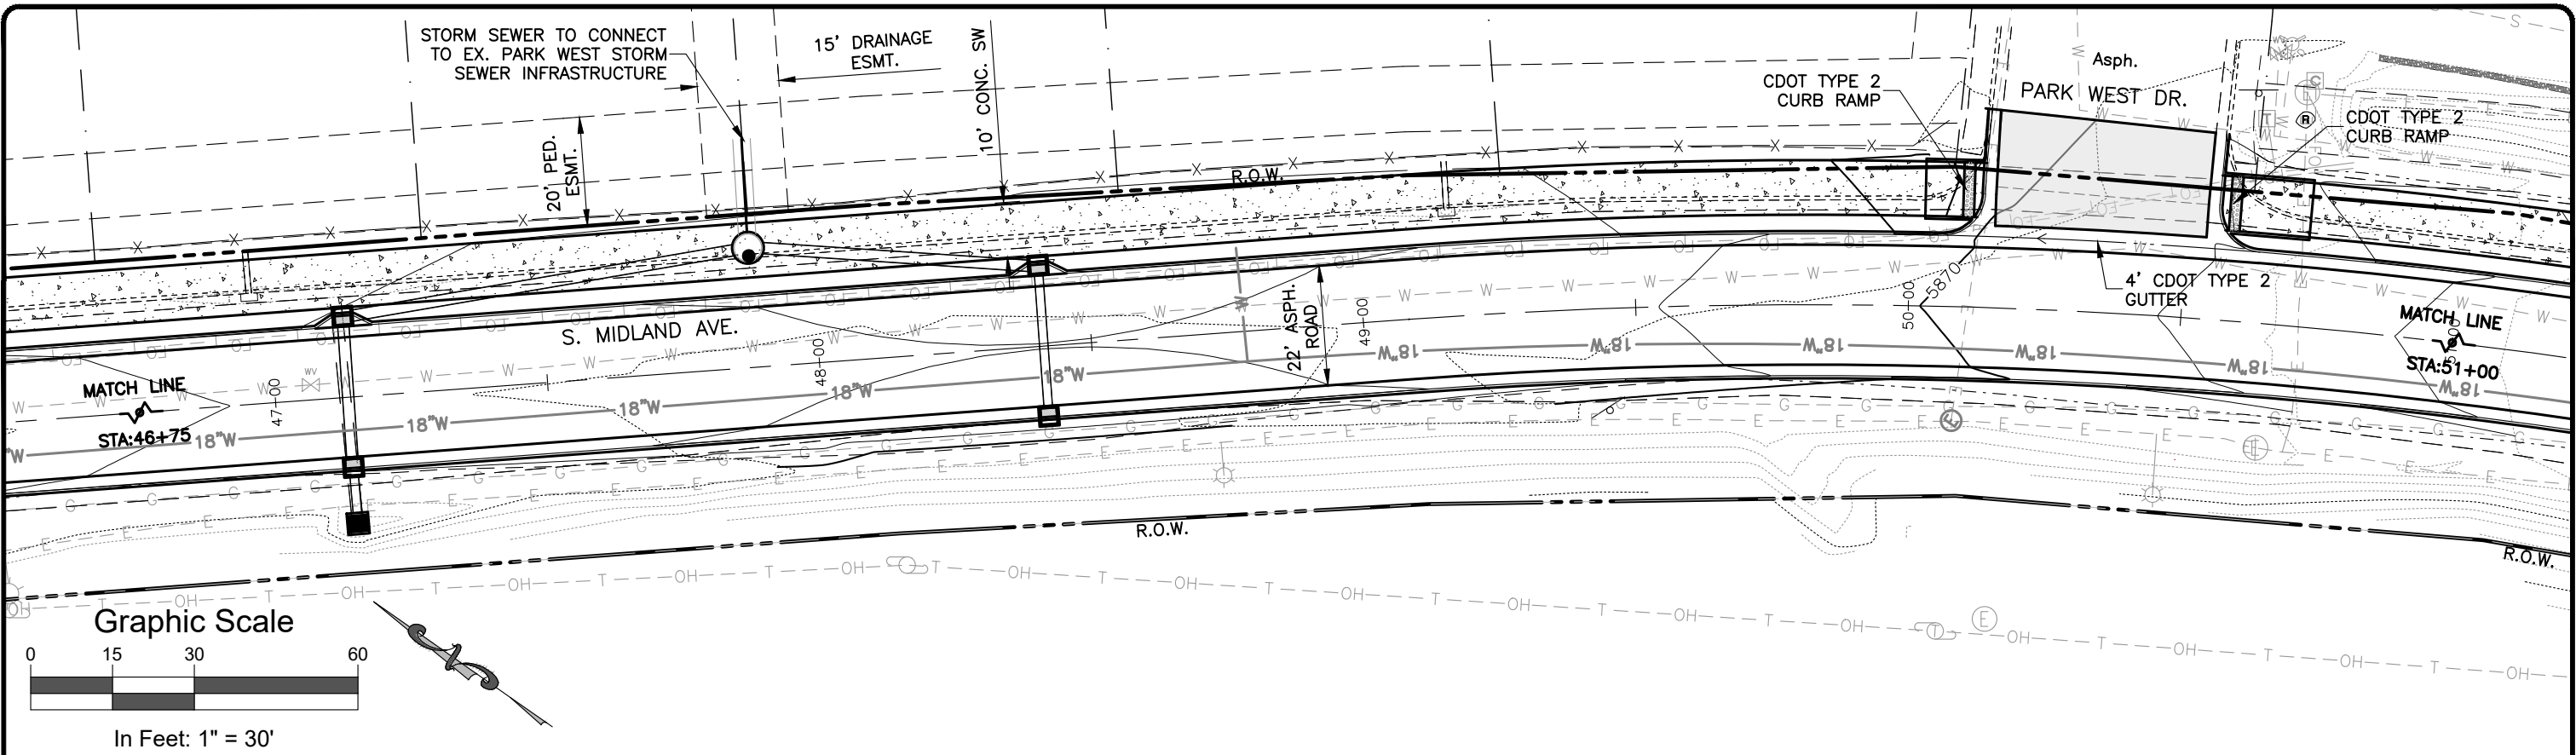

Computer File Information				Sheet Revisions				As Constructed				South Midland Ave. Improvements Plan & Profile 46+75 - 51+00				Project No./Code	
Print Date: 7/14/20				Rev.	Date	Comments	Init.	No Revisions: -				Engineer: MDF				No.: BUILD M535-006	
Last Modification Date: 4/23/2019				1				Revised: -				Structure: ---				Code: 22933	
Drawing File Name: SMidland-PP(2)								Void: -				Drawn By: AMC				Sheet Number: 56	
Autocad Ver. 2018 Scale: As Shown Units: English												Sheet Subset: RDWY					
SGM Project No.: 2017-211.001 Quality Control: RGN												Subset Sheets: 12 of 45					



I:\2017\2017-211-GWSSOMIDLAND\001-MIDLAND4MILERO27THST\H-DWGS\CIVIL\PS-SHEETSET\SMIDLAND-PP(2).DWG Plotted: 7/14/2020 3:23 PM By: Ashley Cline

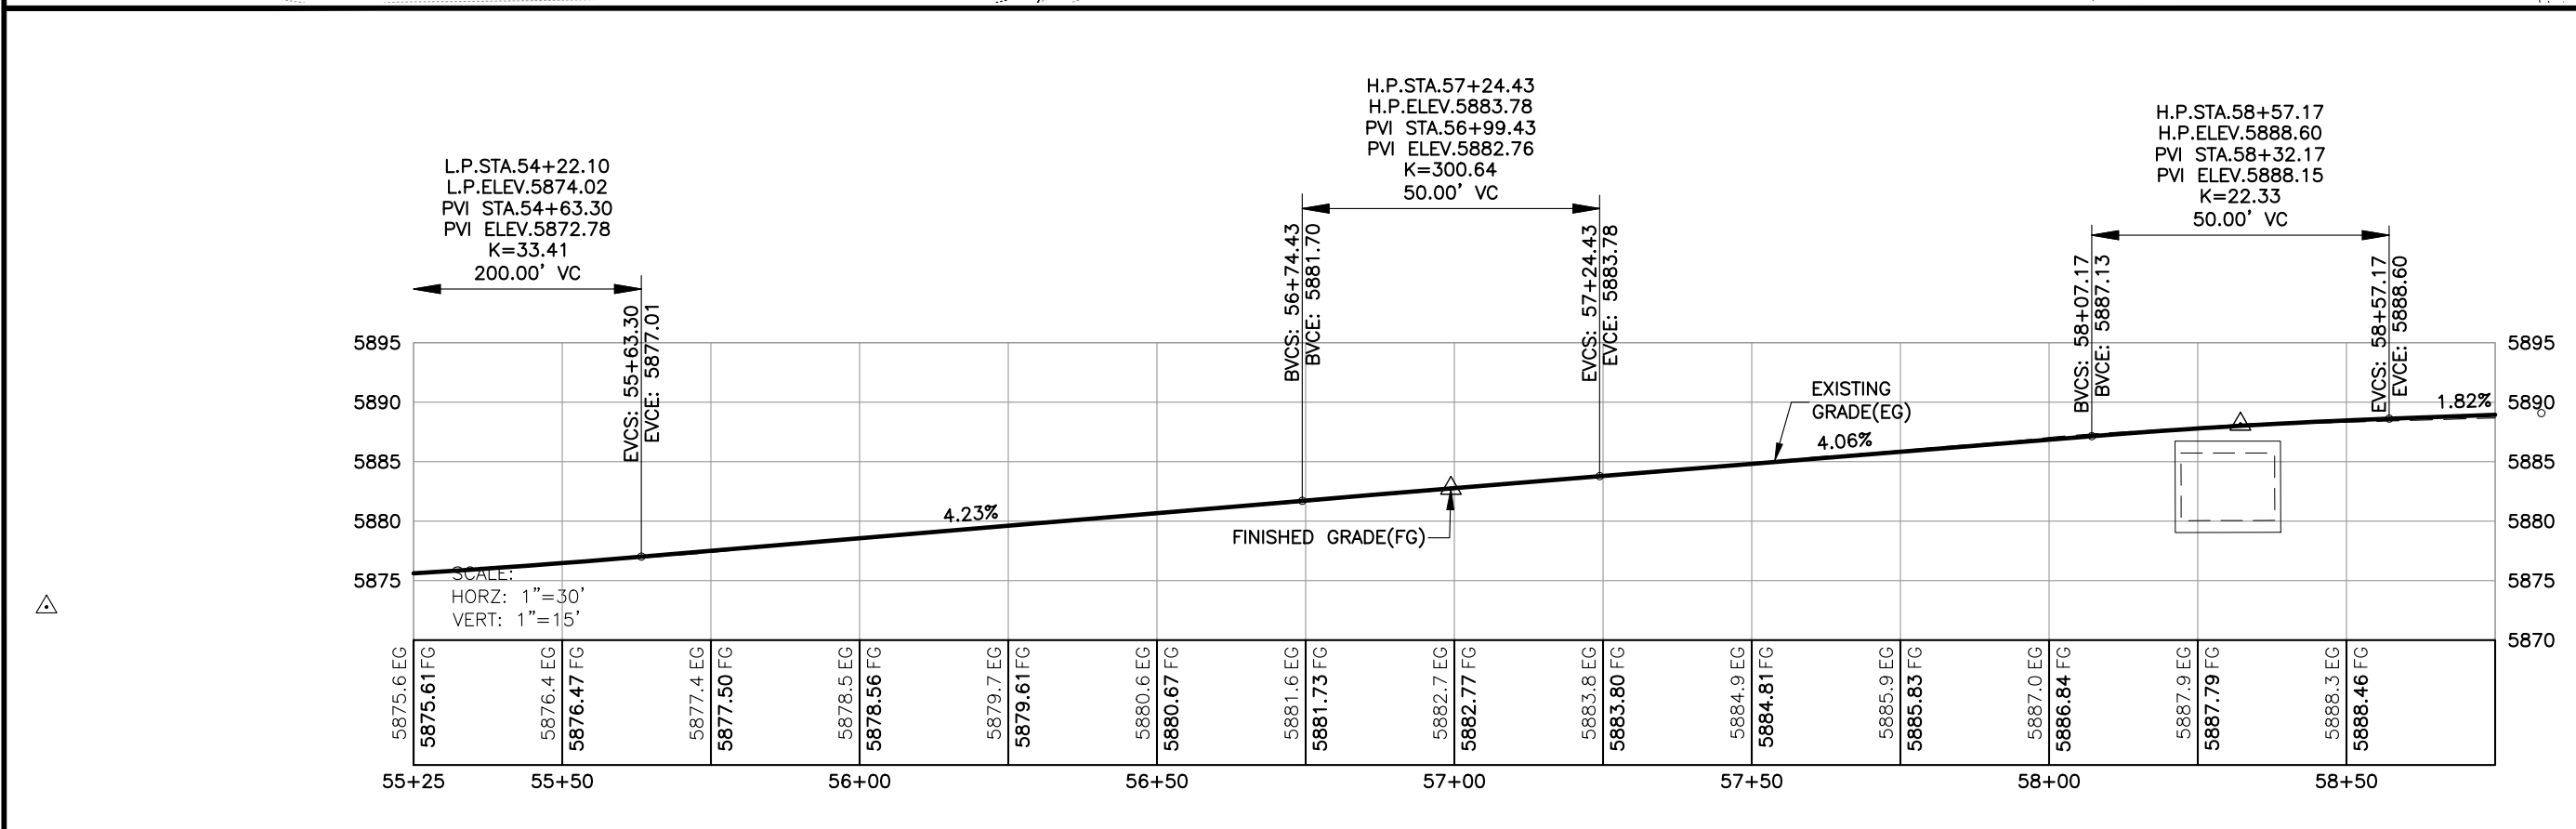
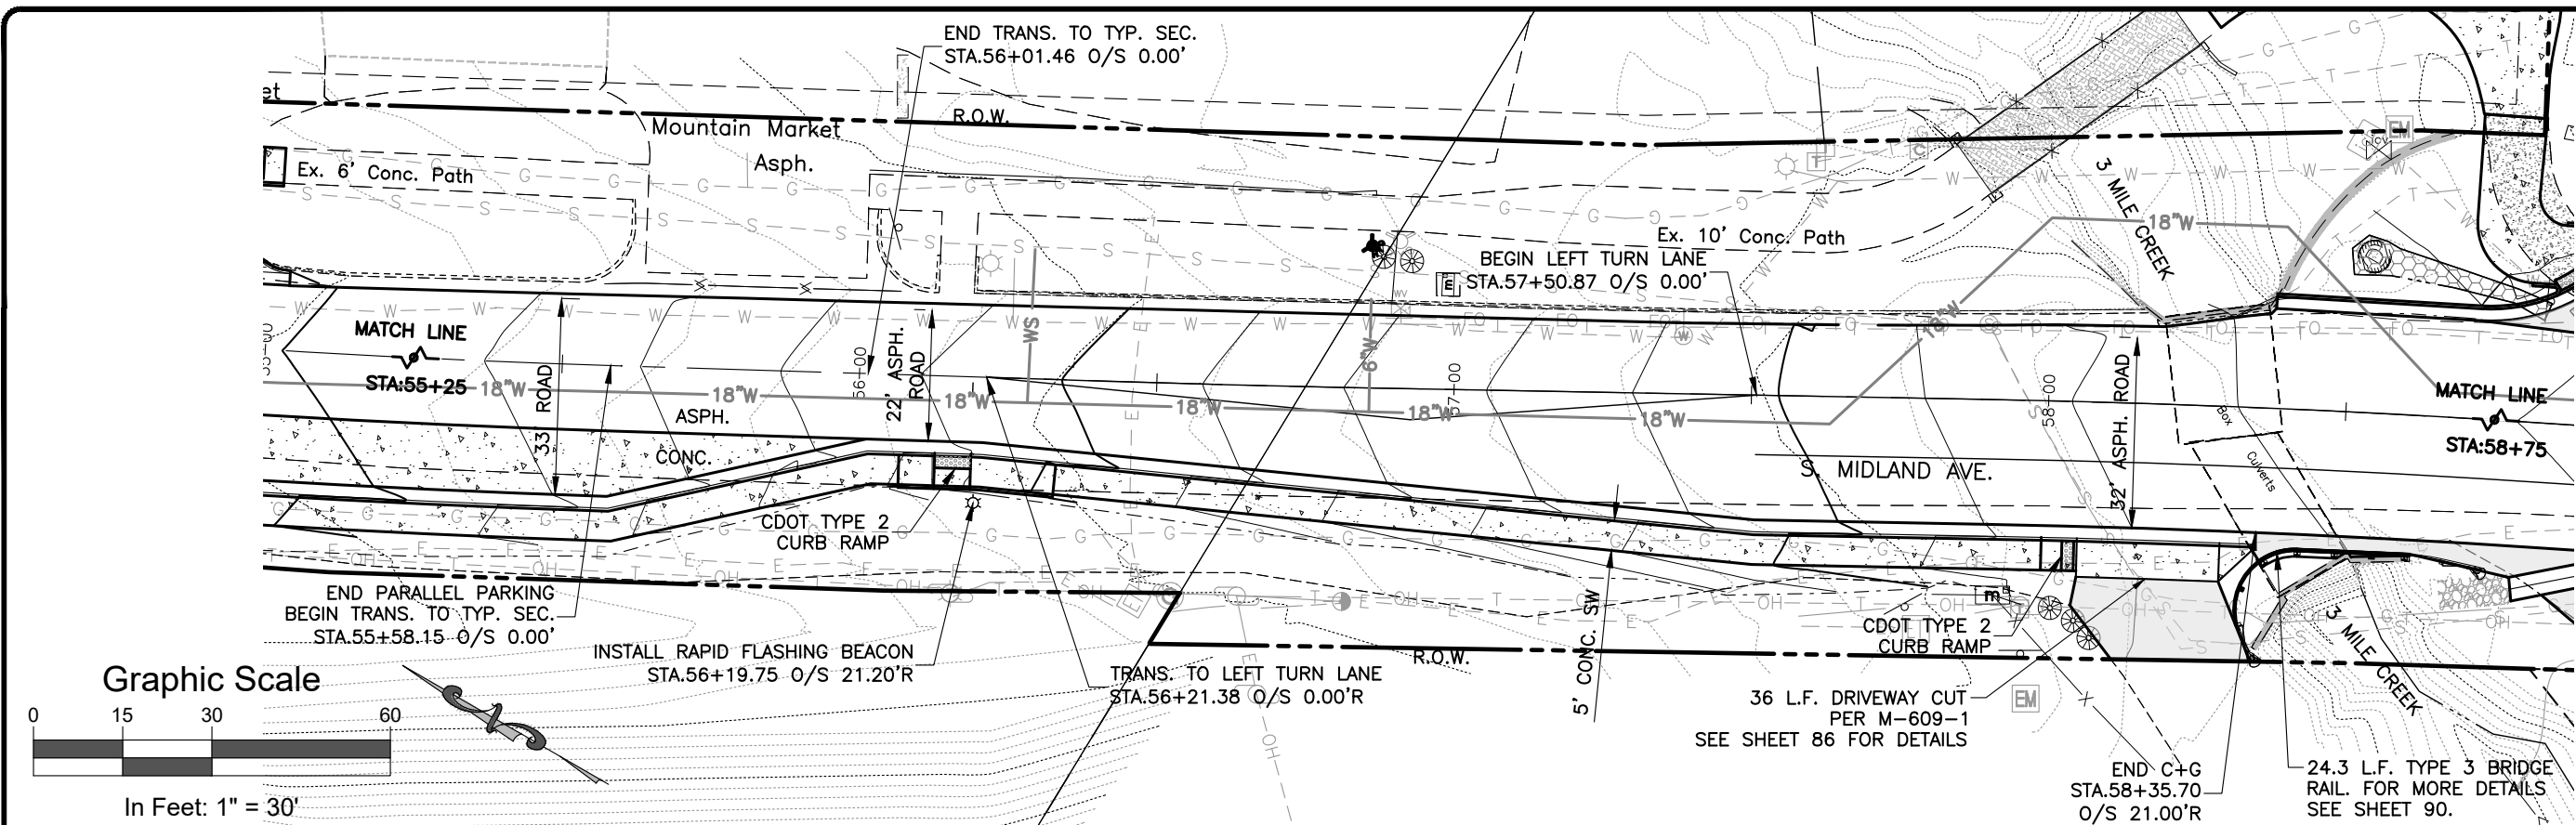


Computer File Information		Sheet Revisions				As Constructed		South Midland Ave. Improvements Plan & Profile 55+25 - 58+75			Project No./Code	
Print Date: 7/14/20	Last Modification Date: 4/23/2019	Rev.	Date	Comments	Init.	No Revisions:	-	Engineer:	MDF	Structure	No.: BUILD M535-006	
Drawing File Name: SMidland-PP(2)		1				Revised:	-	Drawn By:	AMC	Numbers	Code: 22933	
Autocad Ver. 2018	Scale: As Shown					Void:	-	Sheet Subset:	RDWY	Subset Sheets: 14 of 45	Sheet Number: 58	
SGM Project No.: 2017-211.001	Quality Control: RGN											



118 West Sixth Street, Suite 200
Glenwood Springs, CO 81601
970.945.1004 www.sgm-inc.com




I:\2017\211-GWSSMIDLAND\001-MIDLAND4MILERD27THST\H-DWGS\CIVIL\PS-SHEETSET\SMIDLAND-PP(3).DWG Plotted: 7/14/2020 3:25 PM By: Ashley Cline

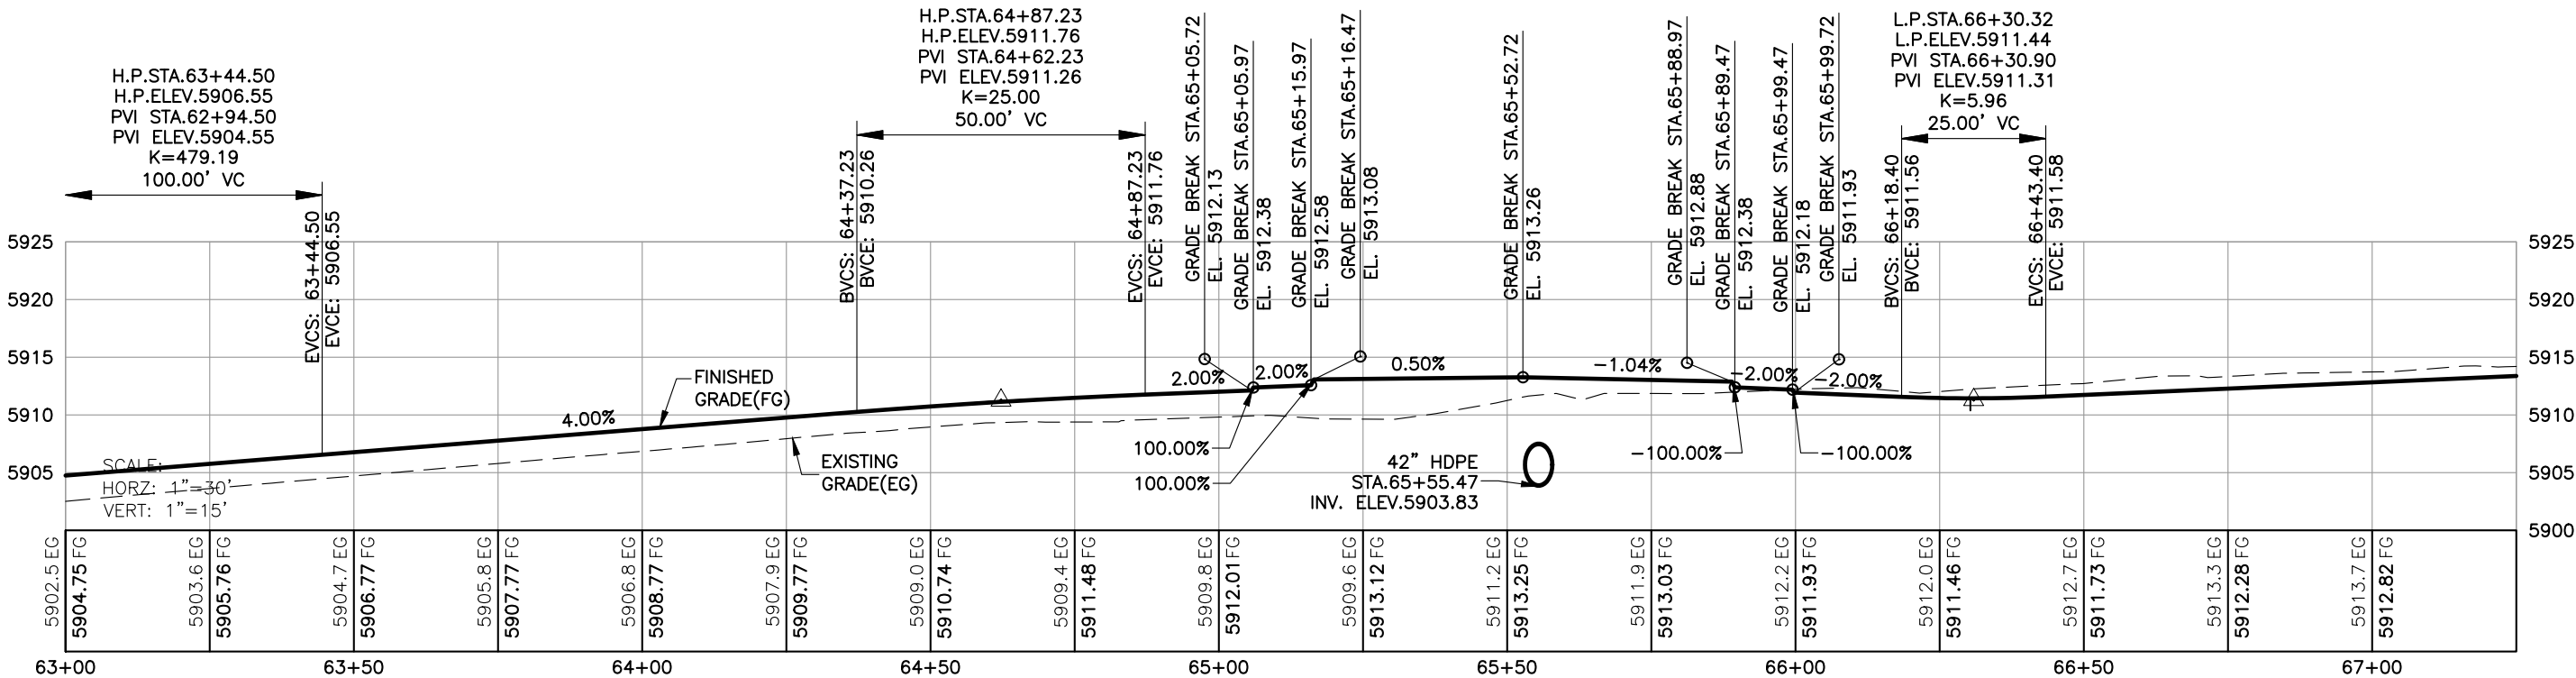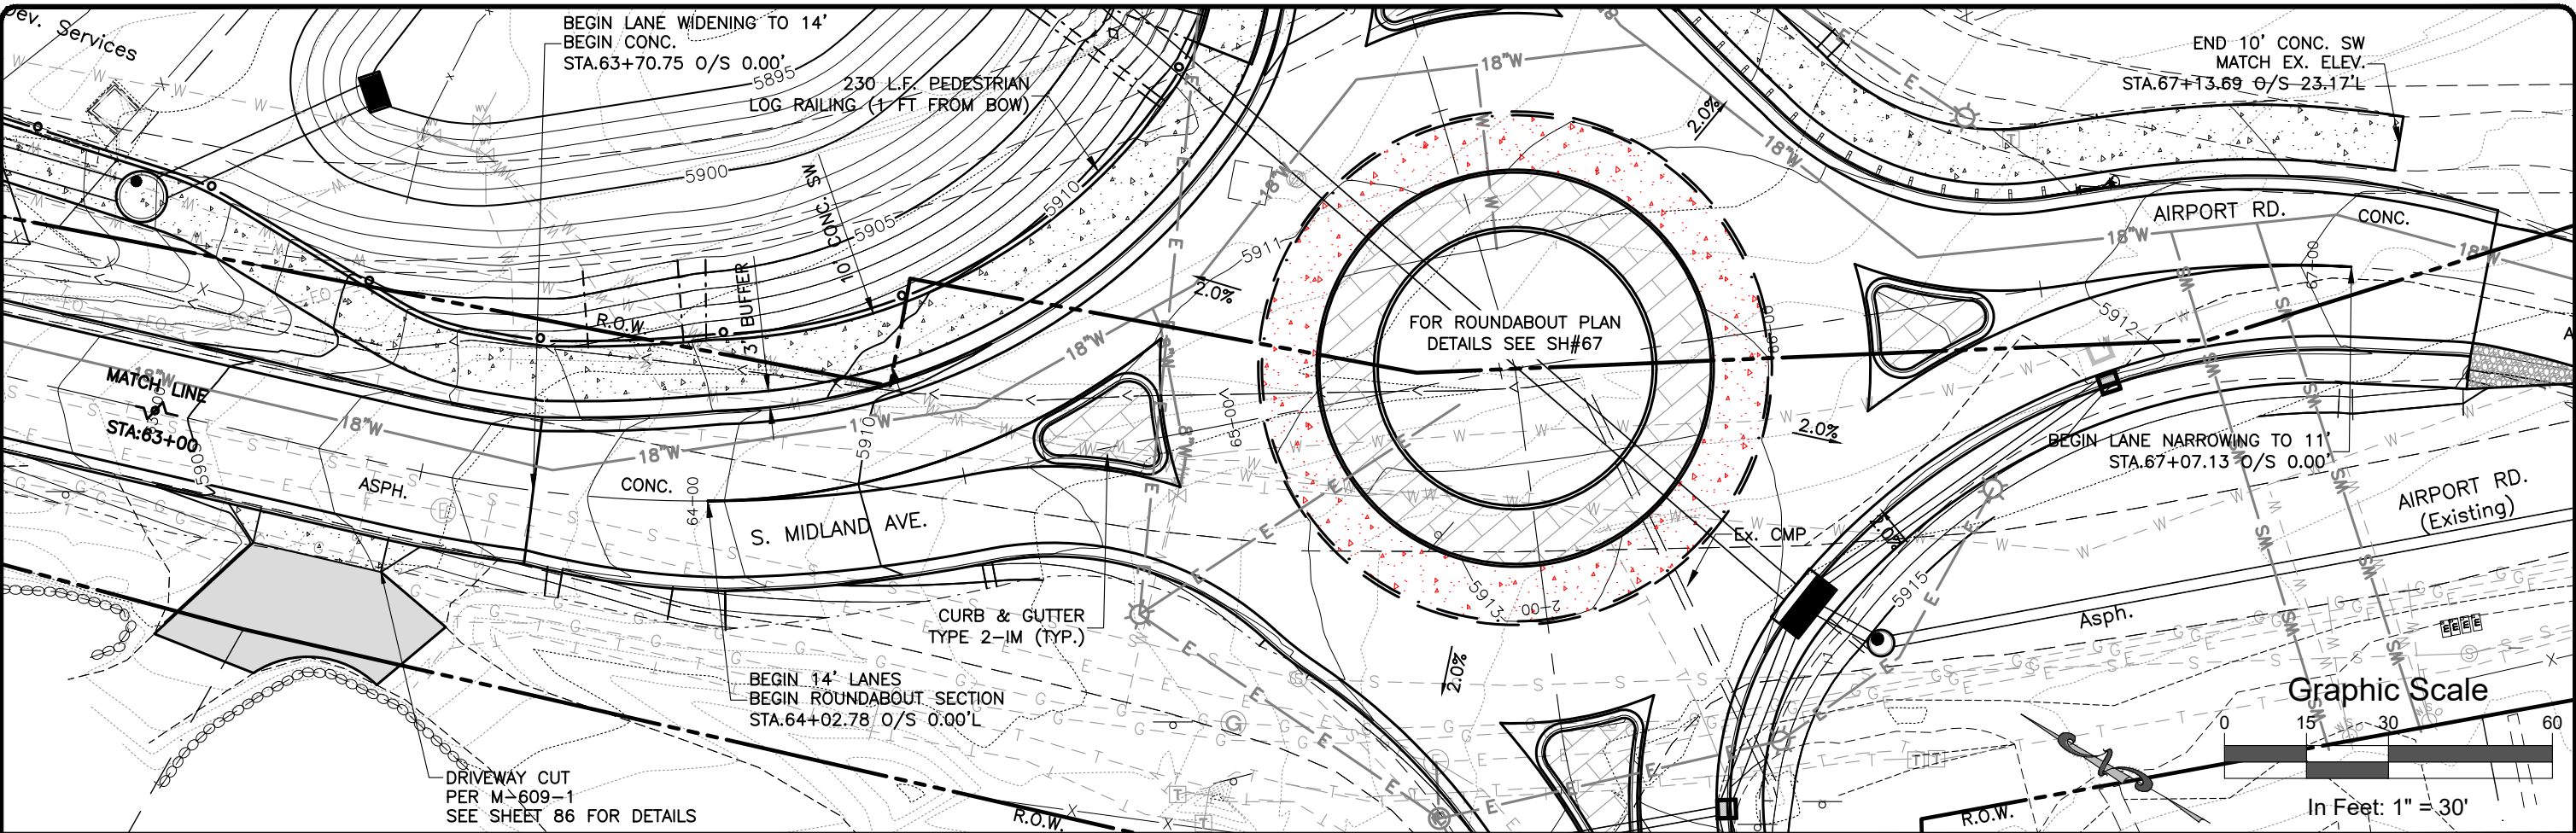

Computer File Information				Sheet Revisions				As Constructed				South Midland Ave. Improvements Plan & Profile 63+00 - 67+25				Project No./Code	
Print Date:	7/14/20	Last Modification Date:	4/23/2019	Rev.	Date	Comments	Init.	No Revisions:	-	Revised:	-	Engineer:	MDF	Structure	---	No.:	BUILD M535-006
Drawing File Name:	SMidland-PP(3)	Autocad Ver.	2018	Scale:	As Shown	Units:	English	Void:	-	Sheet Subset:	RDWY	Drawn By:	AMC	Numbers	---	Code:	22933
SGM Project No.:	2017-211.001	Quality Control:	RGH									Sheet Subset:	RDWY	Subset Sheets:	16 of 45	Sheet Number:	60





I:\2017\2017-211-GWSSOMIDLAND\001-MIDLAND4MILERO27THST\H-DWGS\CIVIL\PS-SHEETSET\SMIDLAND-PP(3).DWG Plotted: 7/14/2020 3:25 PM By: Ashley Cline

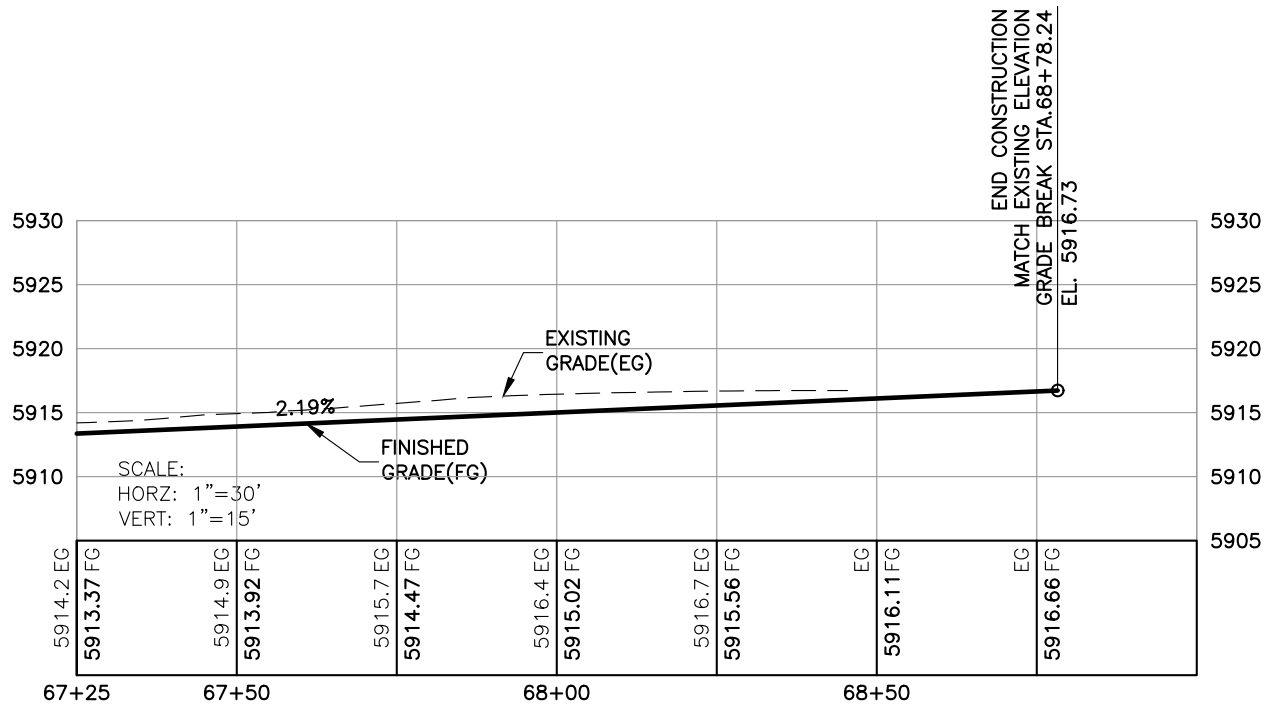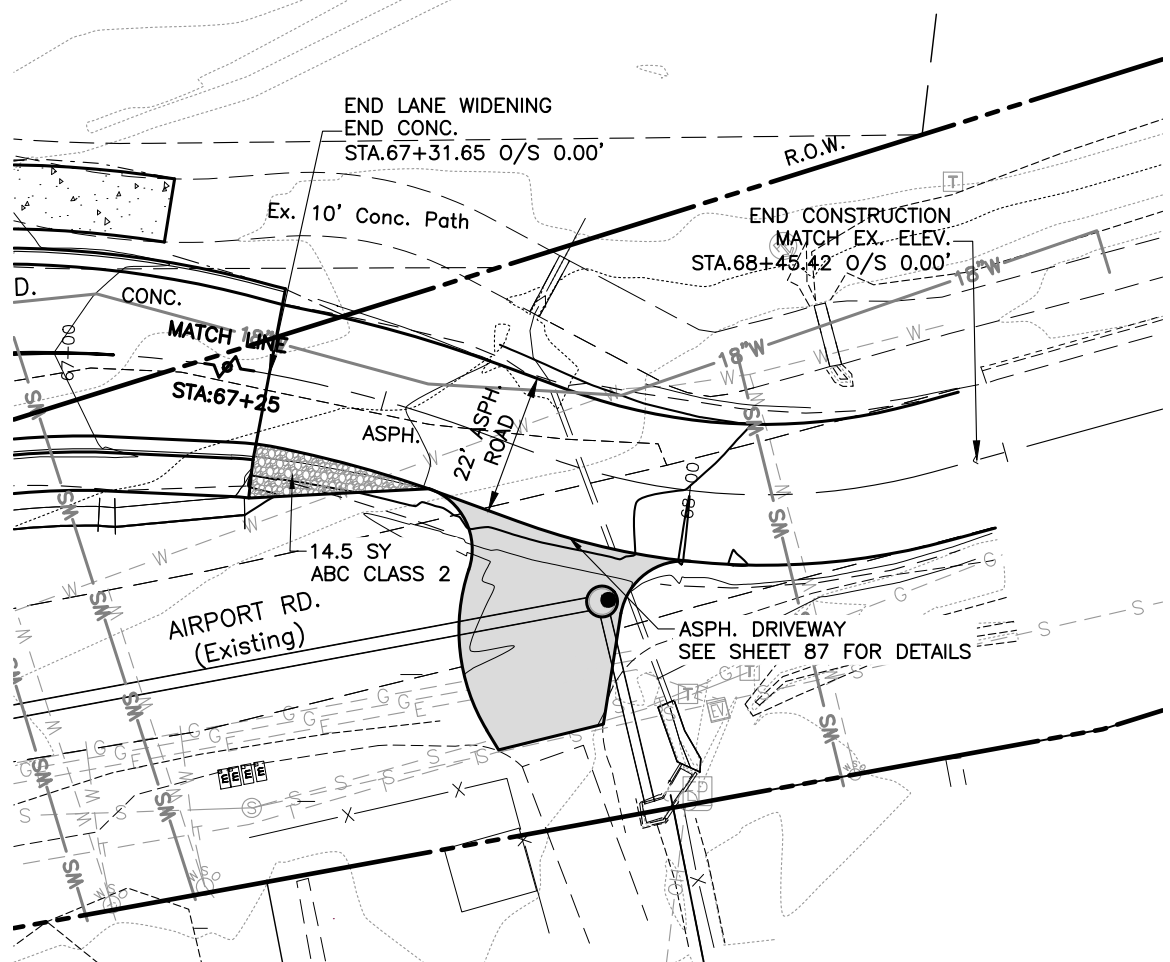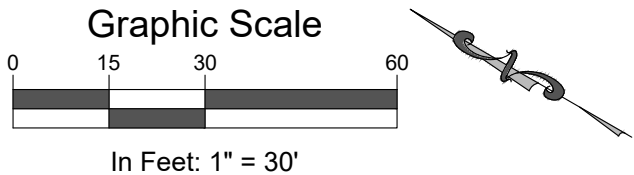

Computer File Information		Sheet Revisions					 118 West Sixth Street, Suite 200 Glenwood Springs, CO 81601 970.945.1004 www.sgm-inc.com	As Constructed		South Midland Ave. Improvements Plan & Profile 67+25 - 68+46.32			Project No./Code	
Print Date: 7/14/20		Rev.	Date	Comments	Init.			No Revisions: -		Engineer: MDF Structure --- Drawn By: AMC Numbers --- Sheet Subset: RDWY Subset Sheets: 17 of 45			No.: BUILD M535-006	
Last Modification Date: 4/23/2019		1						Revised: -					Code: 22933	
Drawing File Name: SMidland-PP(3)								Void: -		Sheet Number: 61				
Autocad Ver. 2018 Scale: As Shown Units: English														
SGM Project No.: 2017-211.001 Quality Control: RGN														



I:\2017\2017-211-GWSSMIDLAND\001-MIDLAND4MILRD27THST\H-DWGS\CIVIL\PS-SHEETSET\SMIDLAND-PP(3).DWG Plotted: 7/14/2020 3:26 PM By: Ashley Cline

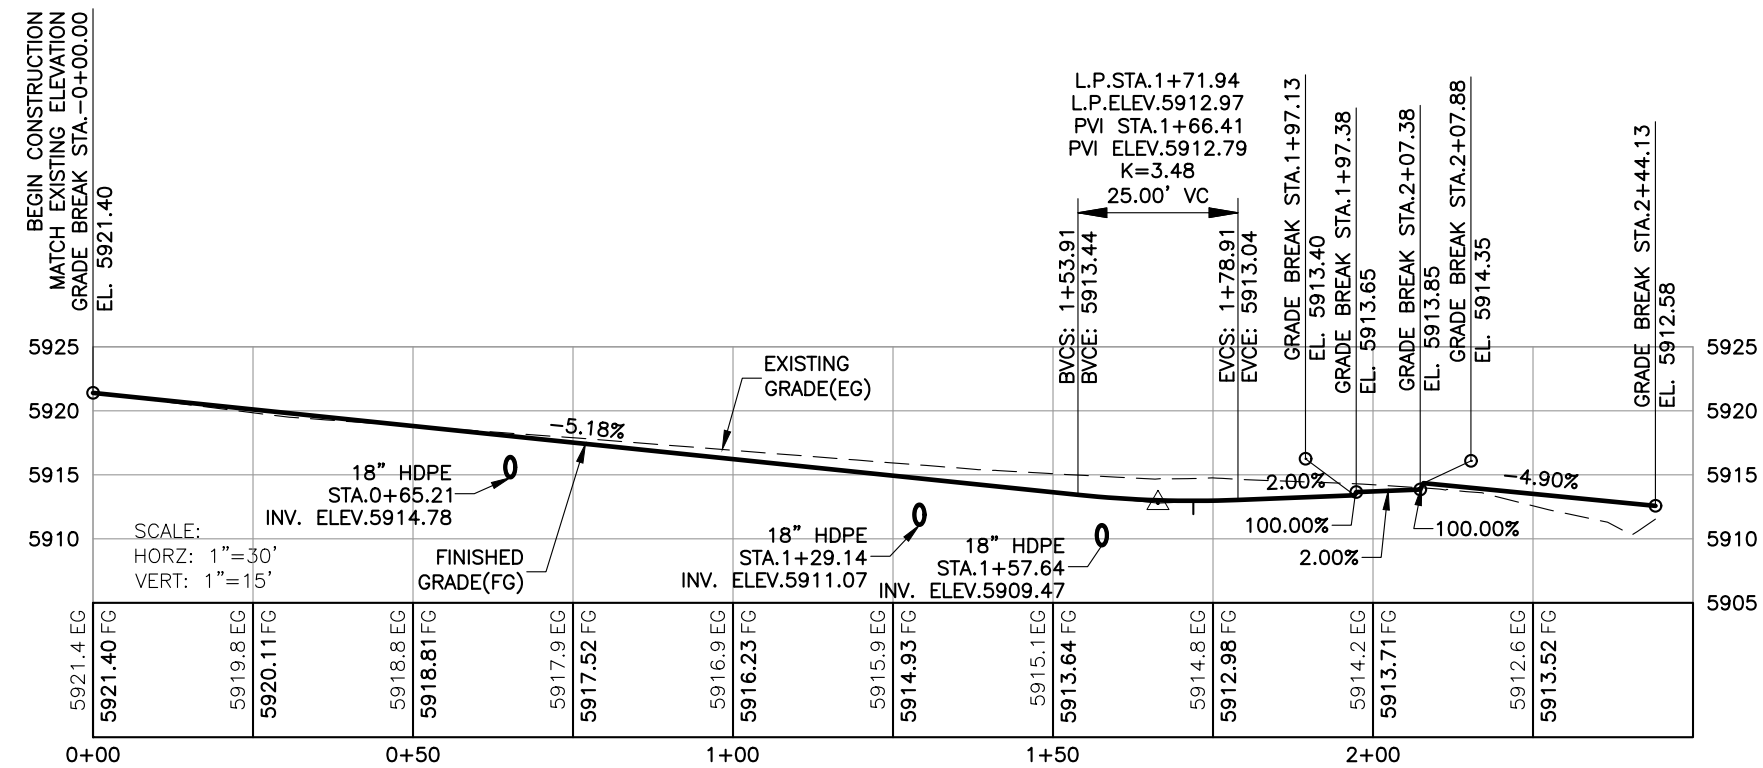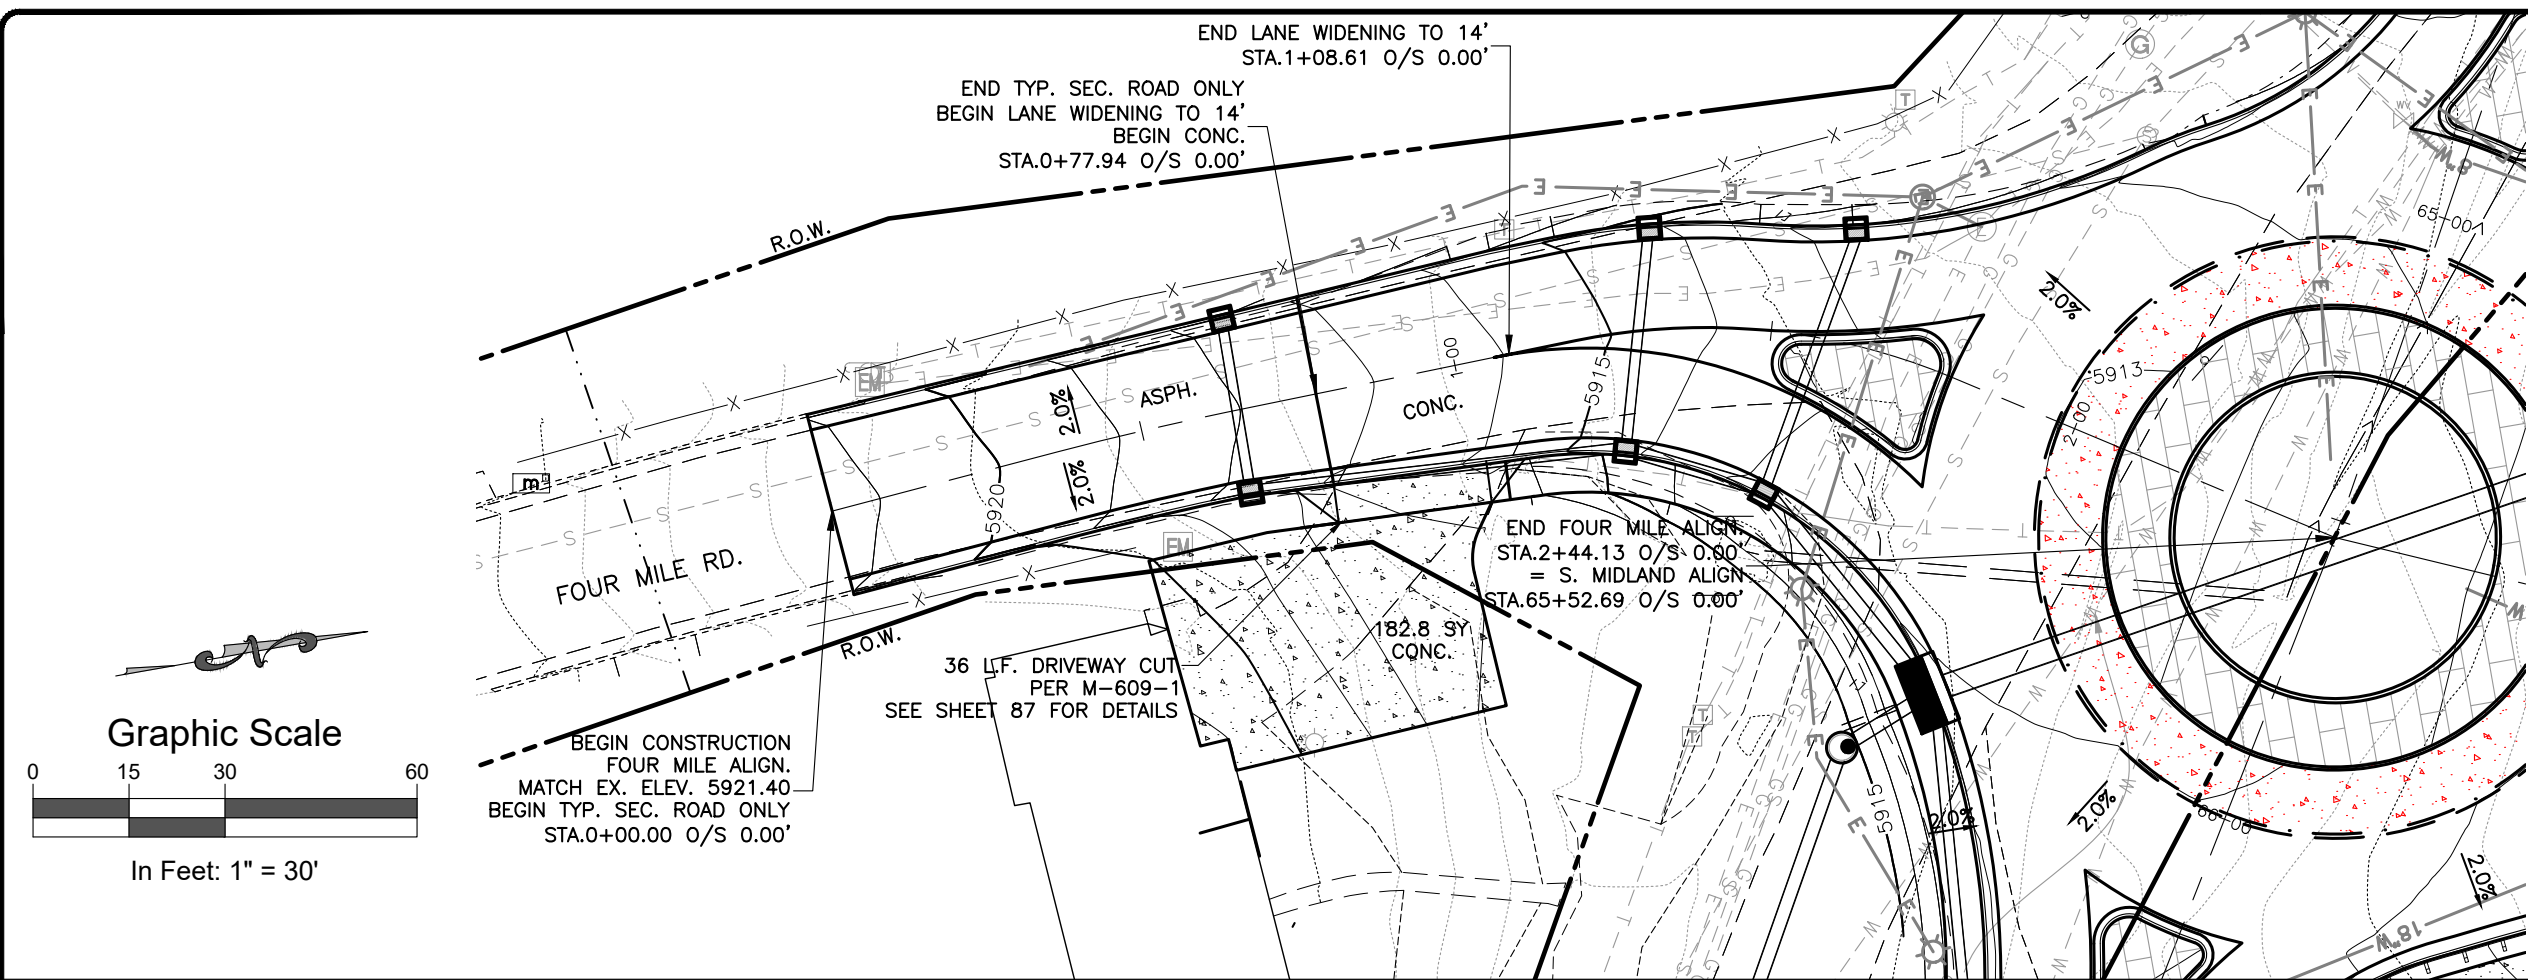

Computer File Information		Sheet Revisions				As Constructed		South Midland Ave. Improvements Four Mile Road Plan & Profile			Project No./Code	
Print Date: 7/14/20	Last Modification Date: 4/23/2019	Rev.	Date	Comments	Init.						No.: BUILD M535-006	
Drawing File Name: SMidland-PP(3)		1				No Revisions:	-	Engineer: MDF	Structure	---	Code: 22933	
Autocad Ver. 2018	Scale: As Shown					Revised:	-	Drawn By: AMC	Numbers	---	Sheet Number: 62	
SGM Project No.: 2017-211.001	Quality Control: RGN					Void:	-	Sheet Subset: RDWY	Subset Sheets:	18 of 45		





GLENWOOD
SPRINGS
COLORADO





118 West Sixth Street, Suite 200
Glenwood Springs, CO 81601
970.945.1004 www.sgm-inc.com

I:\2017\2017-211-GWSSOMIDLAND\001-MIDLAND4MILERO27TH\H-DWGS\CIVIL\PS-SHEETSET\SMIDLAND-PP(3).DWG Plotted: 7/14/2020 3:26 PM By: Ashley Cline

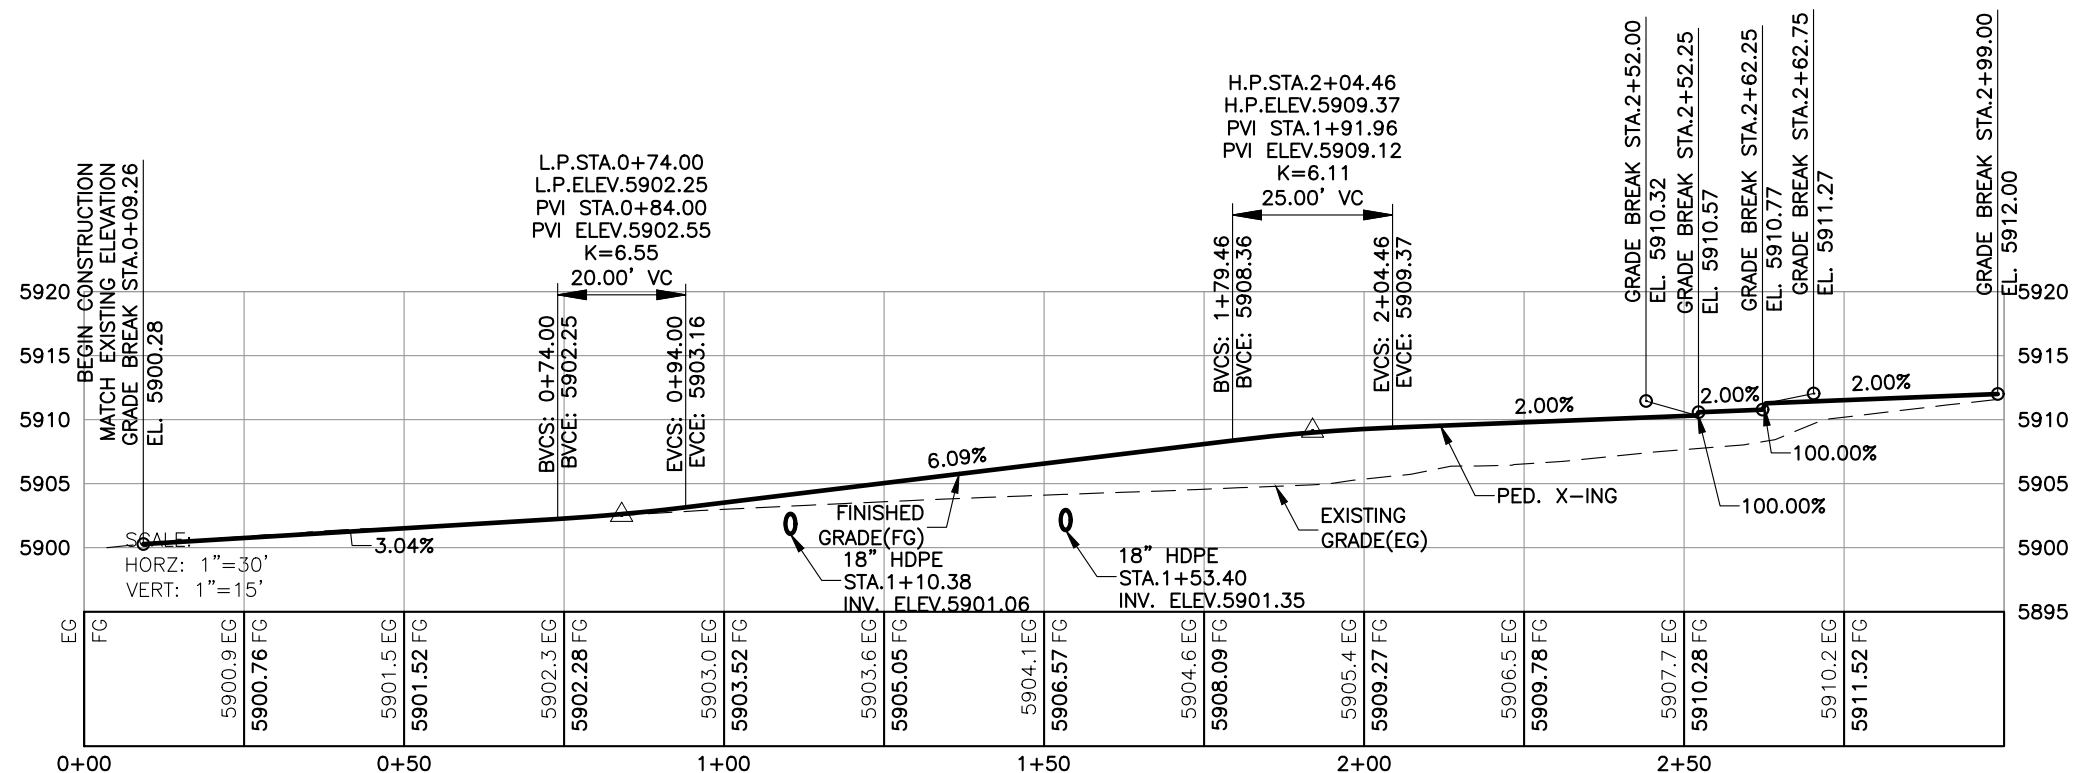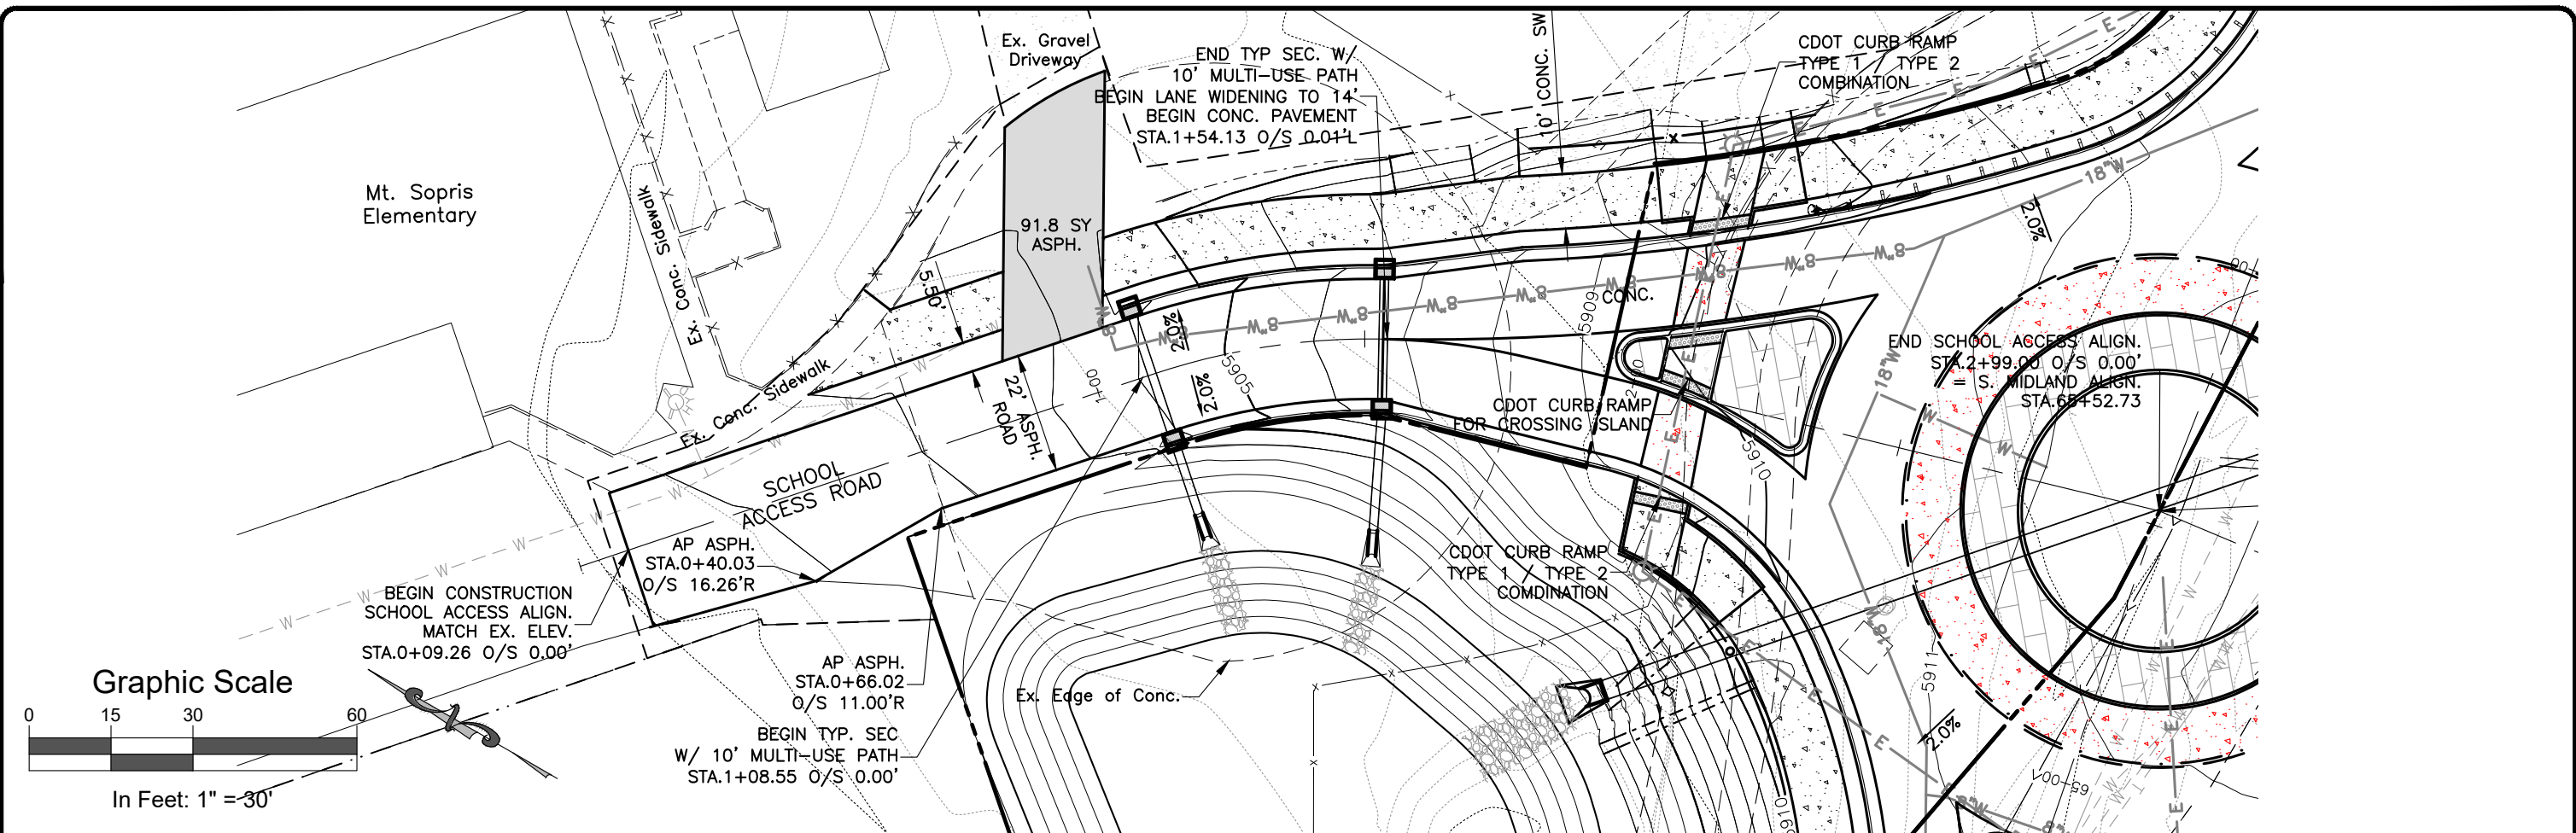


Computer File Information		Sheet Revisions			GLENWOOD SPRINGS COLORADO	SGM	As Constructed		South Midland Ave. Improvements School Access Plan & Profile			Project No./Code	
Print Date: 7/14/20	Last Modification Date: 4/23/2019	Rev.	Date	Comments			No Revisions:	-	Engineer:	MDF	Structure	No.: BUILD M535-006	
Drawing File Name: SMidland-PP(3)		1					Revised:	-	Drawn By:	AMC	Numbers	Code: 22933	
Autocad Ver. 2018	Scale: As Shown						Void:	-	Sheet Subset:	RDWY	Subset Sheets:	19 of 45	Sheet Number: 63
SGM Project No.: 2017-211.001		Quality Control: RGN											

I:\2017\2017-211-GWSSMIDLAND\001-MIDLAND4MILE\RD27TH\H-DWGS\CIVIL\PS-SHEETSET\SMIDLAND-INTERSECTIONPP.DWG Plotted: 7/14/2020 3:29 PM By: Ashley Cline

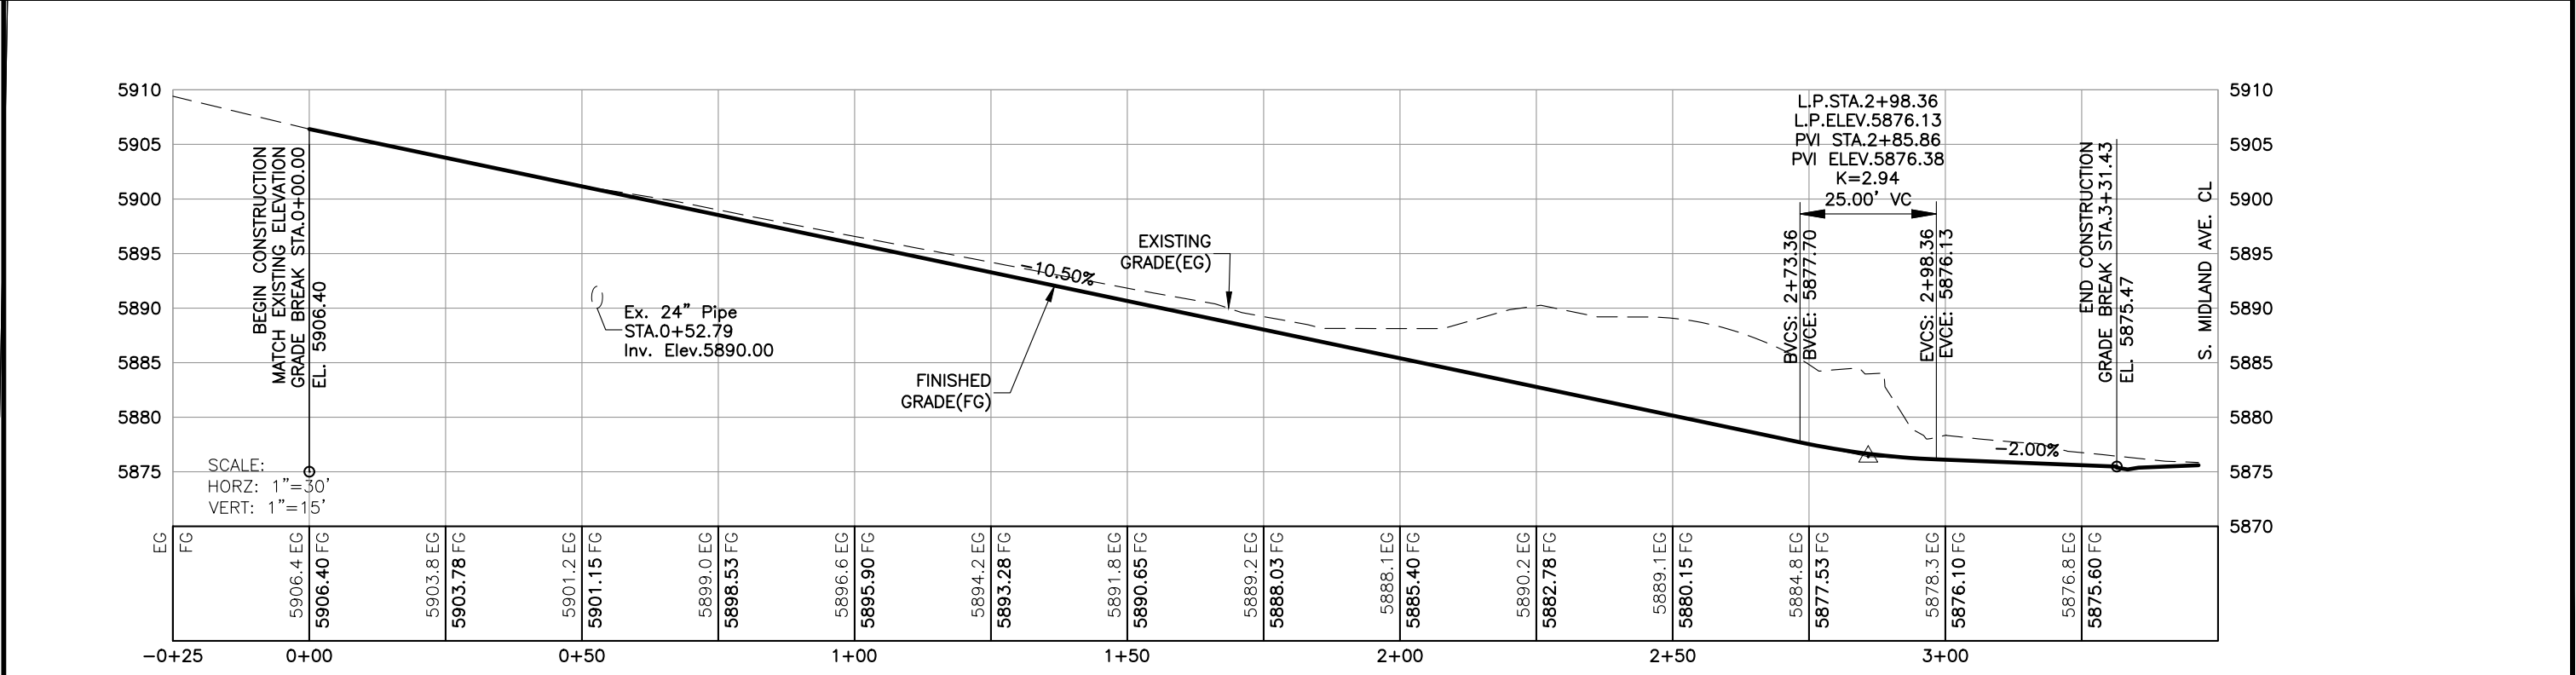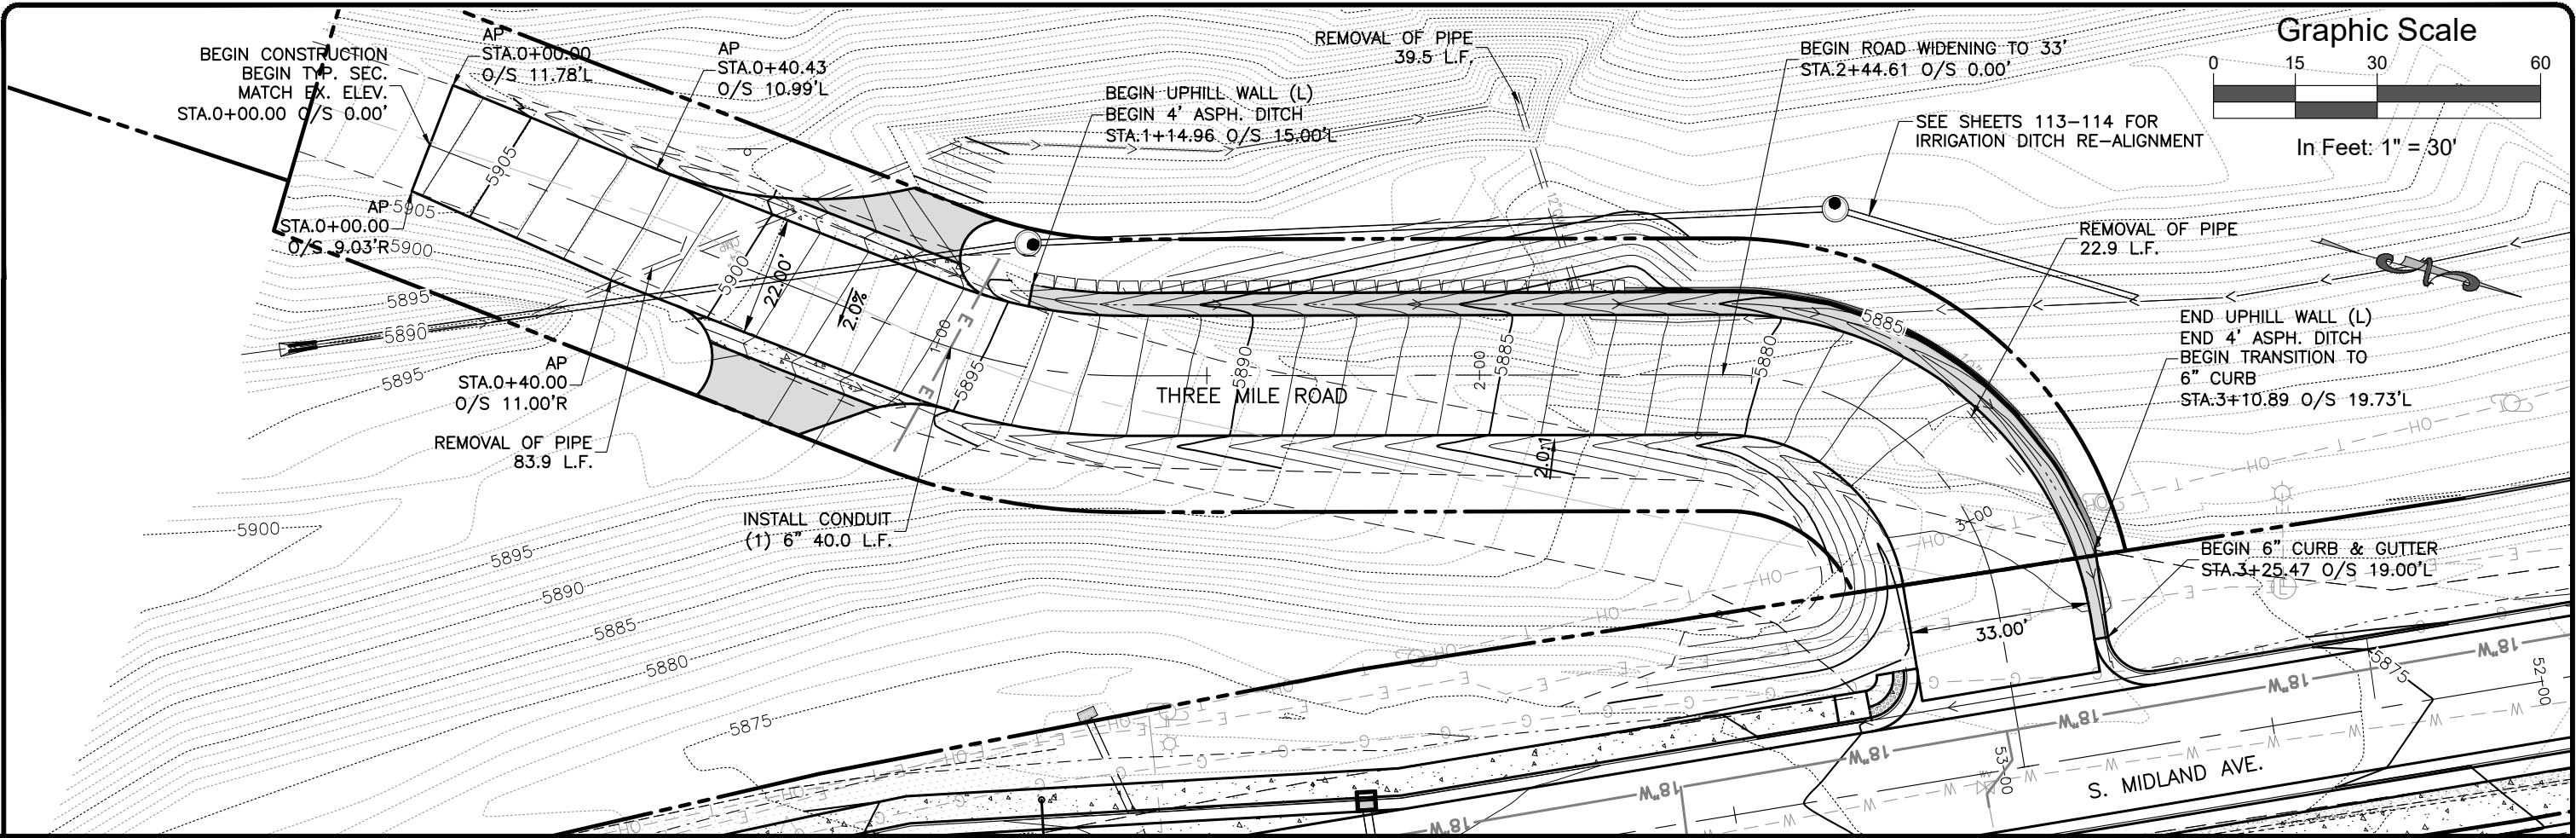

Computer File Information		Sheet Revisions				As Constructed		South Midland Ave. Improvements Three Mile Road Plan & Profile				Project No./Code	
Print Date:	7/14/20	Rev.	Date	Comments	Init.	No Revisions:	-	Engineer:	MDF	Structure	---	No.:	BUILD M535-006
Last Modification Date:	4/23/2019	1				Revised:	-	Drawn By:	AMC	Numbers	---	Code:	22933
Drawing File Name:	SMidland-IntersectionPP					Void:	-	Sheet Subset:	RDWY	Subset Sheets:	22 of 45	Sheet Number:	66
Autocad Ver.	2018												
Scale:	As Shown												
Units:	English												
SGM Project No.:	2017-211.001												
Quality Control:	RGN												


I:\2017\2017-211-GWSSMIDLAND\001-MIDLAND4MILERD27THST\H-DWGS\CIVIL\PS-SHEETSET\SMIDLAND-PP(3).DWG Plotted: 7/14/2020 3:31 PM By: Ashley Cline

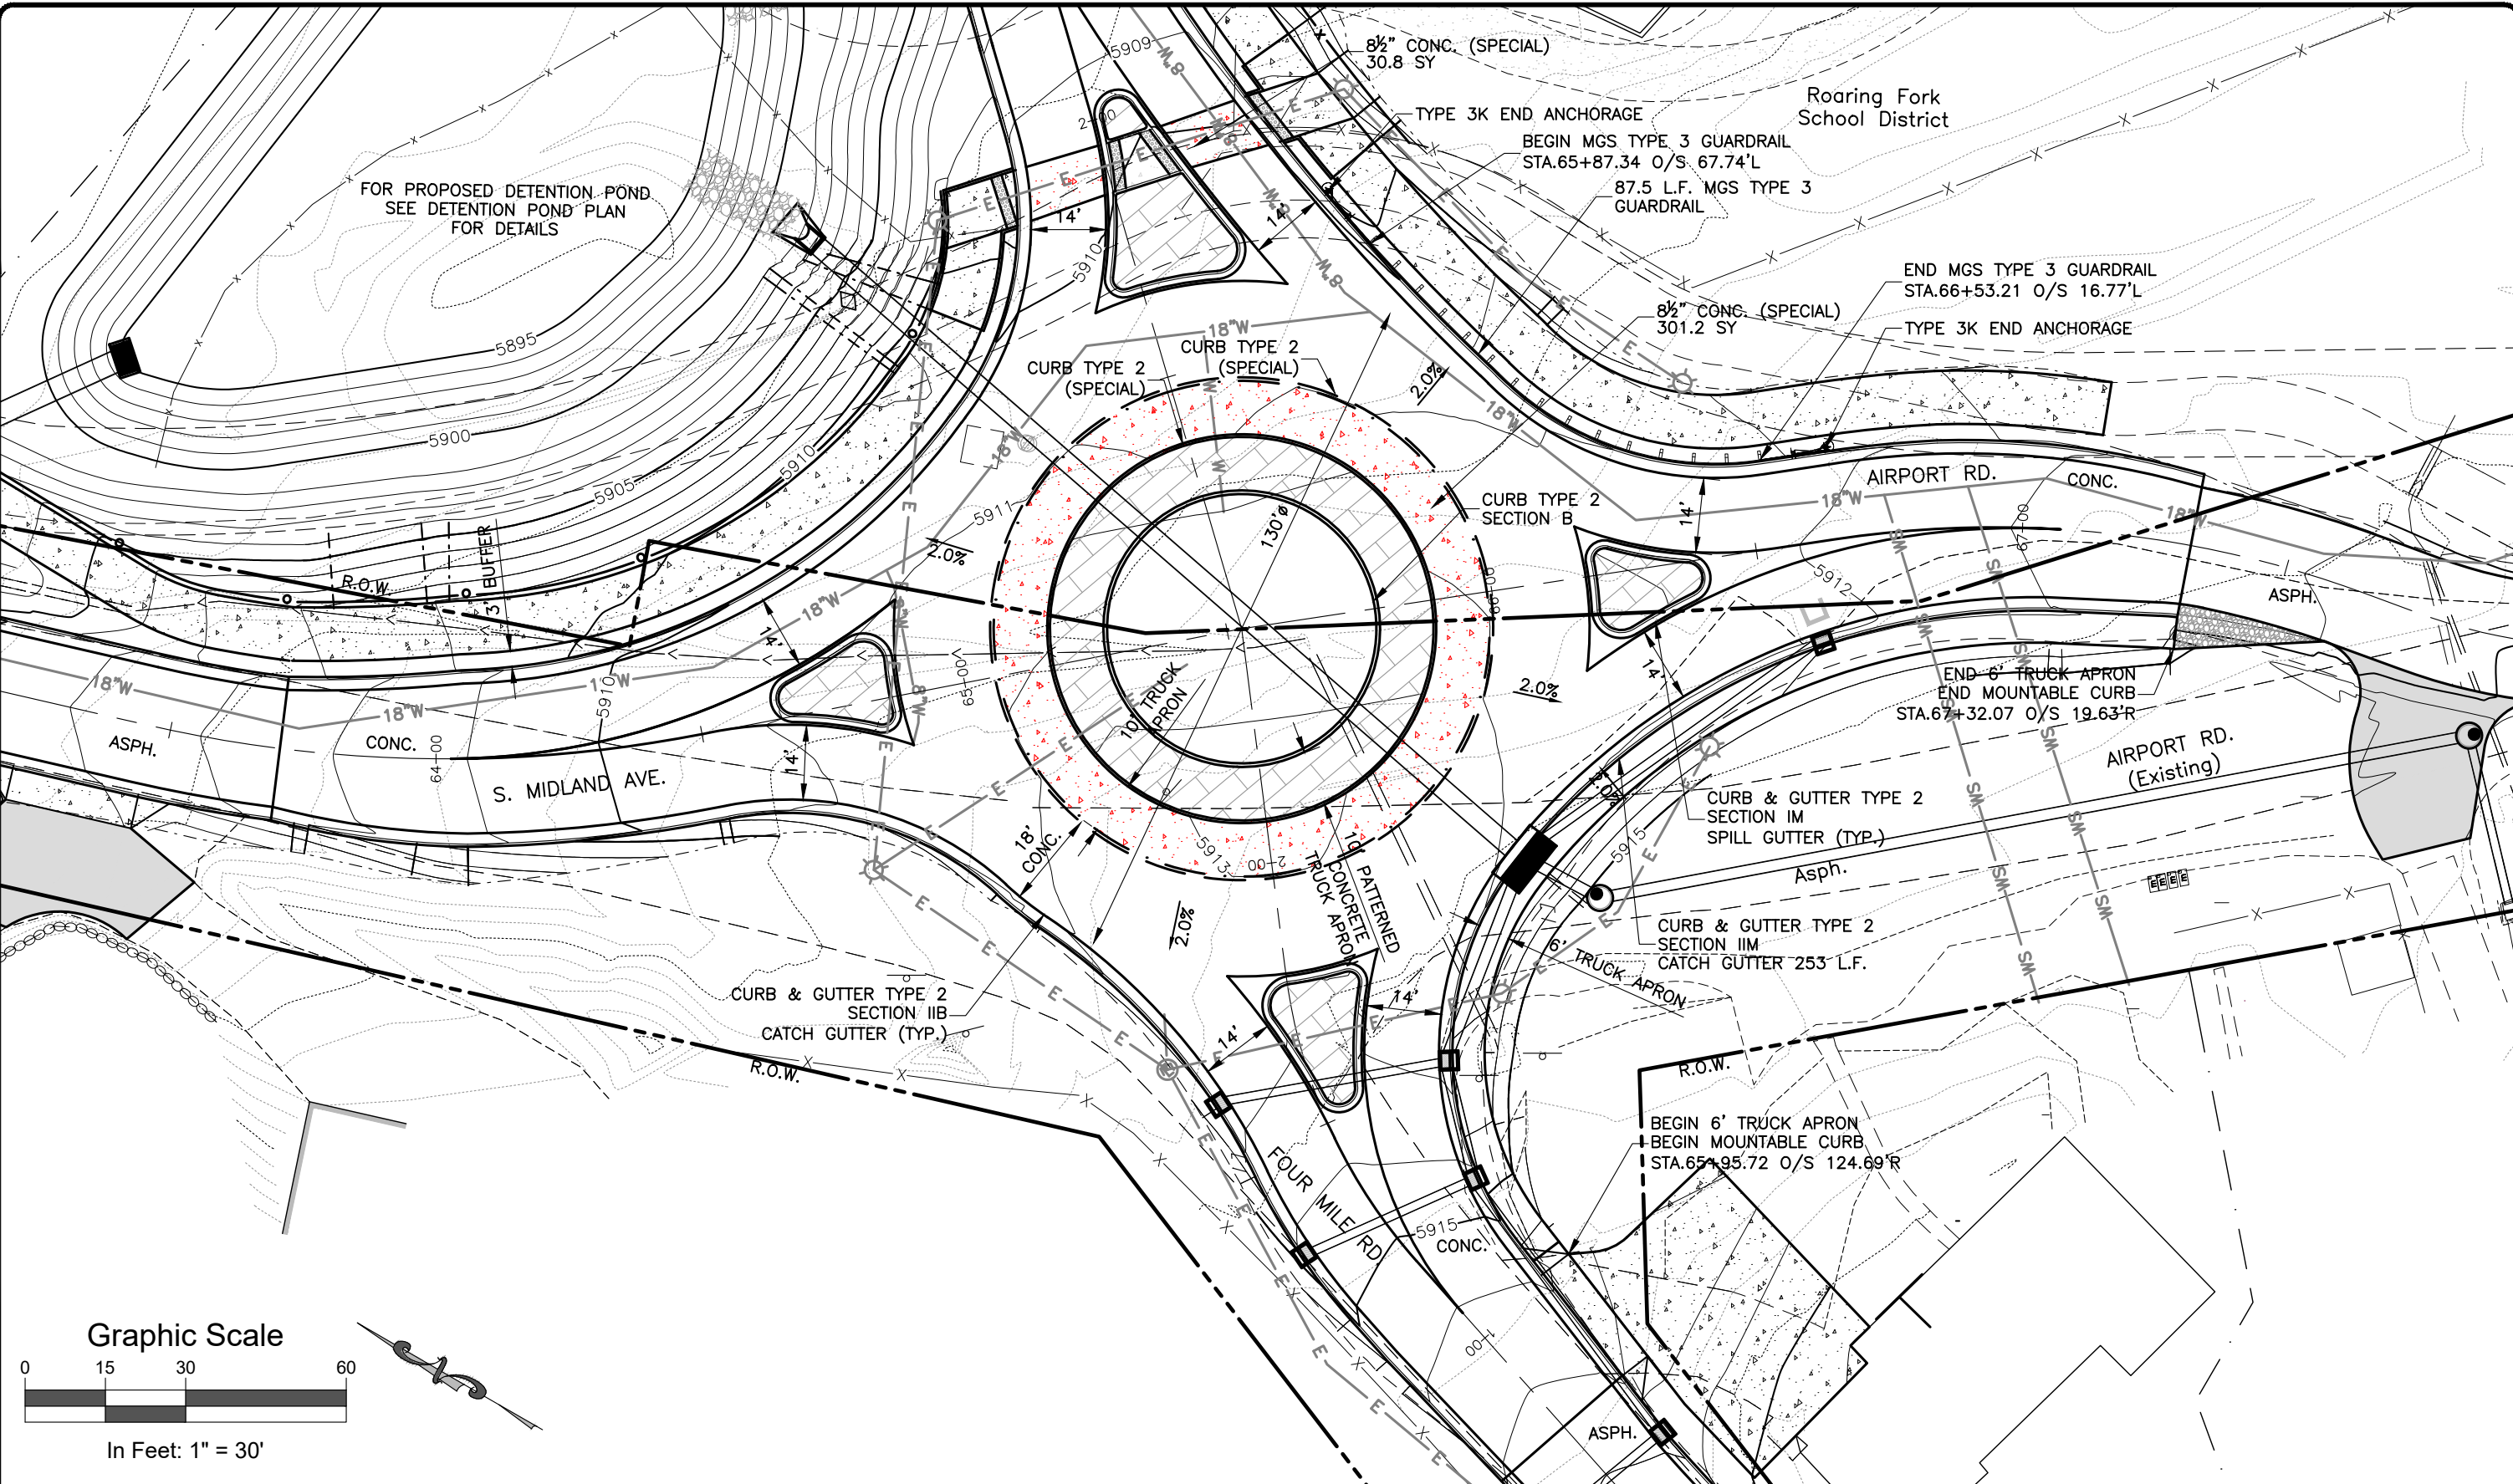

Computer File Information		Sheet Revisions				As Constructed		South Midland Ave. Improvements Roundabout Plan			Project No./Code	
Print Date:	7/14/20	Rev.	Date	Comments	Init.	No Revisions:	-	Engineer: MDF Structure: --- Drawn By: AMC Numbers: --- Sheet Subset: RDWY Subset Sheets: 23 of 45			No.:	BUILD M535-006
Last Modification Date:	4/23/2019	1				Revised:	-				Code:	22933
Drawing File Name:	SMidland-PP(3)					Void:	-				Sheet Number:	67
Autocad Ver. 2018	Scale: As Shown Units: English											
SGM Project No.: 2017-211.001		Quality Control: RGN										

118 West Sixth Street, Suite 200
Glenwood Springs, CO 81601
970.945.1004 www.sgm-inc.com


I:\2017\2017-211-GWSSOMIDLAND\001-MIDLAND4MILERO27THST\H-DWGS\CIVIL\PS-SHEETSET\SMIDLAND-ROUNDABOUTDETAILS.DWG Plotted: 7/14/2020 3:32 PM By: Ashley Cline

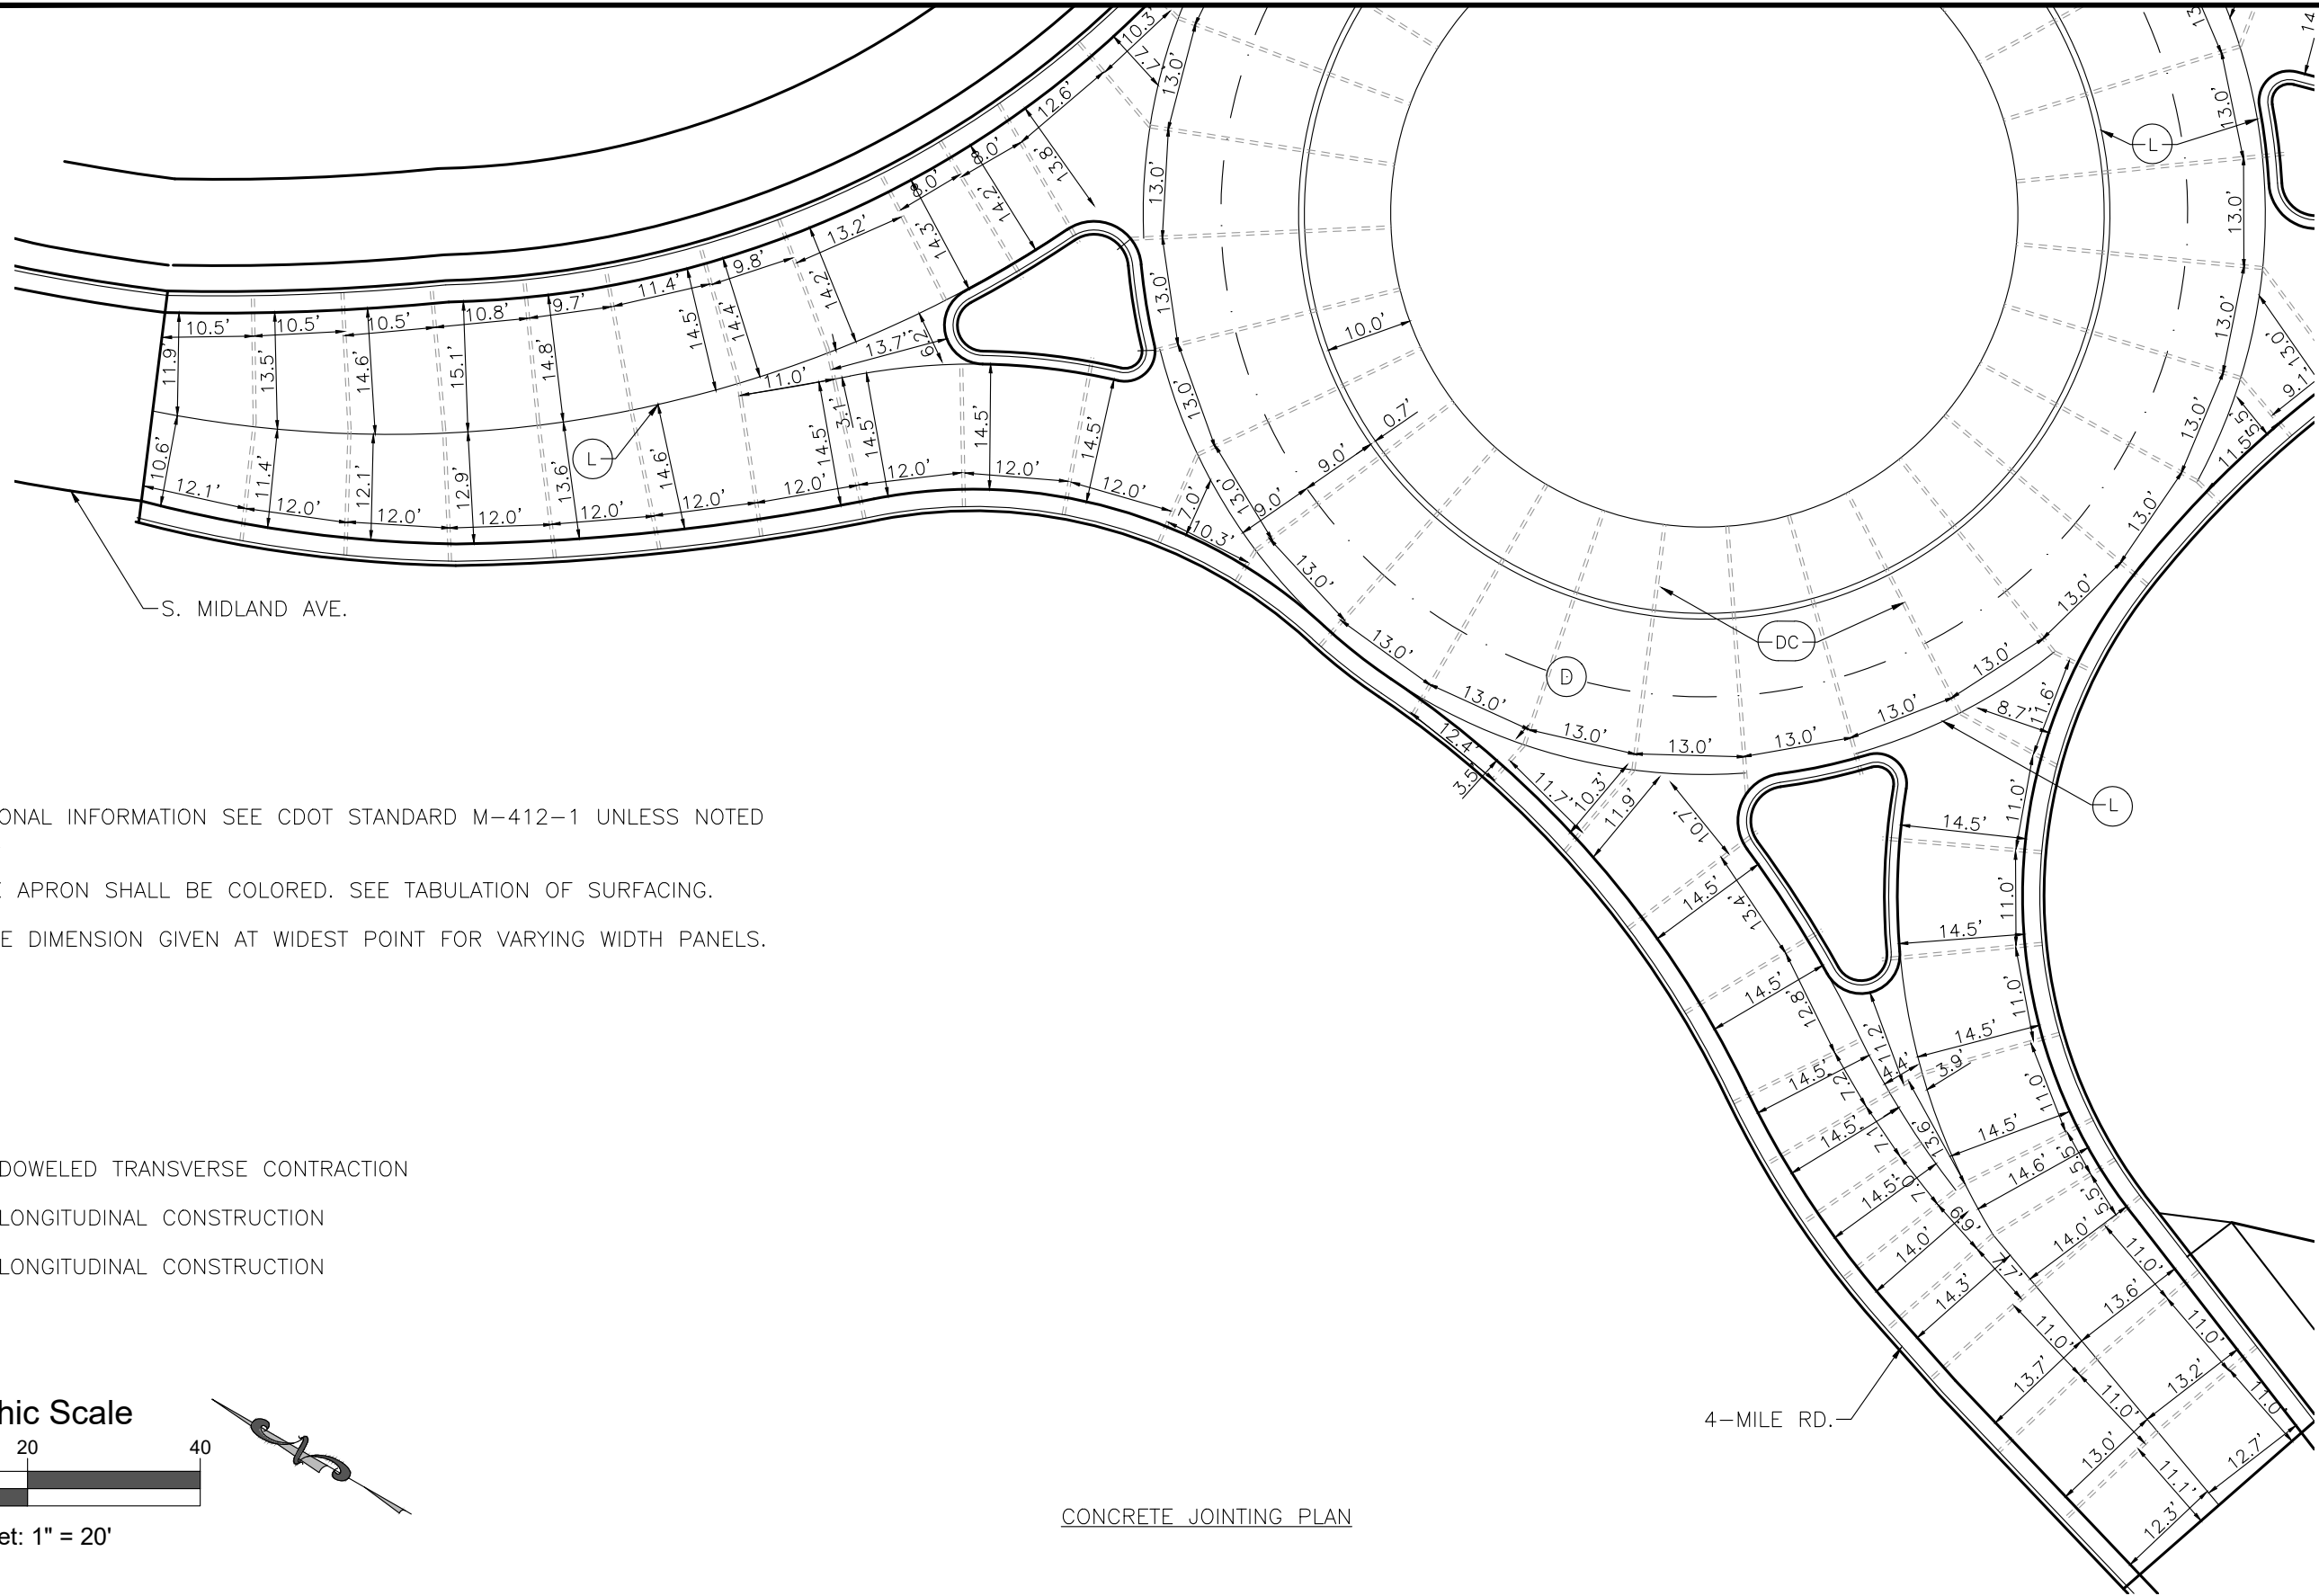

- NOTE:
- 1. FOR ADDITIONAL INFORMATION SEE CDOT STANDARD M-412-1 UNLESS NOTED OTHERWISE.
 - 2. THE TRUCK APRON SHALL BE COLORED. SEE TABULATION OF SURFACING.
 - 3. TRANSVERSE DIMENSION GIVEN AT WIDEST POINT FOR VARYING WIDTH PANELS.

JOINT LEGEND

- (DC)----: DOWELED TRANSVERSE CONTRACTION
- (L)—: LONGITUDINAL CONSTRUCTION
- - - - (D) - - - -: LONGITUDINAL CONSTRUCTION

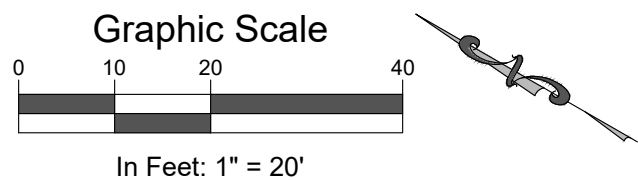

Computer File Information		Sheet Revisions						 118 West Sixth Street, Suite 200 Glenwood Springs, CO 81601 970.945.1004 www.sgm-inc.com		As Constructed		South Midland Ave. Improvements Roundabout Jointing Plan			Project No./Code	
Print Date: 7/14/20		Rev.	Date	Comments	Init.					No Revisions: -					Engineer: MDF	
Last Modification Date: 4/23/2019		1						 118 West Sixth Street, Suite 200 Glenwood Springs, CO 81601 970.945.1004 www.sgm-inc.com		Revised: -		Engineer: MDF		Structure	Code: 22933	
Drawing File Name: SMidland-RoundaboutDetails										Void: -		Drawn By: AMC		Numbers	Sheet Number: 68	
Autocad Ver. 2018 Scale: As Shown Units: English										Sheet Subset: RDWY		Subset Sheets: 24 of 45				
SGM Project No.: 2017-211.001 Quality Control: RGN																





 
118 West Sixth Street, Suite 200
Glenwood Springs, CO 81601
970.945.1004 www.sgm-inc.com

1. FOR ADDITIONAL INFORMATION SEE CDOT STANDARD M-412-1 UNLESS NOTED OTHERWISE.
2. THE TRUCK APRON SHALL BE COLORED. SEE TABULATION OF SURFACING.
3. TRANSVERSE DIMENSION GIVEN AT WIDEST POINT FOR VARYING WIDTH PANELS.


===(DC)===: DOWELED TRANSVERSE CONTRACTION
 —(L)—: LONGITUDINAL CONSTRUCTION
 - - - (D) - - - : LONGITUDINAL CONSTRUCTION



Graphic Scale


Packet Page 32

I:\2017\2017-211-GWSSOMIDLAND\001-MIDLAND4MILERO27THST\H-DWGS\CIVIL\PS-SHEETSET\SMIDLAND-ROUNDABOUTDETAILS.DWG Plotted: 7/14/2020 3:33 PM By: Ashley Cline

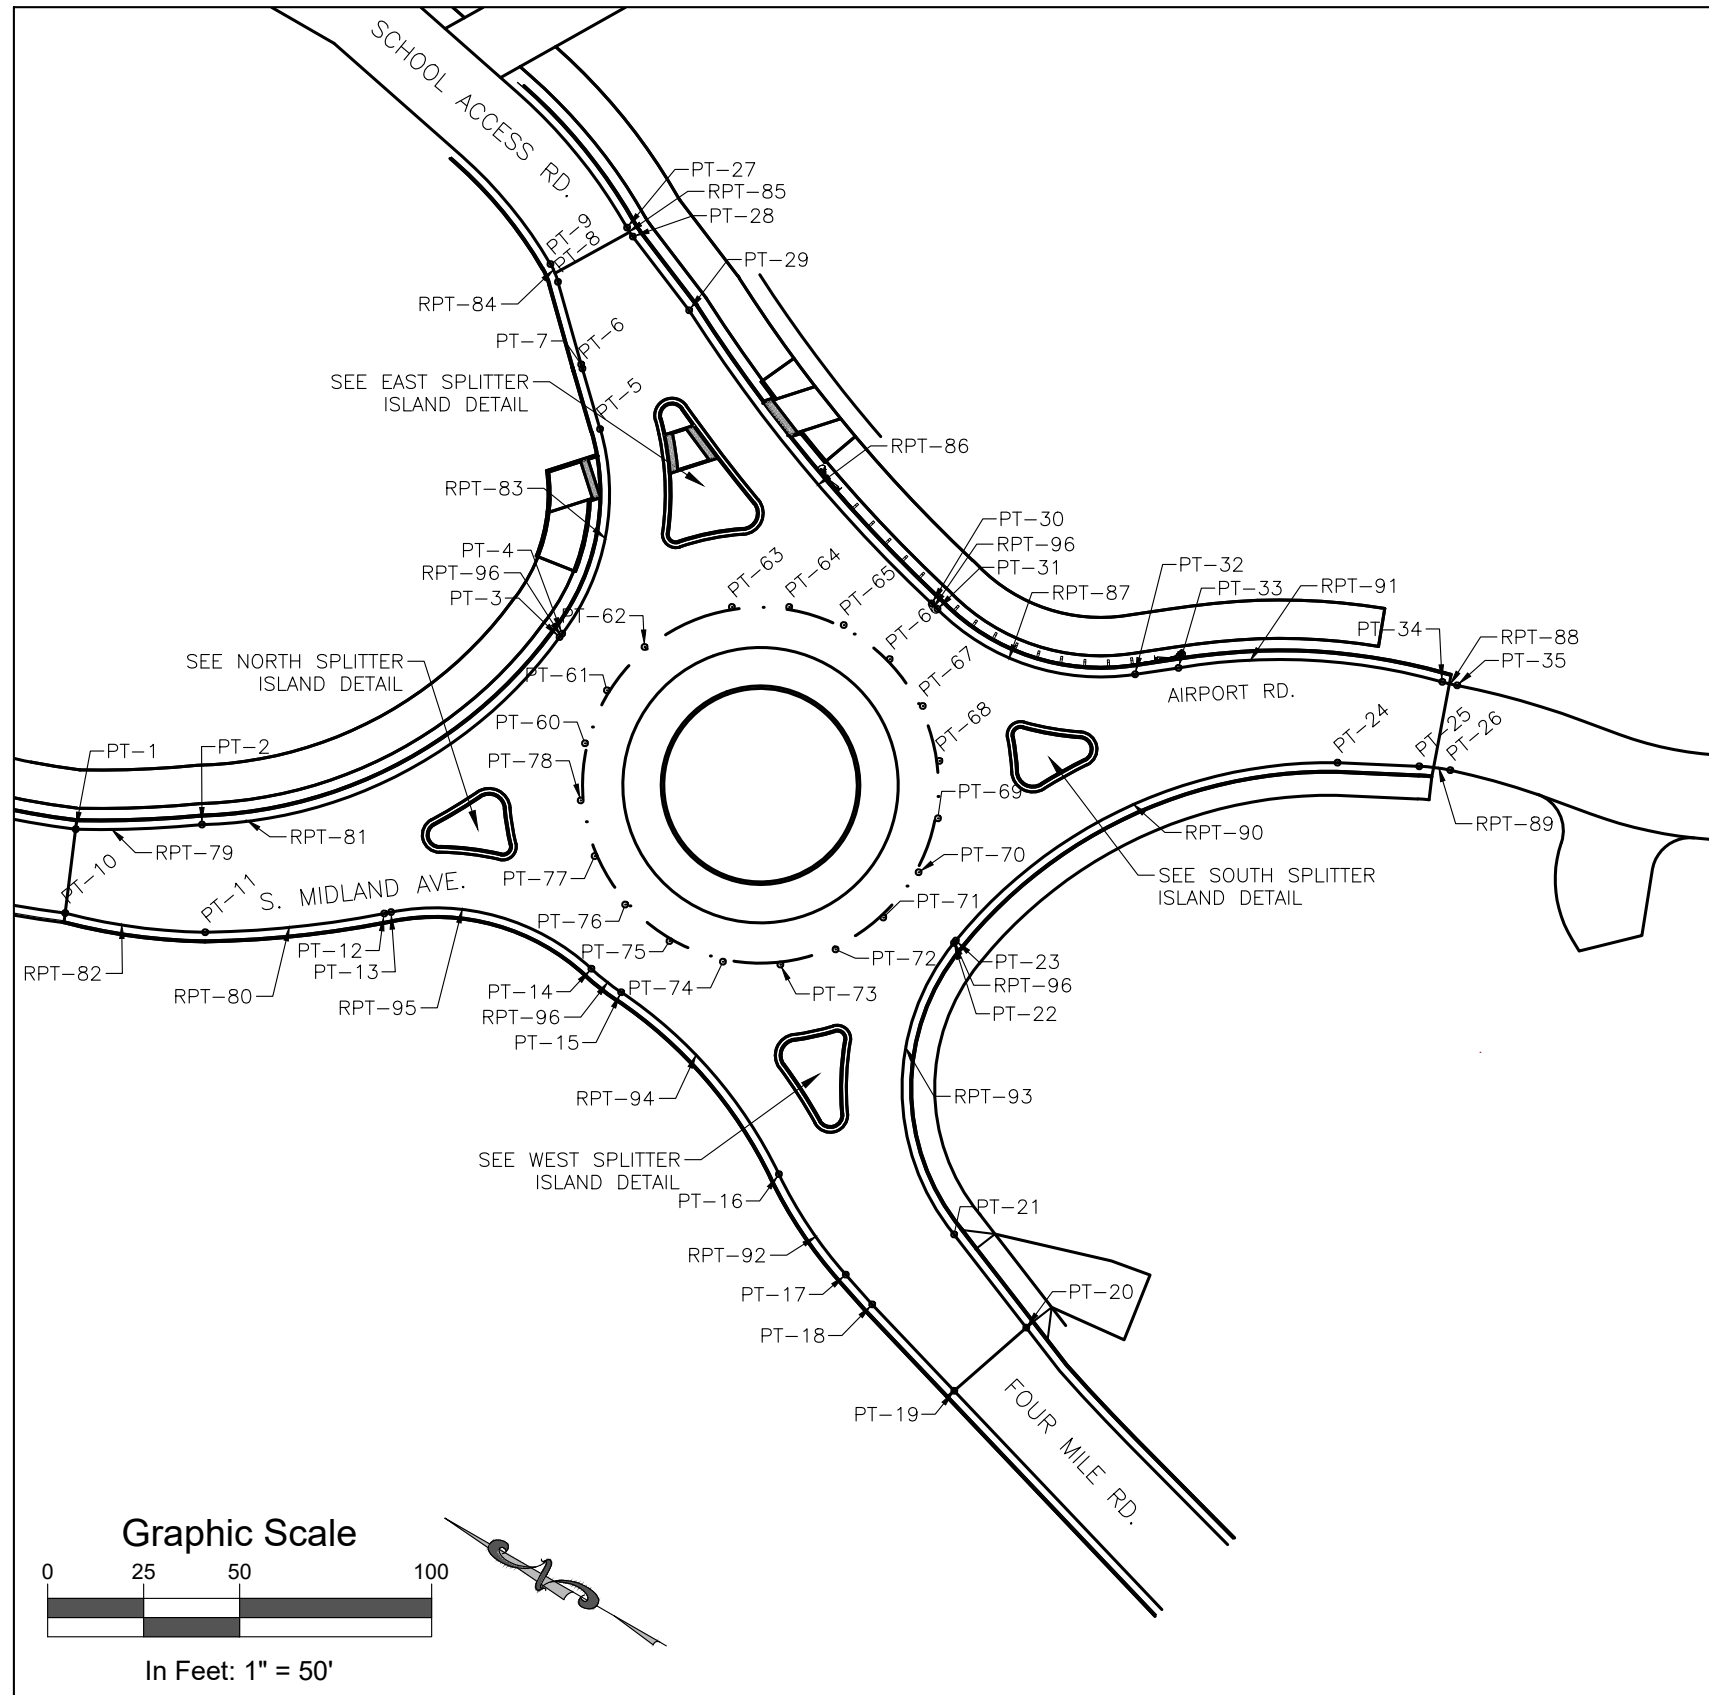


ALL RADII DIMENSIONS ARE MEASURED AT EDGE OF PAVEMENT / LIP OF GUTTER.


RPT = RADIUS POINT

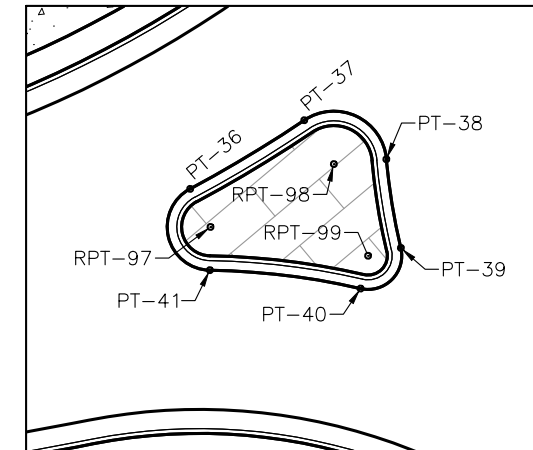


NORTH SPLITTER ISLAND

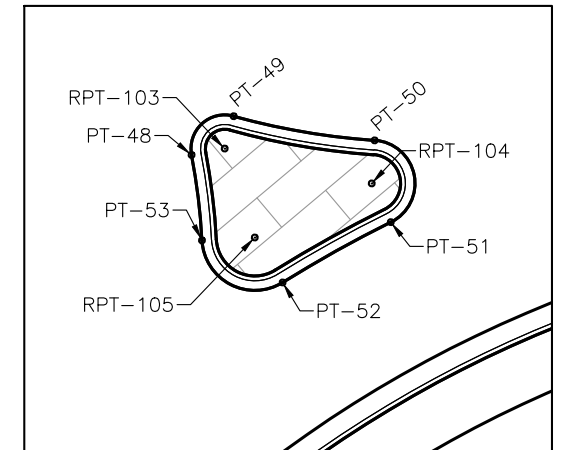

SOUTH SPLITTER ISLAND

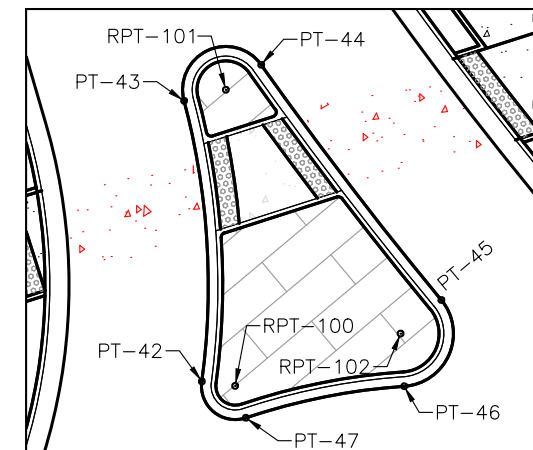

EAST SPLITTER ISLAND

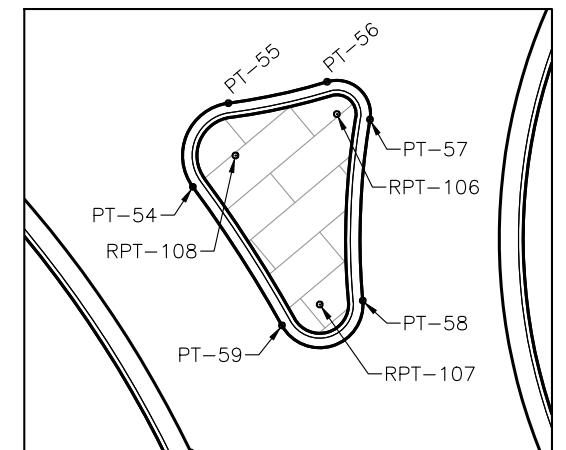

WEST SPLITTER ISLAND


Computer File Information		Sheet Revisions					 118 West Sixth Street, Suite 200 Glenwood Springs, CO 81601 970.945.1004 www.sgm-inc.com	As Constructed		South Midland Ave. Improvements Roundabout Point Data Plan				Project No./Code	
Print Date: 7/14/20		Rev.	Date	Comments	Init.			No Revisions:	-					No.: BUILD M535-006	
Last Modification Date: 4/23/2019		1													
Drawing File Name: SMidland-RoundaboutDetails															
Autocad Ver. 2018 Scale: As Shown Units: English															
SGM Project No.: 2017-211.001 Quality Control: RGN															

I:\2017\2017-211-GWSSOMIDLAND\001-MIDLAND4MILERO27THST\H-DWGS\CIVIL\PS-SHEETSET\SMIDLAND-ROUNDABOUTDETAILS.DWG Plotted: 7/14/2020 3:33 PM By: Ashley Cline


POINT TABLE					POINT TABLE					POINT TABLE				
POINT NO.	ELEVATION	NORTHING	EASTING	DESCRIPTION	POINT NO.	ELEVATION	NORTHING	EASTING	DESCRIPTION	POINT NO.	ELEVATION	NORTHING	EASTING	DESCRIPTION
PT-1	5907.38	26060.76	20922.46	EDGE OF PAVEMENT/LIP OF GUTTER	PT-37	5910.92	26000.95	21008.73	EDGE OF PAVEMENT/LIP OF GUTTER	PT-73	5912.87	25915.83	21040.35	EDGE OF PAVEMENT/LIP OF CURB
PT-2	5908.71	26040.56	20948.44	EDGE OF PAVEMENT/LIP OF GUTTER	PT-38	5911.30	25992.34	21012.67	EDGE OF PAVEMENT/LIP OF GUTTER	PT-74	5912.60	25925.99	21029.40	EDGE OF PAVEMENT/LIP OF CURB
PT-3	5910.56	26018.10	21051.14	EDGE OF PAVEMENT/LIP OF GUTTER	PT-39	5911.42	25984.29	21007.89	EDGE OF PAVEMENT/LIP OF GUTTER	PT-75	5912.33	25939.07	21022.19	EDGE OF PAVEMENT/LIP OF CURB
PT-4	5910.56	26018.35	21052.22	EDGE OF PAVEMENT/LIP OF GUTTER	PT-40	5911.28	25983.75	21001.97	EDGE OF PAVEMENT/LIP OF GUTTER	PT-76	5912.07	25953.75	21019.45	EDGE OF PAVEMENT/LIP OF CURB
PT-5	5909.13	26052.82	21094.05	EDGE OF PAVEMENT/LIP OF GUTTER	PT-41	5911.05	25995.30	20991.16	EDGE OF PAVEMENT/LIP OF GUTTER	PT-77	5911.79	25968.56	21021.46	EDGE OF PAVEMENT/LIP OF CURB
PT-6	5908.13	26067.85	21100.64	EDGE OF PAVEMENT/LIP OF GUTTER	PT-42	5910.07	26021.78	21089.21	EDGE OF PAVEMENT/LIP OF GUTTER	PT-78	5911.53	25981.98	21028.00	EDGE OF PAVEMENT/LIP OF CURB
PT-7	5908.06	26068.89	21101.11	EDGE OF PAVEMENT/LIP OF GUTTER	PT-43	5909.59	26045.35	21106.58	EDGE OF PAVEMENT/LIP OF GUTTER	PT-79	0.00	26266.23	21103.12	RADIUS POINT - 273.60'
PT-8	5906.66	26089.22	21110.29	EDGE OF PAVEMENT/LIP OF GUTTER	PT-44	5909.62	26043.08	21115.14	EDGE OF PAVEMENT/LIP OF GUTTER	PT-80	0.00	26223.36	21097.63	RADIUS POINT - 264'
PT-9	5906.38	26094.05	21111.77	EDGE OF PAVEMENT/LIP OF GUTTER	PT-45	5910.21	26012.25	21113.77	EDGE OF PAVEMENT/LIP OF GUTTER	PT-81	0.00	26132.48	21022.34	RADIUS POINT - 117.95'
PT-10	5907.38	26045.80	20906.33	EDGE OF PAVEMENT/LIP OF GUTTER	PT-46	5910.17	26007.85	21105.03	EDGE OF PAVEMENT/LIP OF GUTTER	PT-82	0.00	26134.07	21031.04	RADIUS POINT - 152.79'
PT-11	5908.85	26018.55	20931.04	EDGE OF PAVEMENT/LIP OF GUTTER	PT-47	5910.03	26015.93	21090.29	EDGE OF PAVEMENT/LIP OF GUTTER	PT-83	0.00	26076.90	21039.09	RADIUS POINT - 60'
PT-12	5910.73	25992.32	20969.88	EDGE OF PAVEMENT/LIP OF GUTTER	PT-48	5911.28	25923.05	21123.66	EDGE OF PAVEMENT/LIP OF GUTTER	PT-84	0.00	26097.45	21092.06	RADIUS POINT - 20'
PT-13	5910.80	25991.43	20971.50	EDGE OF PAVEMENT/LIP OF GUTTER	PT-49	5911.74	25923.33	21129.60	EDGE OF PAVEMENT/LIP OF GUTTER	PT-85	0.00	26084.82	21152.78	RADIUS POINT - 20'
PT-14	5911.79	25946.60	21001.97	EDGE OF PAVEMENT/LIP OF GUTTER	PT-50	5911.98	25911.95	21139.23	EDGE OF PAVEMENT/LIP OF GUTTER	PT-86	0.00	26009.21	21528.26	RADIUS POINT - 400'
PT-15	5911.92	25936.95	21003.97	EDGE OF PAVEMENT/LIP OF GUTTER	PT-51	5911.56	25904.34	21135.05	EDGE OF PAVEMENT/LIP OF GUTTER	PT-87	0.00	25965.54	21190.99	RADIUS POINT - 60'
PT-16	5913.39	25874.25	21004.97	EDGE OF PAVEMENT/LIP OF GUTTER	PT-52	5911.31	25906.78	21122.38	EDGE OF PAVEMENT/LIP OF GUTTER	PT-88	0.00	25889.62	21261.02	RADIUS POINT - 50'
PT-17	5915.06	25843.01	21001.52	EDGE OF PAVEMENT/LIP OF GUTTER	PT-53	5911.38	25915.53	21118.77	EDGE OF PAVEMENT/LIP OF GUTTER	PT-89	0.00	25811.59	21167.20	RADIUS POINT - 50'
PT-18	5915.61	25832.65	21001.81	EDGE OF PAVEMENT/LIP OF GUTTER	PT-54	5912.79	25895.33	21022.89	EDGE OF PAVEMENT/LIP OF GUTTER	PT-90	0.00	25767.83	21103.10	RADIUS POINT - 125.66'
PT-19	5917.11	25801.70	21003.72	EDGE OF PAVEMENT/LIP OF GUTTER	PT-55	5912.53	25899.63	21031.33	EDGE OF PAVEMENT/LIP OF GUTTER	PT-91	0.00	25772.86	21089.94	RADIUS POINT - 157.13'
PT-20	5917.14	25802.24	21028.64	EDGE OF PAVEMENT/LIP OF GUTTER	PT-56	5912.41	25894.72	21040.64	EDGE OF PAVEMENT/LIP OF GUTTER	PT-92	0.00	25846.22	21115.47	RADIUS POINT - 114'
PT-21	5915.70	25832.88	21029.86	EDGE OF PAVEMENT/LIP OF GUTTER	PT-57	5912.69	25888.84	21041.53	EDGE OF PAVEMENT/LIP OF GUTTER	PT-93	0.00	25832.14	21089.86	RADIUS POINT - 60'
PT-22	5911.94	25891.08	21078.62	EDGE OF PAVEMENT/LIP OF GUTTER	PT-58	5913.66	25874.87	21028.83	EDGE OF PAVEMENT/LIP OF GUTTER	PT-94	0.00	25903.75	20888.66	RADIUS POINT - 120'
PT-23	5911.94	25891.23	21079.39	EDGE OF PAVEMENT/LIP OF GUTTER	PT-59	5913.40	25878.31	21020.73	EDGE OF PAVEMENT/LIP OF GUTTER	PT-95	0.00	25938.92	20942.47	RADIUS POINT - 60'
PT-24	5913.01	25862.86	21185.31	EDGE OF PAVEMENT/LIP OF GUTTER	PT-60	5911.26	25992.67	21038.43	EDGE OF PAVEMENT/LIP OF CURB	PT-96	0.00	25954.93	21066.44	RADIUS POINT - 65'
PT-25	5913.54	25848.43	21201.01	EDGE OF PAVEMENT/LIP OF GUTTER	PT-61	5910.99	25999.55	21051.69	EDGE OF PAVEMENT/LIP OF CURB	PT-97	0.00	25998.71	20994.11	RADIUS POINT - 4.5'
PT-26	5913.75	25842.45	21206.54	EDGE OF PAVEMENT/LIP OF GUTTER	PT-62	5910.72	26001.93	21066.44	EDGE OF PAVEMENT/LIP OF CURB	PT-98	0.00	25995.48	21008.16	RADIUS POINT - 5.5'
PT-27	5906.47	26088.49	21133.13	EDGE OF PAVEMENT/LIP OF GUTTER	PT-63	5910.45	25995.28	21090.54	EDGE OF PAVEMENT/LIP OF CURB	PT-99	0.00	25985.86	21004.76	RADIUS POINT - 3.5'
PT-28	5906.62	26085.73	21132.81	EDGE OF PAVEMENT/LIP OF GUTTER	PT-64	5910.70	25985.68	21101.98	EDGE OF PAVEMENT/LIP OF CURB	PT-100	0.00	26019.19	21091.57	RADIUS POINT - 3.5'
PT-29	5908.11	26061.60	21131.70	EDGE OF PAVEMENT/LIP OF GUTTER	PT-65	5910.94	25972.97	21109.84	EDGE OF PAVEMENT/LIP OF CURB	PT-101	0.00	26043.44	21110.66	RADIUS POINT - 4.5'
PT-30	5910.80	25962.52	21130.99	EDGE OF PAVEMENT/LIP OF GUTTER	PT-66	5911.19	25958.44	21113.31	EDGE OF PAVEMENT/LIP OF CURB	PT-102	0.00	26012.30	21108.27	RADIUS POINT - 5.5'
PT-31	5910.82	25960.44	21131.20	EDGE OF PAVEMENT/LIP OF GUTTER	PT-67	5911.43	25943.56	21112.04	EDGE OF PAVEMENT/LIP OF CURB	PT-103	0.00	25921.35	21126.71	RADIUS POINT - 3.5'
PT-32	5911.54	25914.34	21159.70	EDGE OF PAVEMENT/LIP OF GUTTER	PT-68	5911.68	25929.82	21106.17	EDGE OF PAVEMENT/LIP OF CURB	PT-104	0.00	25908.71	21136.11	RADIUS POINT - 4.5'
PT-33	5911.83	25908.39	21169.43	EDGE OF PAVEMENT/LIP OF GUTTER	PT-69	5911.92	25918.62	21096.29	EDGE OF PAVEMENT/LIP OF CURB	PT-105	0.00	25912.22	21123.16	RADIUS POINT - 5.5'
PT-34	5913.59	25861.44	21219.72	EDGE OF PAVEMENT/LIP OF GUTTER	PT-70	5912.17	25911.09	21083.39	EDGE OF PAVEMENT/LIP OF CURB	PT-106	0.00	25891.50	21039.26	RADIUS POINT - 3.5'
PT-35	5913.70	25858.24	21222.10	EDGE OF PAVEMENT/LIP OF GUTTER	PT-71	5912.41	25907.99	21068.78	EDGE OF PAVEMENT/LIP OF CURB	PT-107	0.00	25877.45	21025.15	RADIUS POINT - 4.5'
										PT-108	0.00	25894.99	21028.38	RADIUS POINT - 5.5'

Computer File Information		Sheet Revisions					 118 West Sixth Street, Suite 200 Glenwood Springs, CO 81601 970.945.1004 www.sgm-inc.com	As Constructed		South Midland Ave. Improvements Roundabout Point Data Table			Project No./Code	
Print Date: 7/14/20		Rev.	Date	Comments	Init.			No Revisions: -		Engineer: MDF Structure --- Drawn By: AMC Numbers --- Sheet Subset: RDWY Subset Sheets: 27 of 45			No.: BUILD M535-006	
Last Modification Date: 4/23/2019		☒						Revised: -						
Drawing File Name: SMidland-RoundaboutDetails		☐						Void: -		Sheet Number: 71				
Autocad Ver. 2018 Scale: As Shown Units: English		☐												
SGM Project No.: 2017-211.001 Quality Control: RGN		☐												


I:\2017\2017-211-GWSSMIDLAND\001-MIDLAND4MILERO27THST\H-DWGS\CIVIL\PS-SHEETSET\MIDLAND-INTERSECTIONDETAILS.DWG Plotted: 7/14/2020 3:34 PM By: Ashley Cline

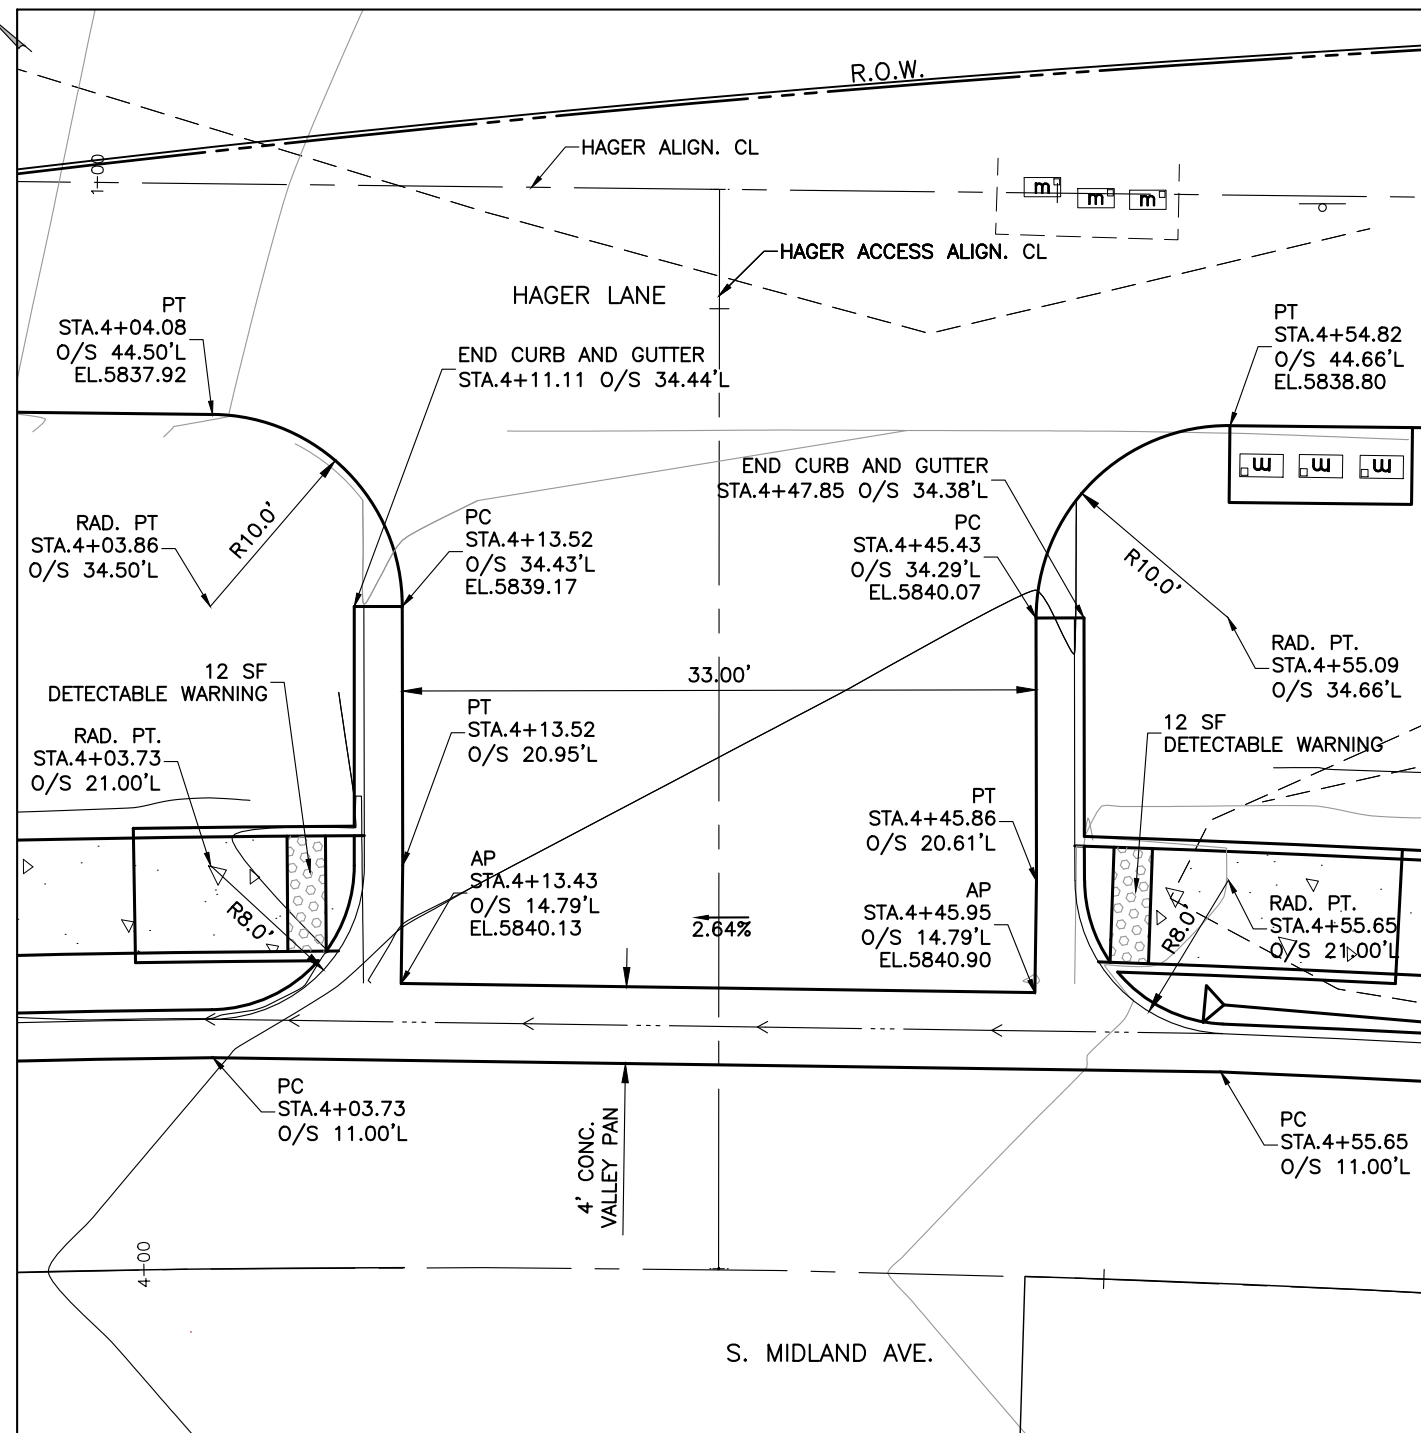

HAGER LANE INTERSECTION
SCALE: 1" = 10'

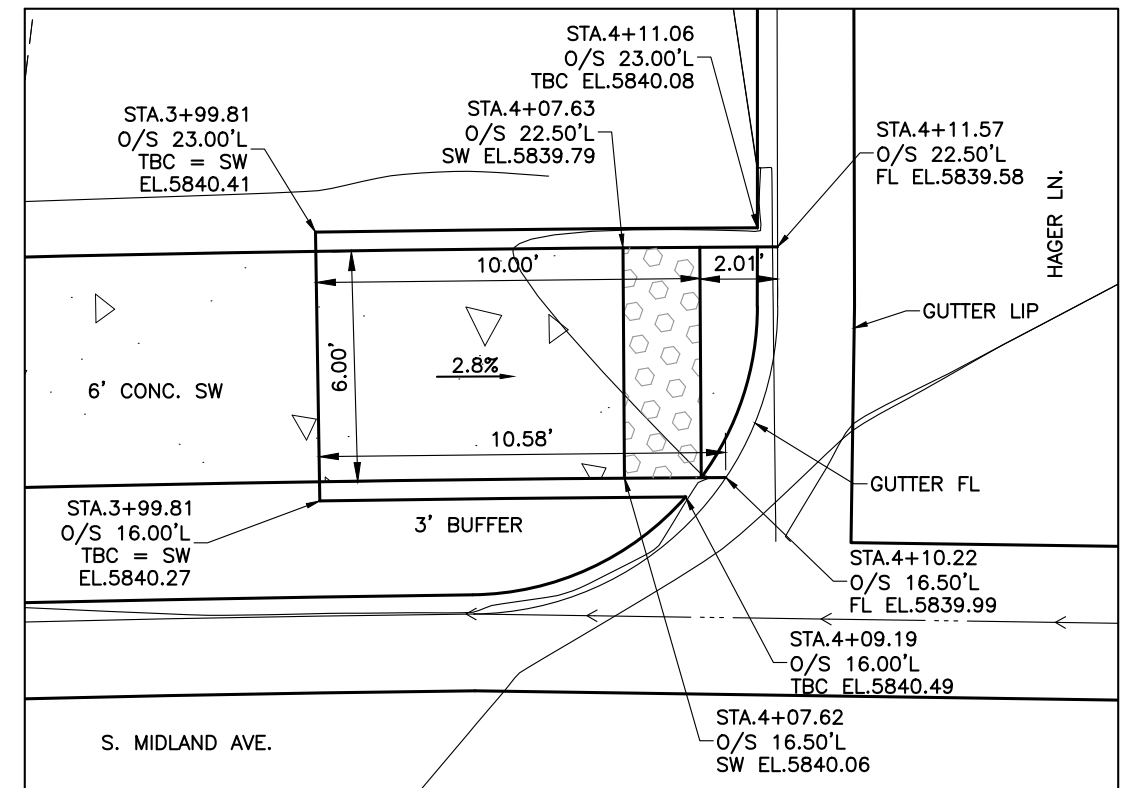




HAGER LANE CURB RAMP - NORTH
CDOT TYPE 2
SCALE: 1" = 5'

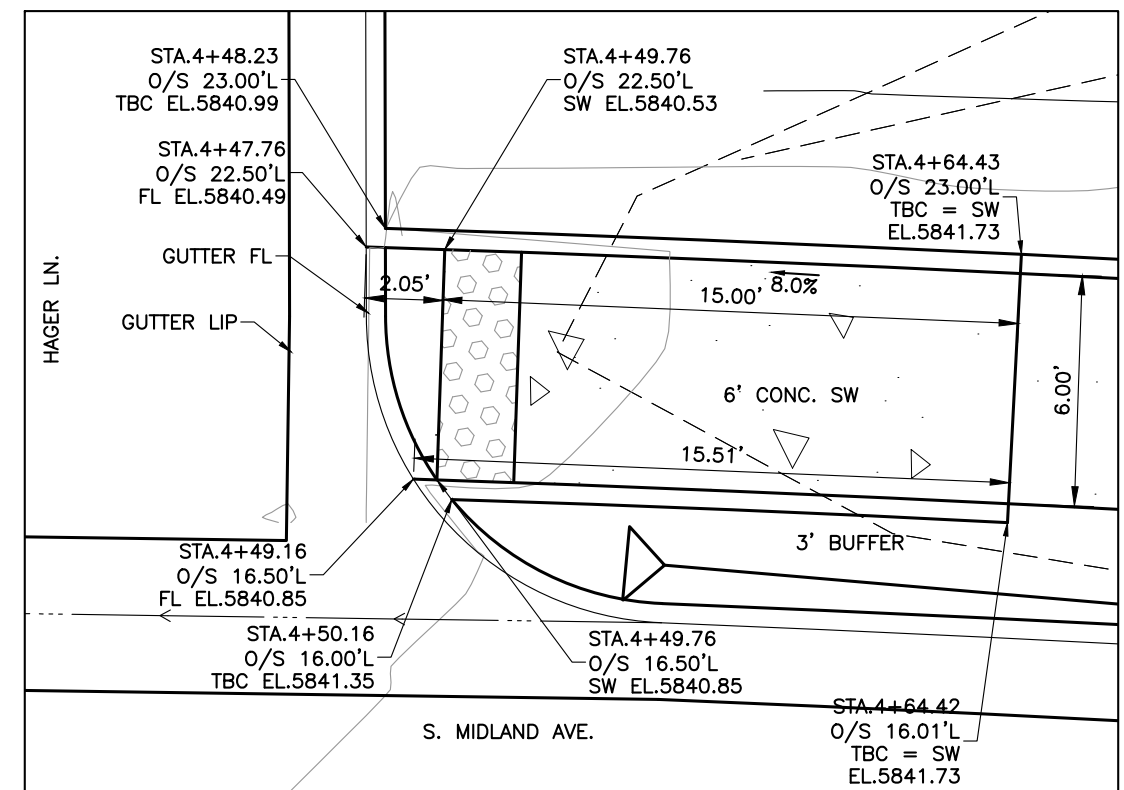

HAGER LANE CURB RAMP - SOUTH
CDOT TYPE 2
SCALE: 1" = 5'


Computer File Information		Sheet Revisions				As Constructed		South Midland Ave. Improvements Hager Lane Intersection			Project No./Code	
Print Date: 7/14/20		Rev.	Date	Comments	Init.	No Revisions:	-				No.:	BUILD M535-006
Last Modification Date: 4/23/2019		1				Revised:	-	Engineer:	MDF	Structure		Code: 22933
Drawing File Name: SMidland-IntersectionDetails						Void:	-	Drawn By:	AMC	Numbers		
Autocad Ver. 2018 Scale: As Shown Units: English								Sheet Subset:	RDWY	Subset Sheets:	28 of 45	Sheet Number: 72
SGM Project No.: 2017-211.001 Quality Control: RGN												



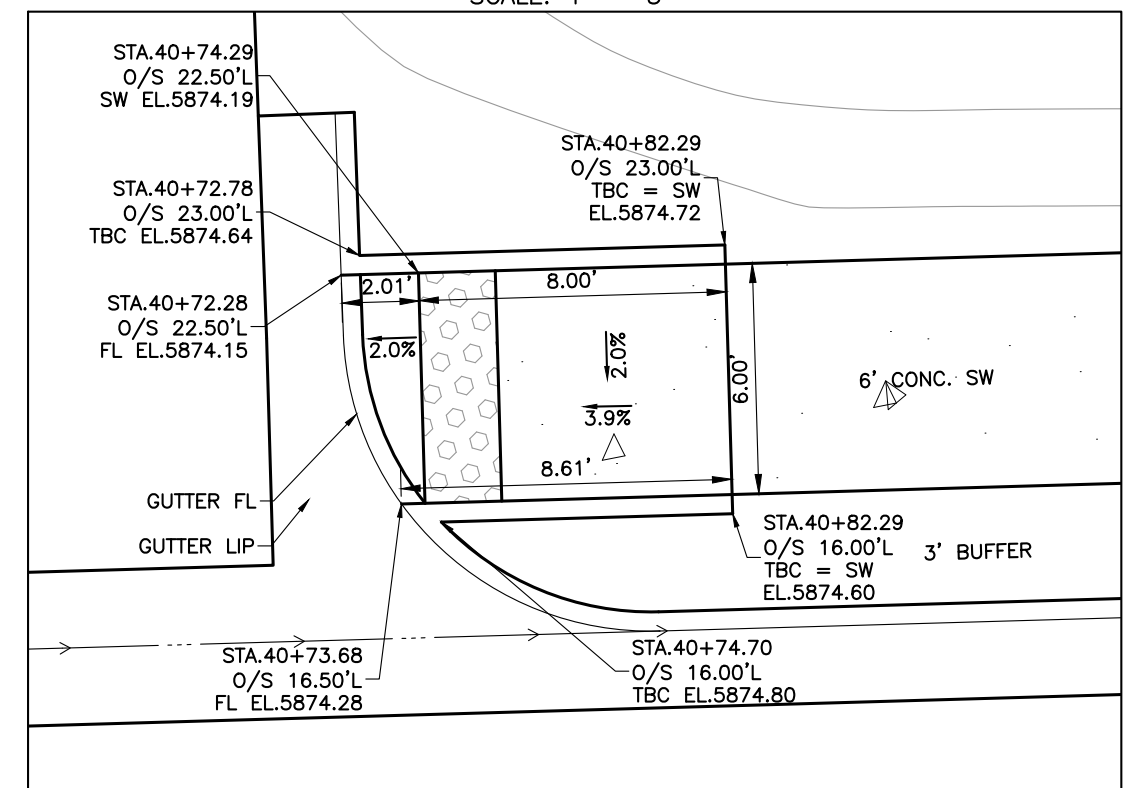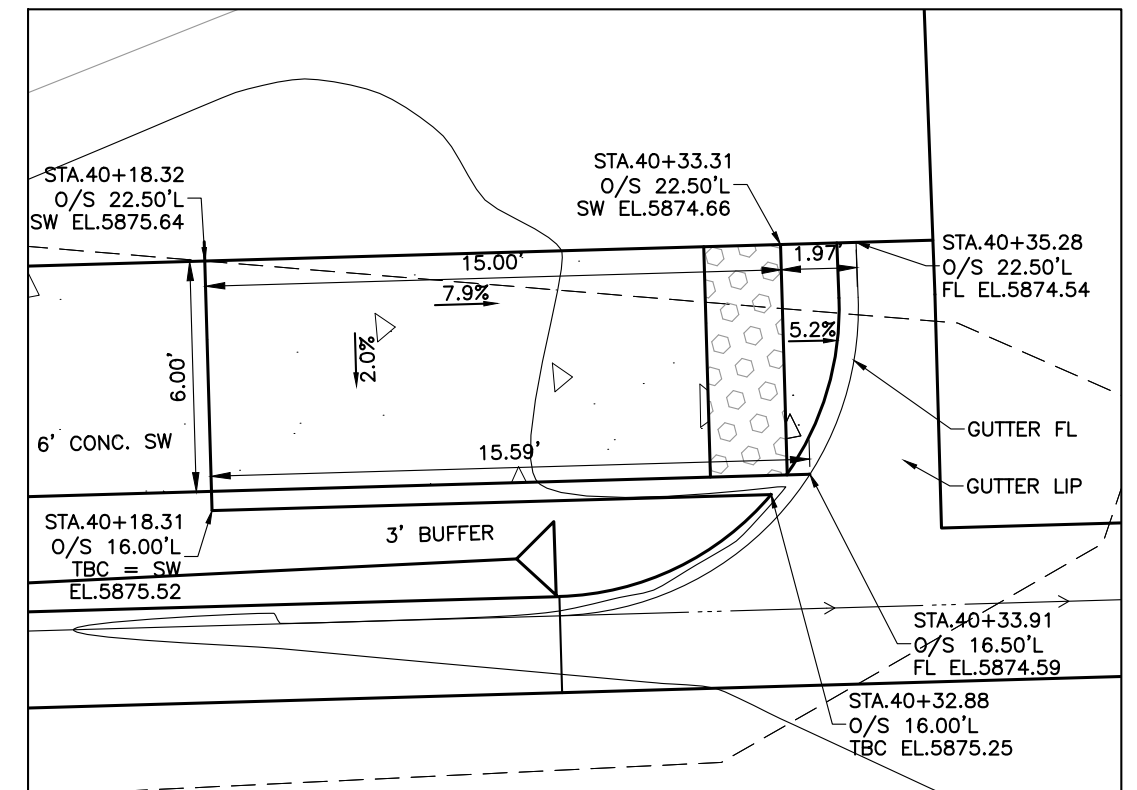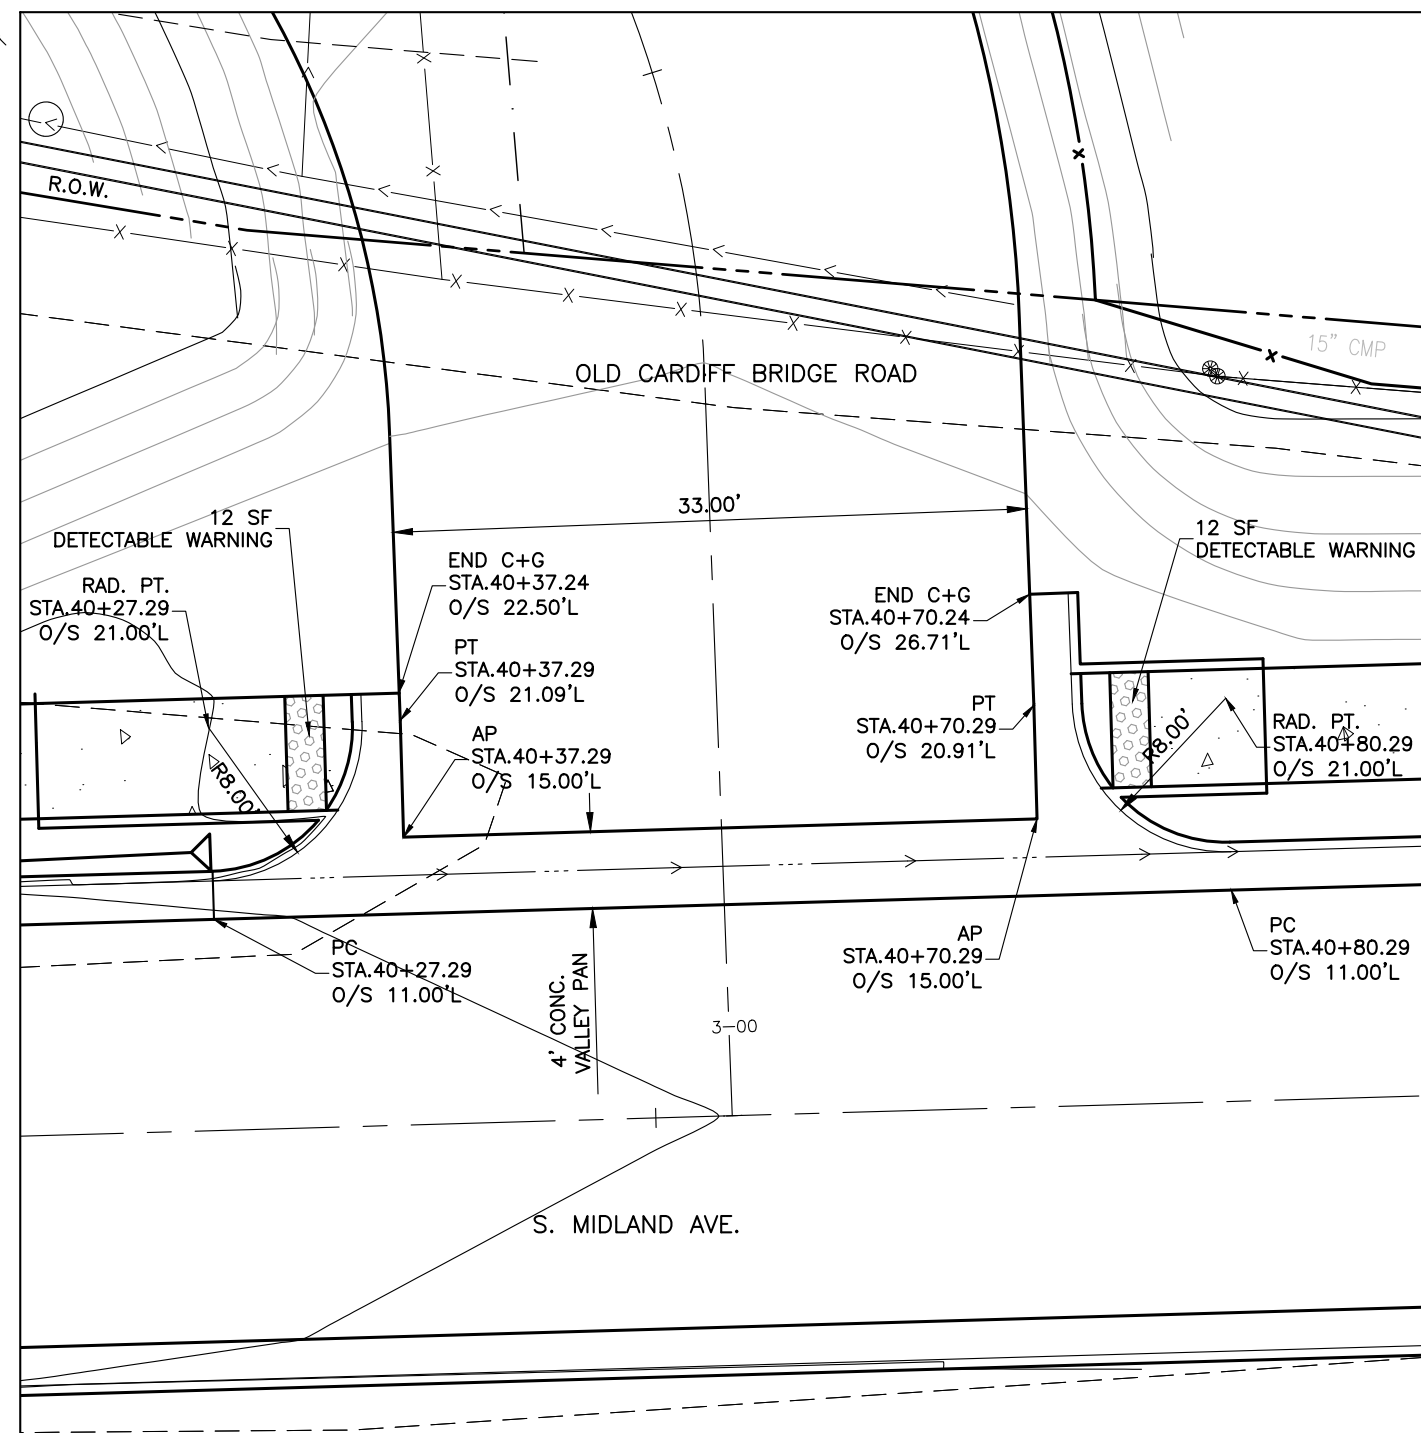


Computer File Information		Sheet Revisions					 118 West Sixth Street, Suite 200 Glenwood Springs, CO 81601 970.945.1004 www.sgm-inc.com	As Constructed		South Midland Ave. Improvements Old Cardiff Bridge Road Intersection			Project No./Code		
Print Date: 7/14/20		Rev.	Date	Comments	Init.			No Revisions:	-					No.: BUILD M535-006	
Last Modification Date: 4/23/2019		1													
Drawing File Name: SMidland-IntersectionDetails															
Autocad Ver. 2018 Scale: As Shown Units: English															
SGM Project No.: 2017-211.001 Quality Control: RGN															
							Revised:	-	Engineer:	MDF	Structure	---	Code: 22933		
							Void:	-	Drawn By:	AMC	Numbers	---	Sheet Number: 73		
									Sheet Subset:	RDWY	Subset Sheets:	29 of 45			


I:\2017\2017-211-GWSSOMIDLAND\001-MIDLAND4MILERO27THST\H-DWGS\CIVIL\PS-SHEETSET\SMIDLAND-INTERSECTIONDETAILS.DWG Plotted: 7/14/2020 3:35 PM By: Ashley Cline

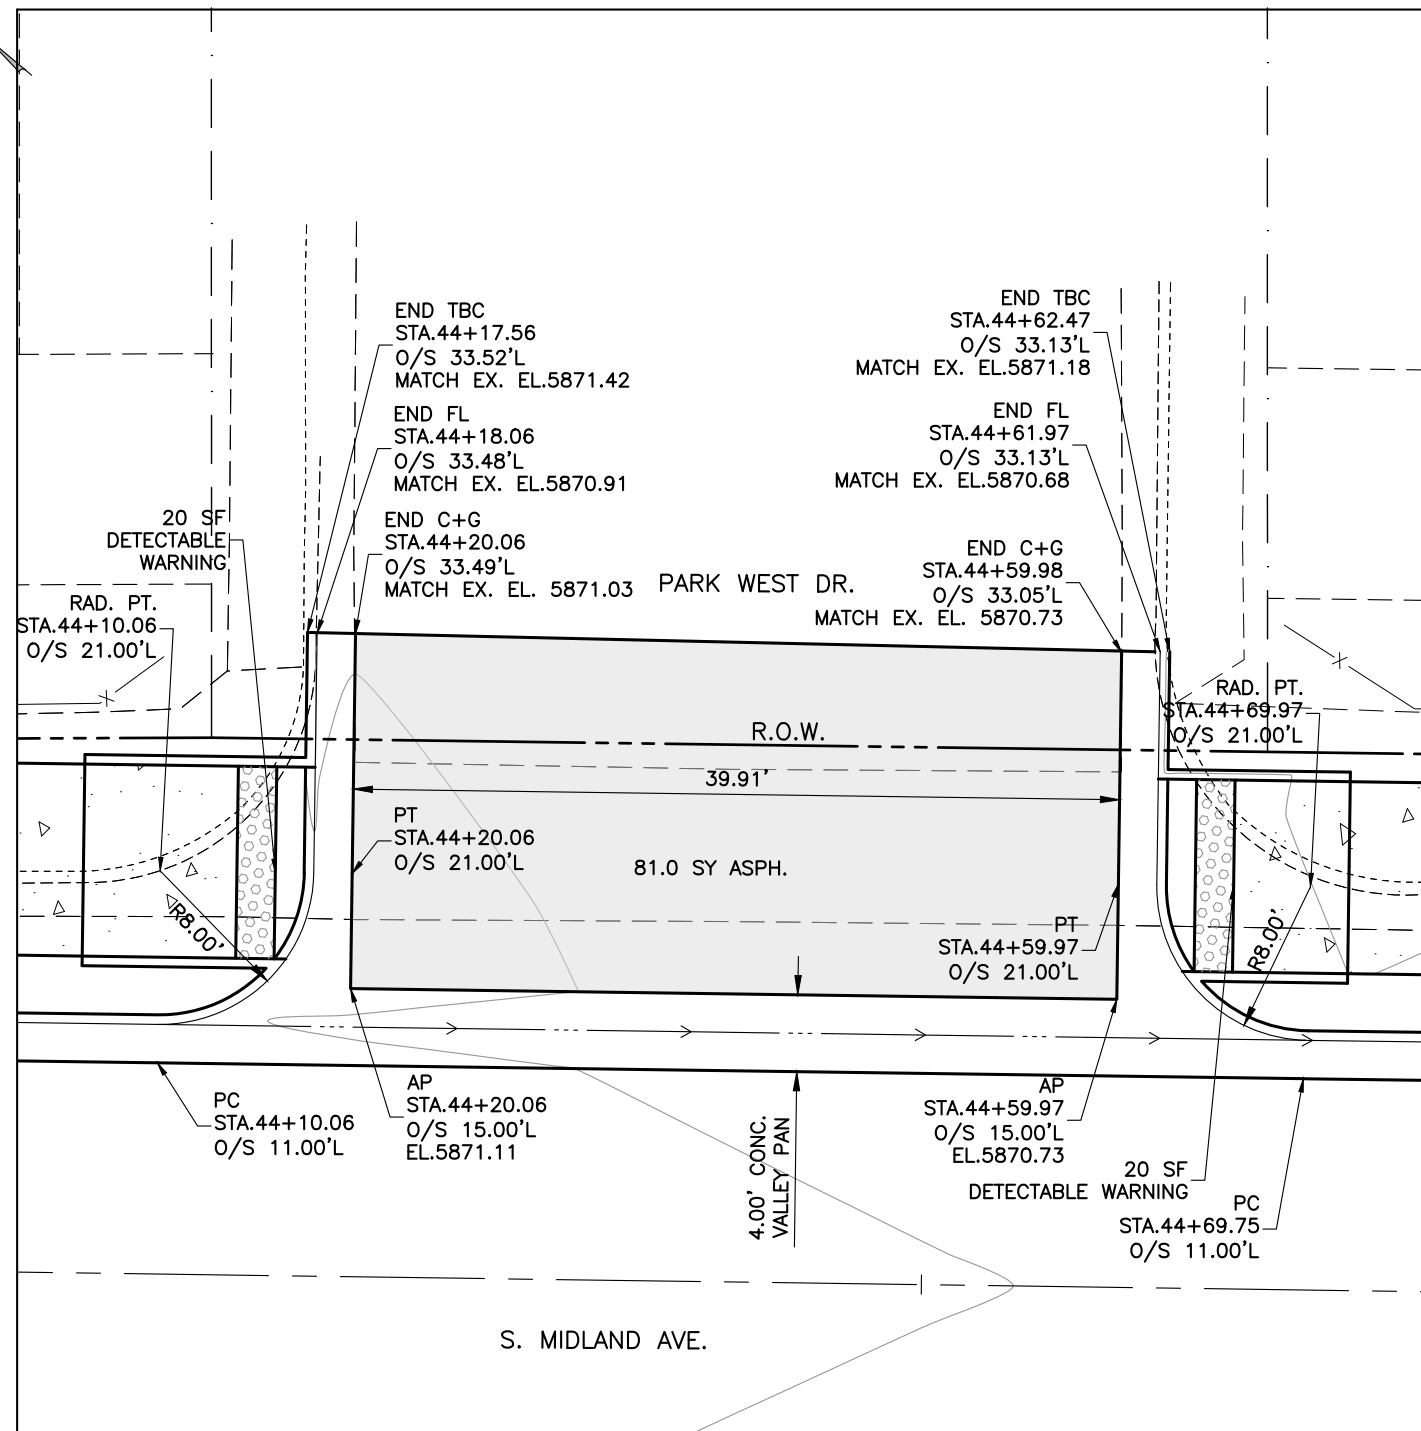

PARK WEST INTERSECTION (NORTH ENTRANCE)
SCALE: 1" = 10'

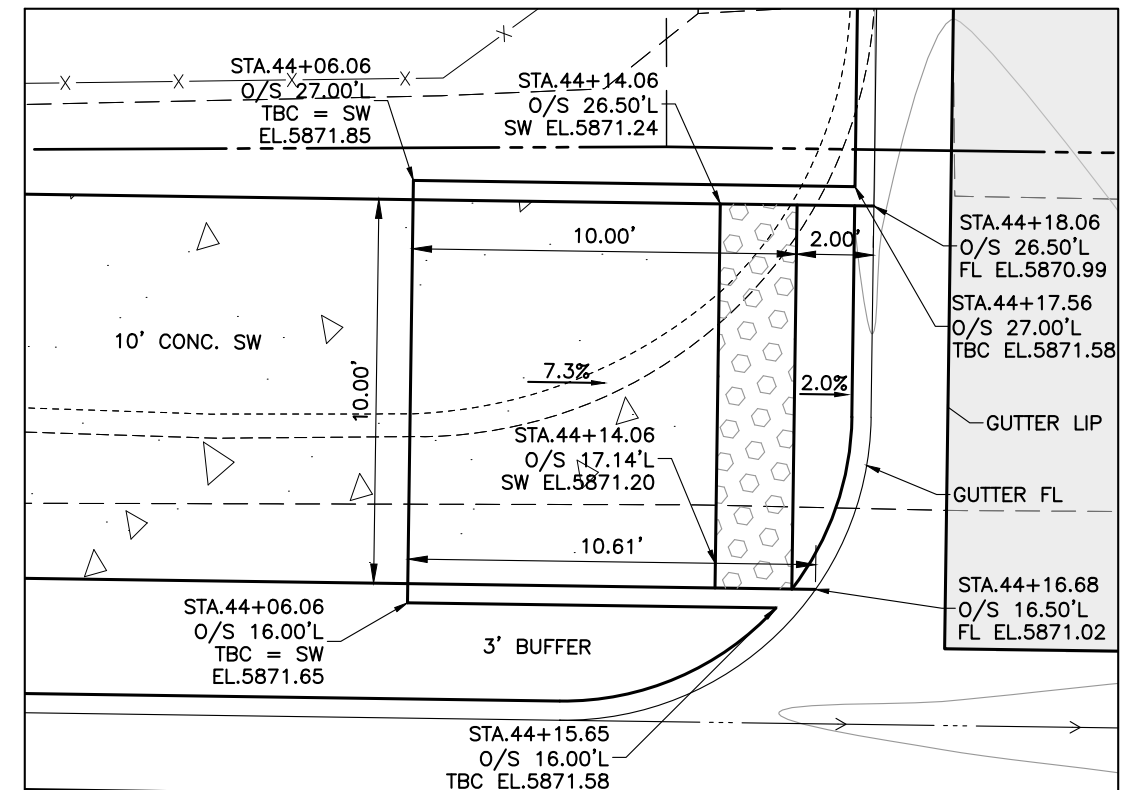

PARK WEST CURB RAMP - NORTH 1
CDOT TYPE 2
SCALE: 1" = 5'

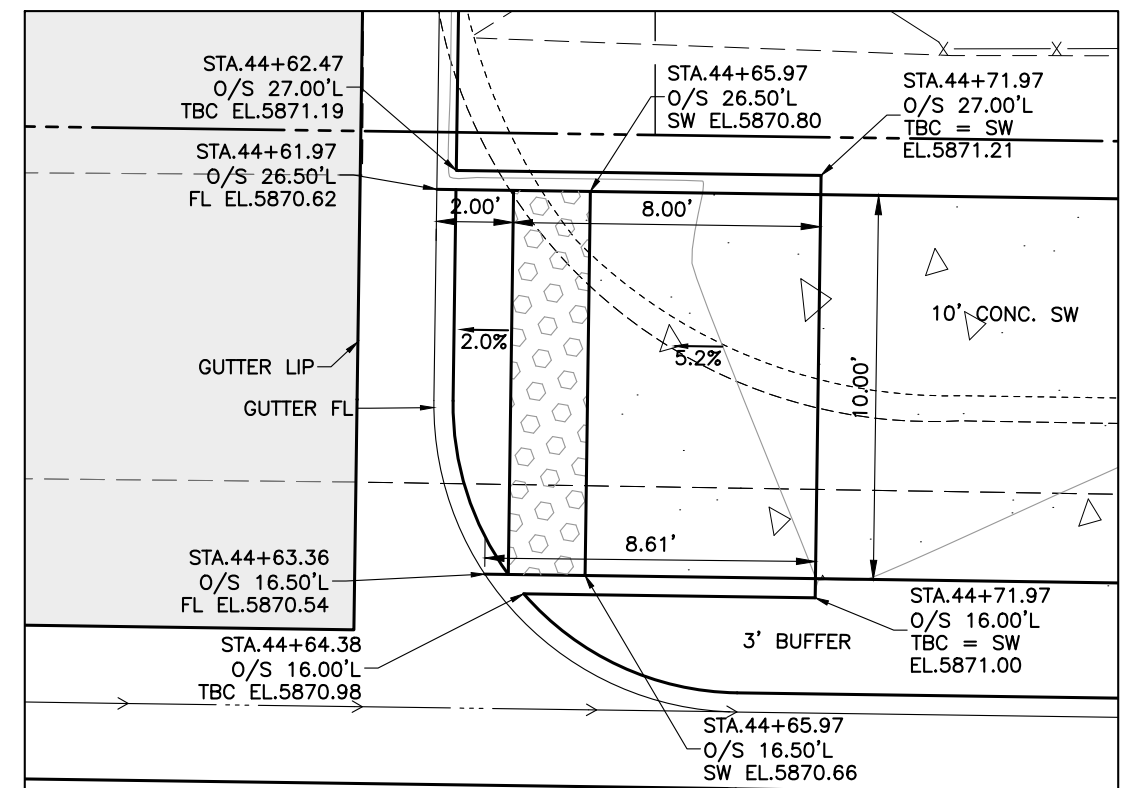


PARK WEST CURB RAMP - NORTH 2
CDOT TYPE 2
SCALE: 1" = 5'


Computer File Information		Sheet Revisions				As Constructed		South Midland Ave. Improvements Park West Drive North Intersection			Project No./Code	
Print Date: 7/14/20	Last Modification Date: 4/23/2019	Rev.	Date	Comments	Init.						No.: BUILD M535-006	
Drawing File Name: SMidland-IntersectionDetails		1				No Revisions:	-	Engineer: MDF	Structure	---	Code: 22933	
Autocad Ver. 2018	Scale: As Shown					Revised:	-	Drawn By: AMC	Numbers	---		
SGM Project No.: 2017-211.001	Quality Control: RGN					Void:	-	Sheet Subset: RDWY	Subset Sheets:	30 of 45	Sheet Number: 74	




I:\2017\2017-211-GWSSMIDLAND\001-MIDLAND4MILE RD27TH ST-H-DWGS\CIVIL\PS-SHEETSET\MIDLAND-INTERSECTIONDETAILS.DWG Plotted: 7/14/2020 3:36 PM By: Ashley Cline

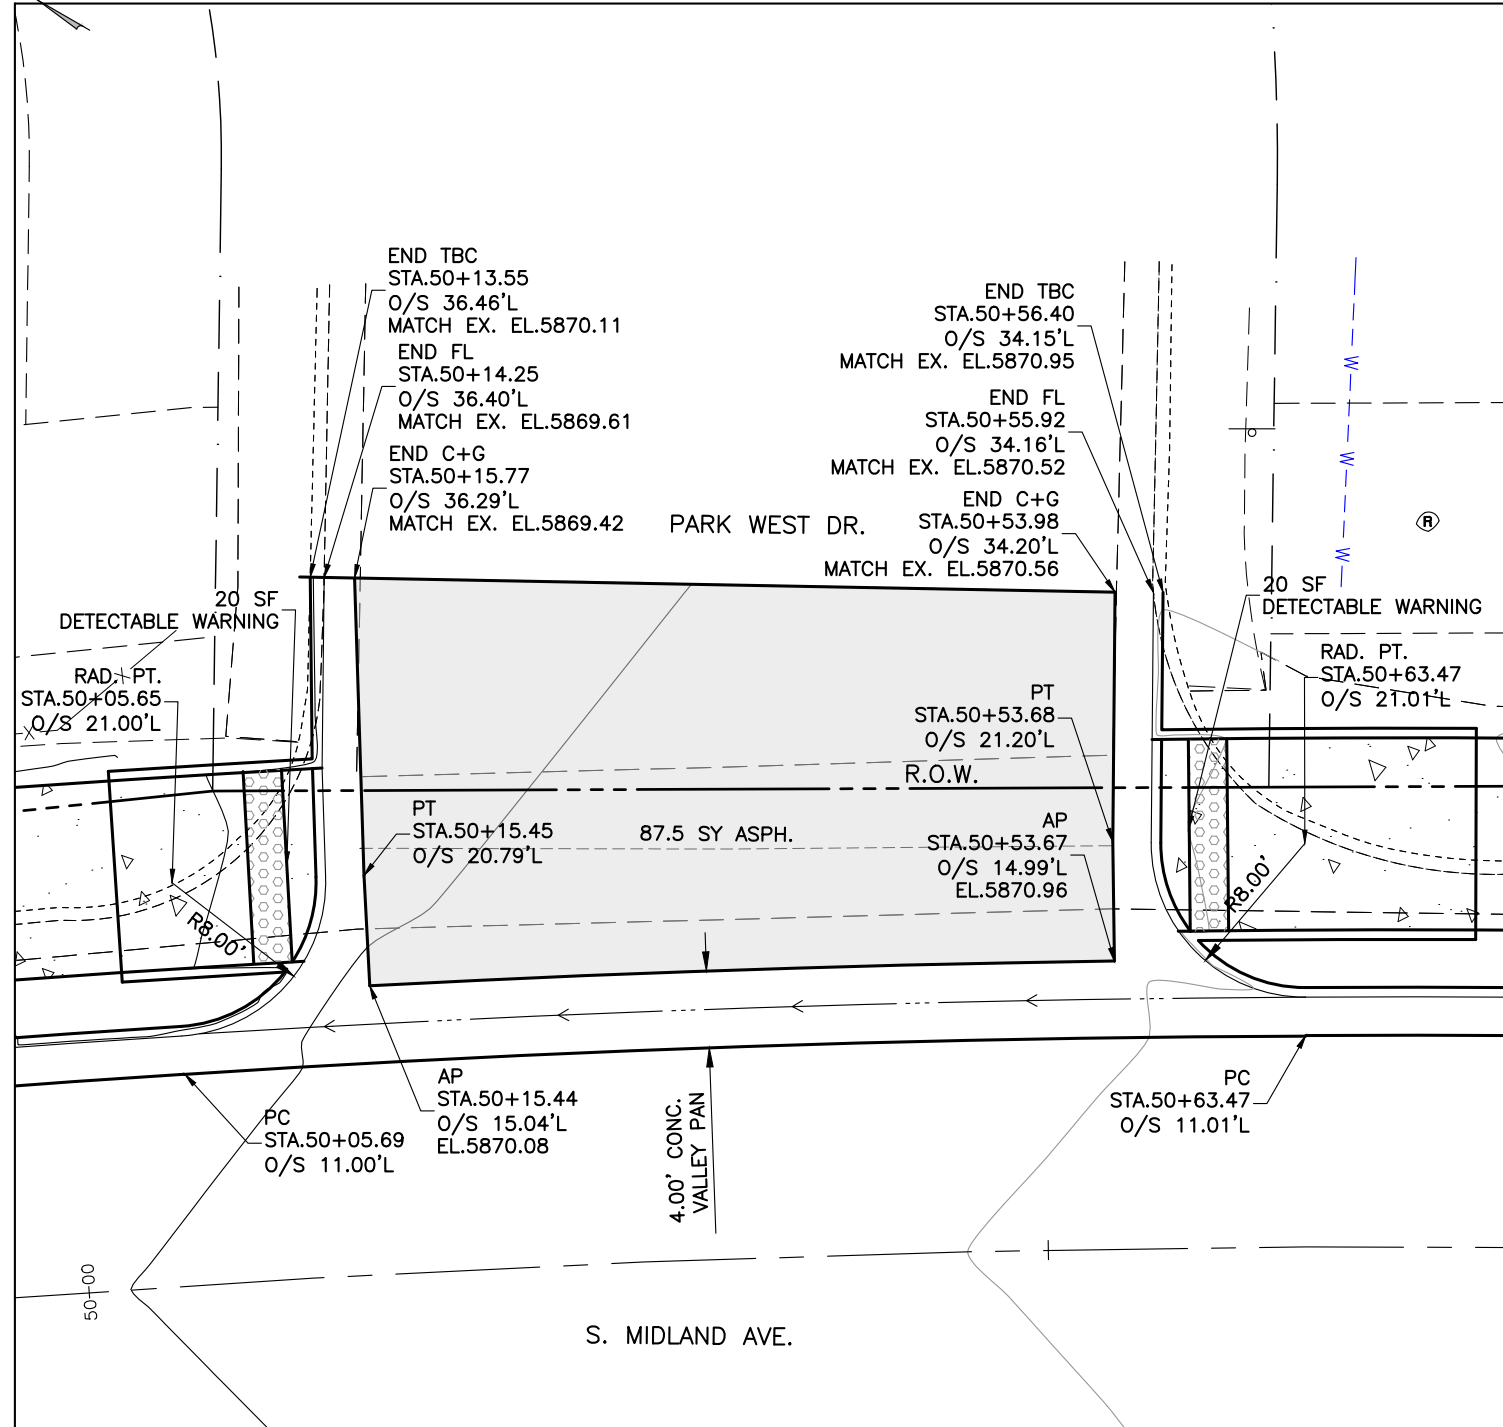

PARK WEST INTERSECTION (SOUTH ENTRANCE)
SCALE: 1" = 10'

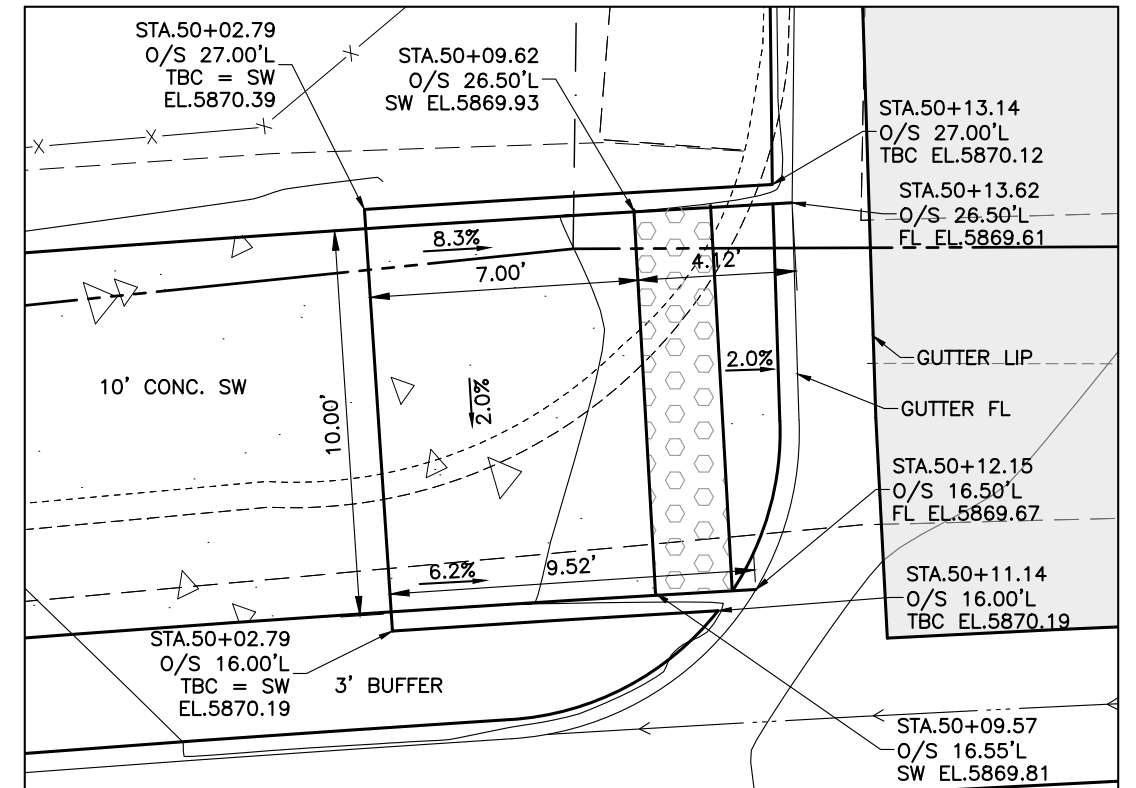

PARK WEST CURB RAMP - SOUTH 1
CDOT TYPE 2
SCALE: 1" = 5'

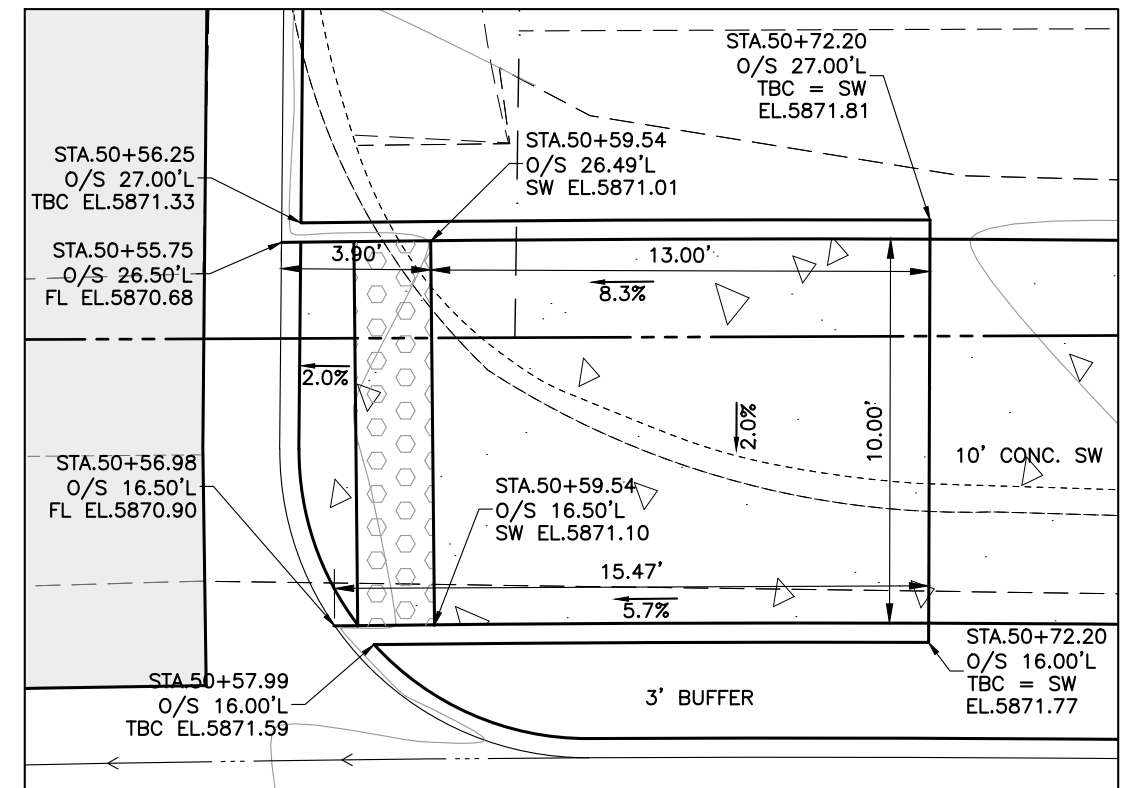

PARK WEST CURB RAMP - SOUTH 2
CDOT TYPE 2
SCALE: 1" = 5'

Computer File Information		Sheet Revisions				As Constructed		South Midland Ave. Improvements Park West Drive South Intersection			Project No./Code	
Print Date: 7/14/20	Last Modification Date: 4/23/2019	Rev.	Date	Comments	Init.						No.: BUILD M535-006	No.: 22933
Drawing File Name: SMidland-IntersectionDetails		1				No Revisions:	-	Engineer: MDF	Structure	---	Code: 22933	Sheet Number: 75
Autocad Ver. 2018	Scale: As Shown					Revised:	-	Drawn By: AMC	Numbers	---		
SGM Project No.: 2017-211.001	Quality Control: RGN					Void:	-	Sheet Subset: RDWY	Subset Sheets:	31 of 45		




GLENWOOD
SPRINGS
COLORADO




118 West Sixth Street, Suite 200
Glenwood Springs, CO 81601
970.945.1004 www.sgm-inc.com


I:\2017\2017-211-GWSSOMIDLAND\001-MIDLAND4MILRD27THST\H-DWGS\CIVIL\PS-SHEETSET\SMIDLAND-INTERSECTIONDETAILS.DWG Plotted: 7/14/2020 3:37 PM By: Ashley Cline

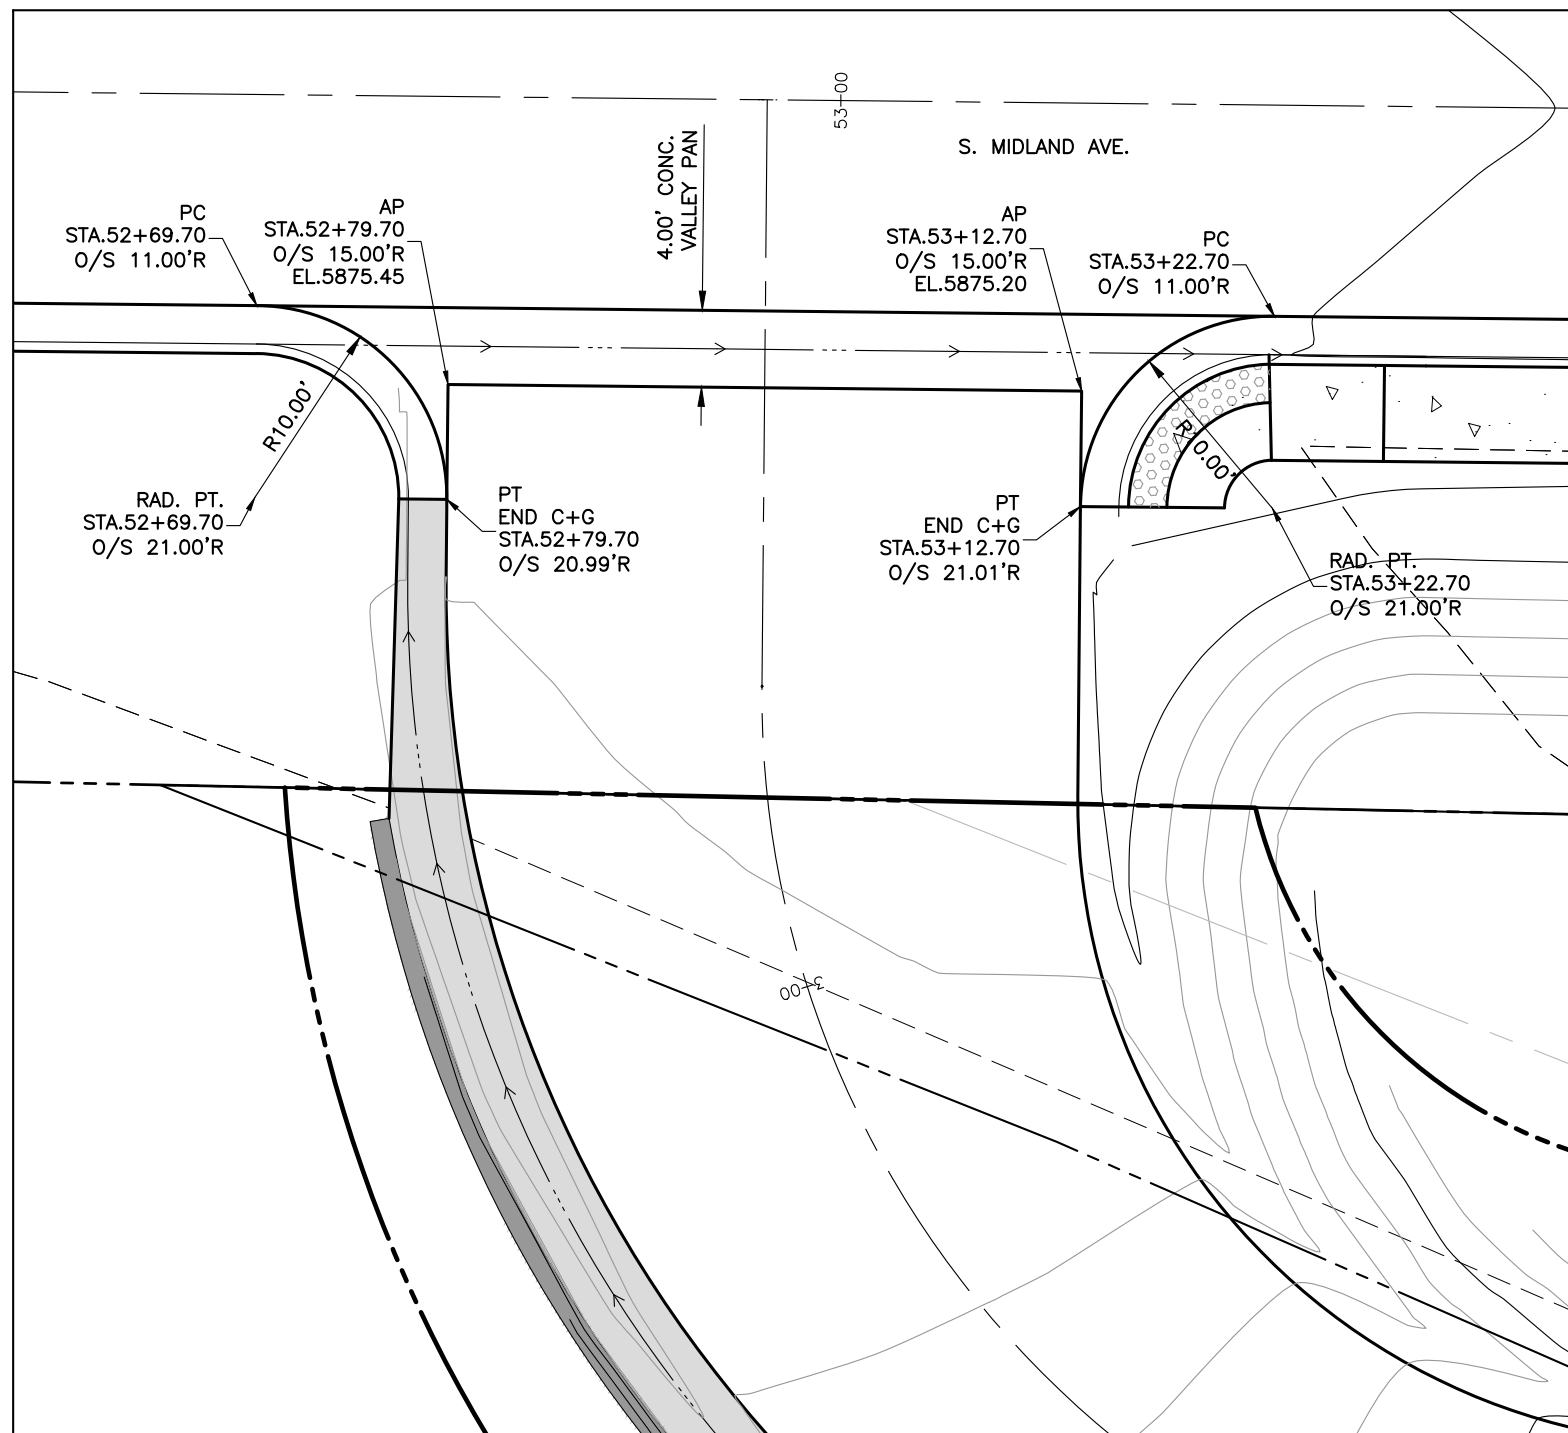

THREE MILE ROAD INTERSECTION
SCALE: 1" = 10'

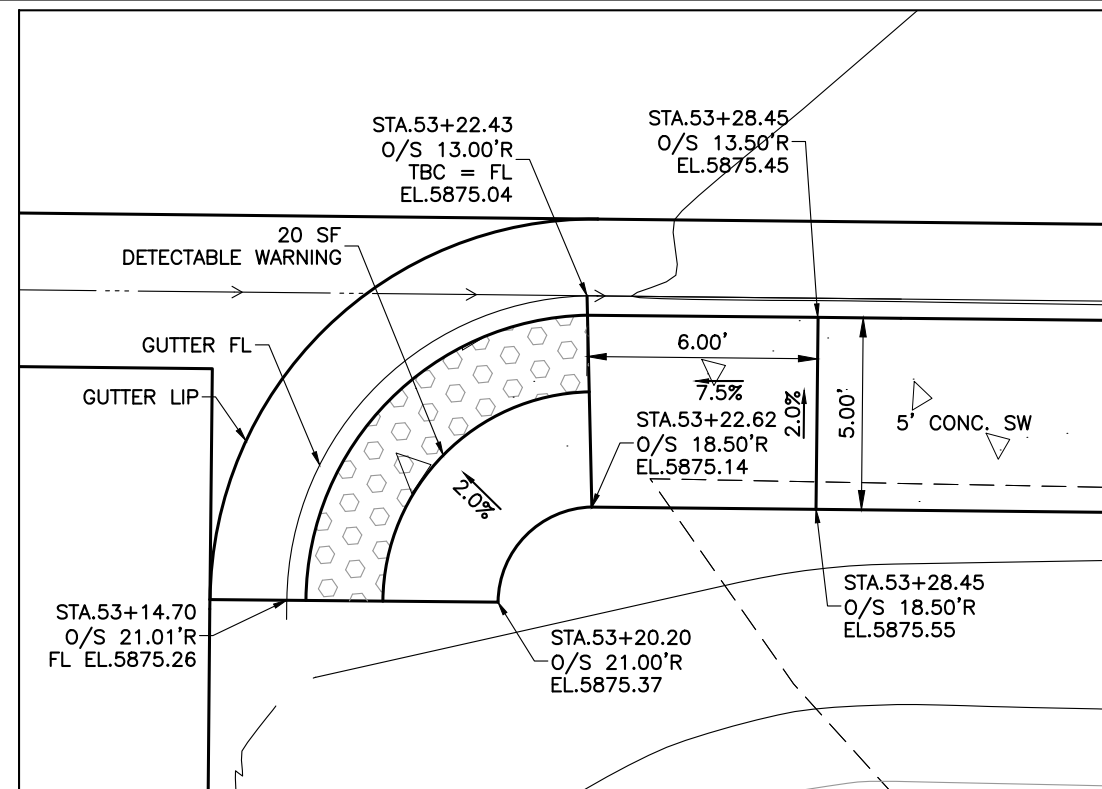

THREE MILE ROAD CURB RAMP
CDOT TYPE 2
SCALE: 1" = 5'

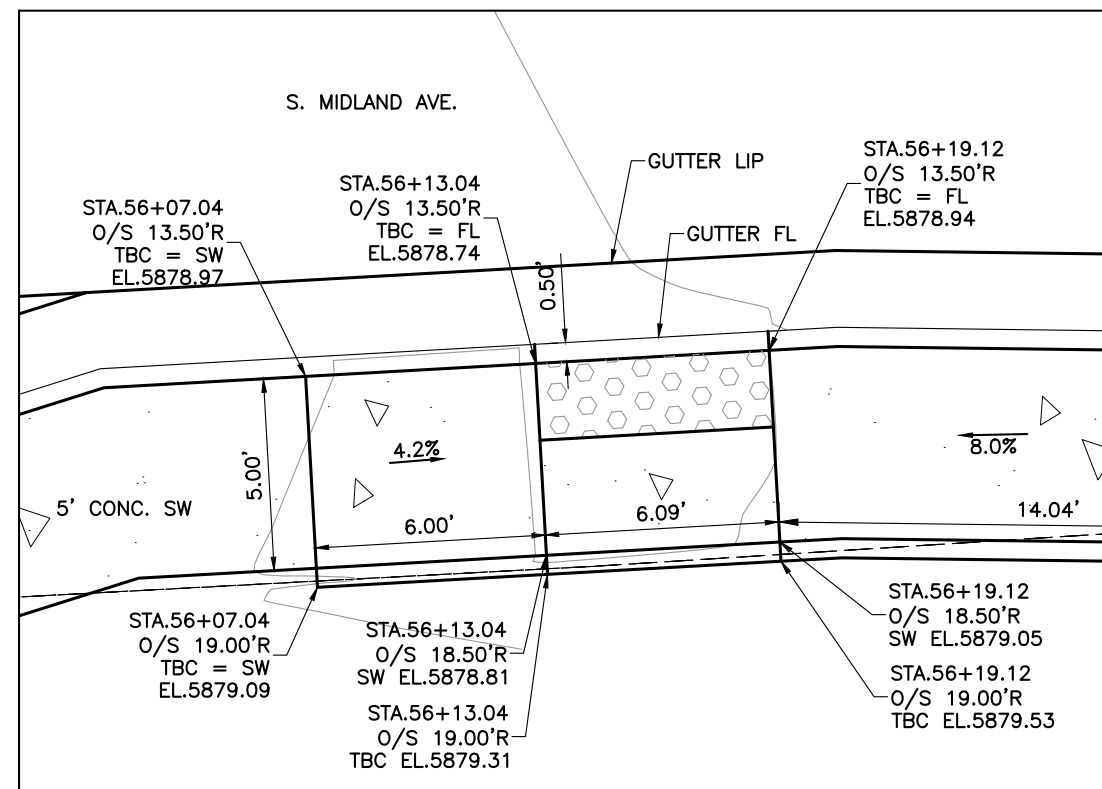


MOUNTAIN MARKET CURB RAMP - SOUTH
CDOT TYPE 2
SCALE: 1" = 5'


Computer File Information		Sheet Revisions				As Constructed		South Midland Ave. Improvements Three Mile Road Intersection			Project No./Code	
Print Date: 7/14/20	Last Modification Date: 4/23/2019	Rev.	Date	Comments	Init.						No.: BUILD M535-006	
Drawing File Name: SMidland-IntersectionDetails		1				No Revisions:	-	Engineer: MDF	Structure	---	Code: 22933	
Autocad Ver. 2018	Scale: As Shown					Revised:	-	Drawn By: AMC	Numbers	---	Sheet Number: 76	
SGM Project No.: 2017-211.001	Quality Control: RGN					Void:	-	Sheet Subset: RDWY	Subset Sheets:	32 of 45		




I:\2017\2017-211-GWSSMIDLAND\001-MIDLAND4MILERO27THST\H-DWGS\CIVIL\PS-SHEETSET\MIDLAND-INTERSECTIONDETAILS.DWG Plotted: 7/14/2020 3:37 PM By: Ashley Cline

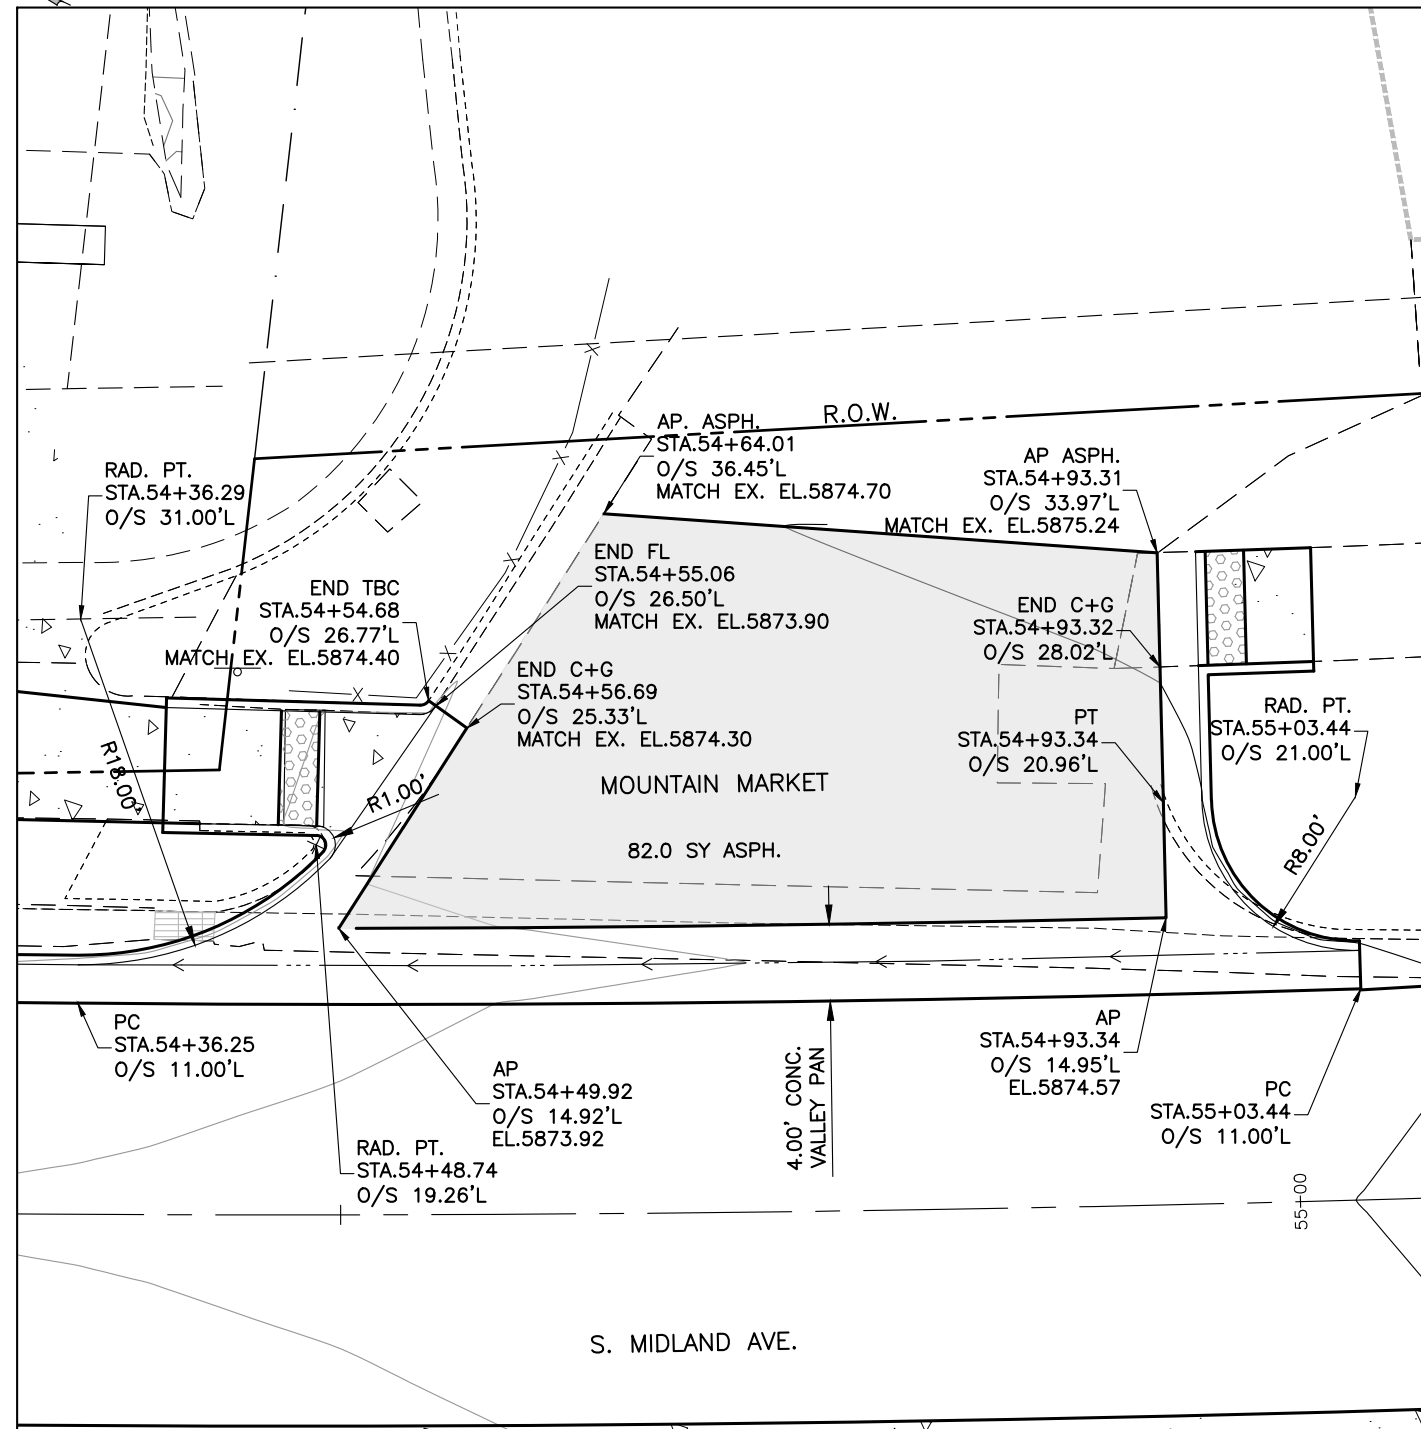

MOUNTAIN MARKET INTERSECTION (NORTH ENTRANCE)
SCALE: 1" = 10'

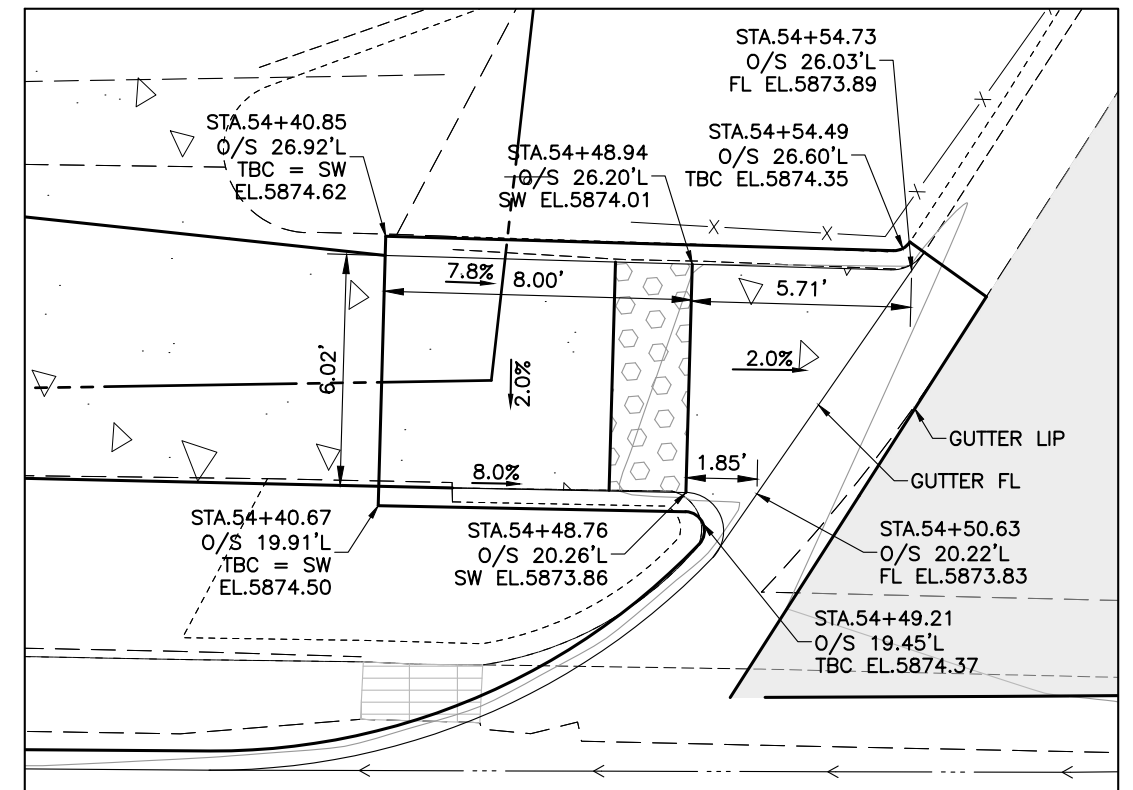

MOUNTAIN MARKET CURB RAMP - NORTH 1
CDOT TYPE 2
SCALE: 1" = 5'

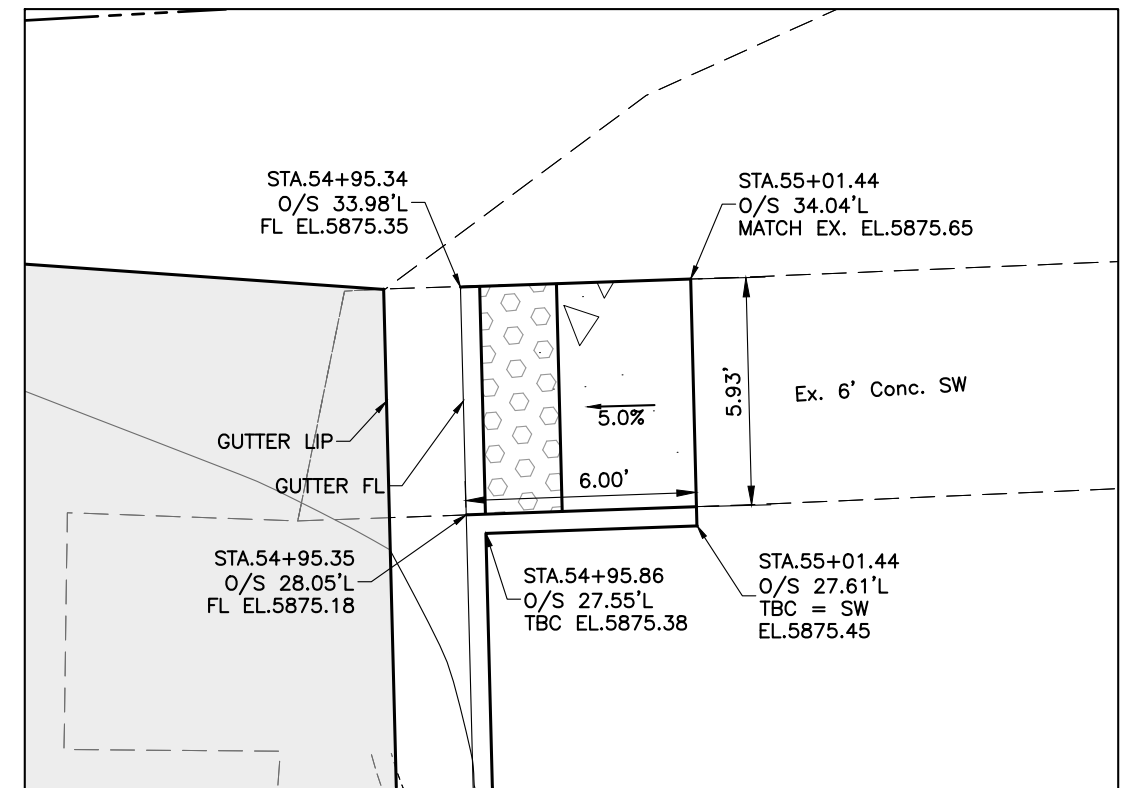


MOUNTAIN MARKET CURB RAMP - NORTH 2
CDOT TYPE 2
SCALE: 1" = 5'


Computer File Information		Sheet Revisions				As Constructed		South Midland Ave. Improvements Mountain Market North Intersection				Project No./Code	
Print Date: 7/14/20		Rev.	Date	Comments	Init.	No Revisions:	-	Engineer:	MDF	Structure	---	No.:	BUILD M535-006
Last Modification Date: 4/23/2019		1				Revised:	-	Drawn By:	AMC	Numbers	---	Code:	22933
Drawing File Name: SMidland-IntersectionDetails						Void:	-	Sheet Subset:	RDWY	Subset Sheets:	33 of 45	Sheet Number:	77
Autocad Ver. 2018	Scale: As Shown	Units: English											
SGM Project No.: 2017-211.001	Quality Control: RGN												



I:\2017\2017-211-GWSSOMIDLAND\001-MIDLAND4MILERO27THST\H-DWGS\CIVIL\PS-SHEETSET\SMIDLAND-INTERSECTIONDETAILS.DWG Plotted: 7/14/2020 3:38 PM By: Ashley Cline

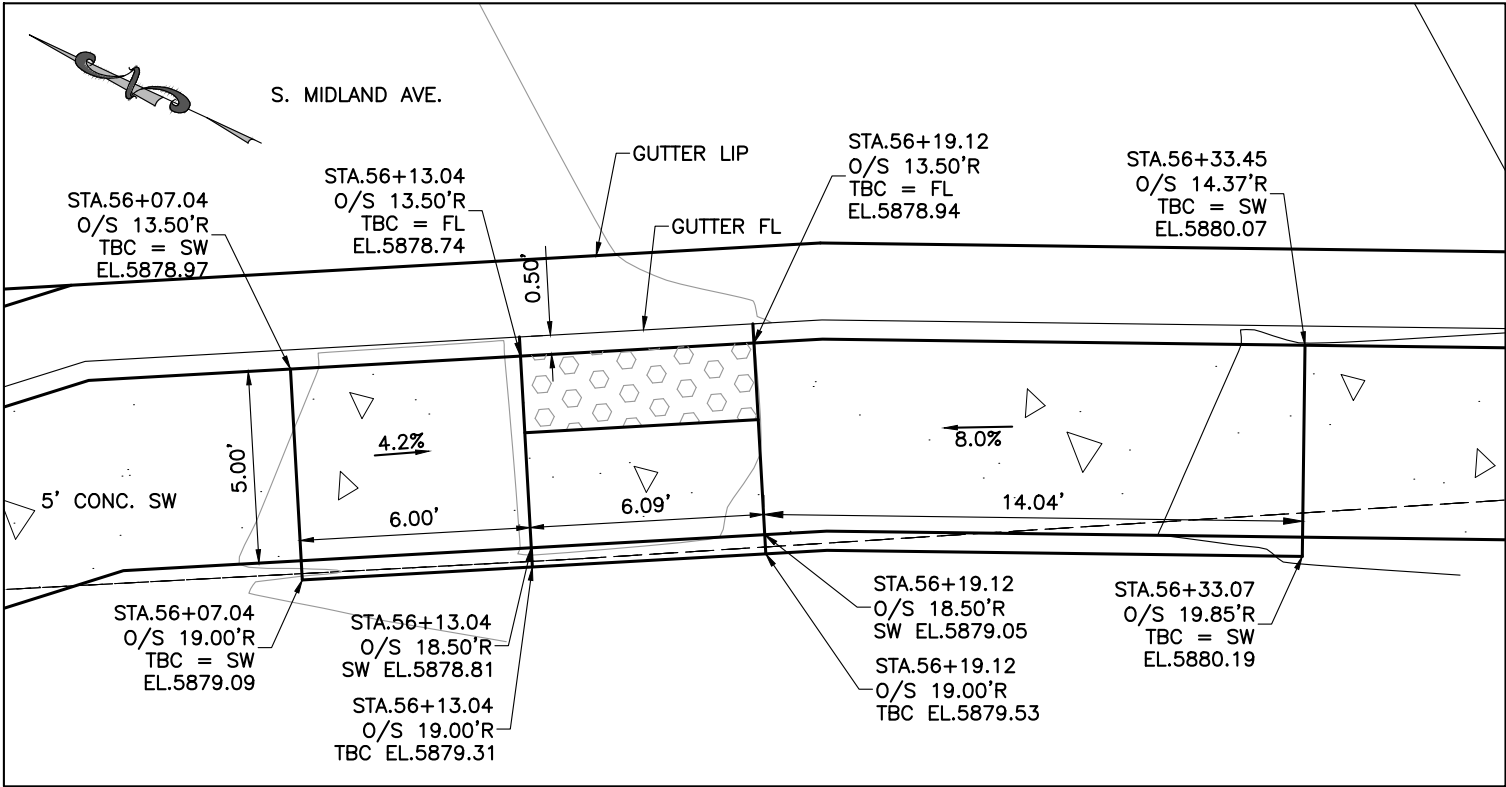

MOUNTAIN MARKET CURB RAMP - SOUTH
CDOT TYPE 2
SCALE: 1" = 5'

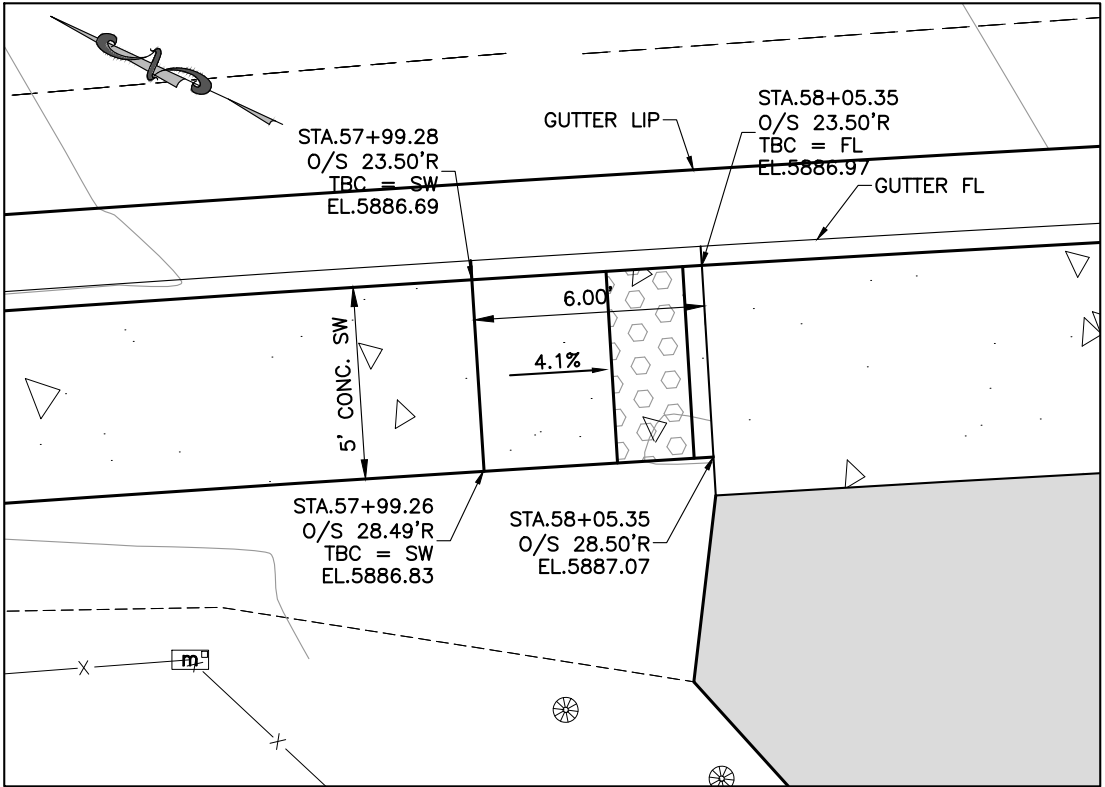


HIDEOUT CURB RAMP
CDOT TYPE 2
SCALE: 1" = 5'

Computer File Information		Sheet Revisions				As Constructed		South Midland Ave. Improvements Mountain Market Curb Ramps			Project No./Code	
Print Date: 7/14/20		Rev.	Date	Comments	Init.	No Revisions:	-	Engineer:	MDF	Structure	No.: BUILD M535-006	
Last Modification Date: 4/23/2019		1				Revised:	-	Drawn By:	AMC	Numbers	Code: 22933	
Drawing File Name: SMidland-IntersectionDetails						Void:	-	Sheet Subset:	RDWY	Subset Sheets:	34 of 45	Sheet Number: 78
Autocad Ver. 2018	Scale: As Shown	Units: English										
SGM Project No.: 2017-211.001	Quality Control: RGN											




118 West Sixth Street, Suite 200
Glenwood Springs, CO 81601
970.945.1004 www.sgm-inc.com

I:\2017\2017-211-GWSSOMIDLAND\001-MIDLAND4MILERO27THST\H-DWGS\CIVIL\PS-SHEETSET\SMIDLAND-INTERSECTIONDETAILS.DWG Plotted: 7/14/2020 3:38 PM By: Ashley Cline

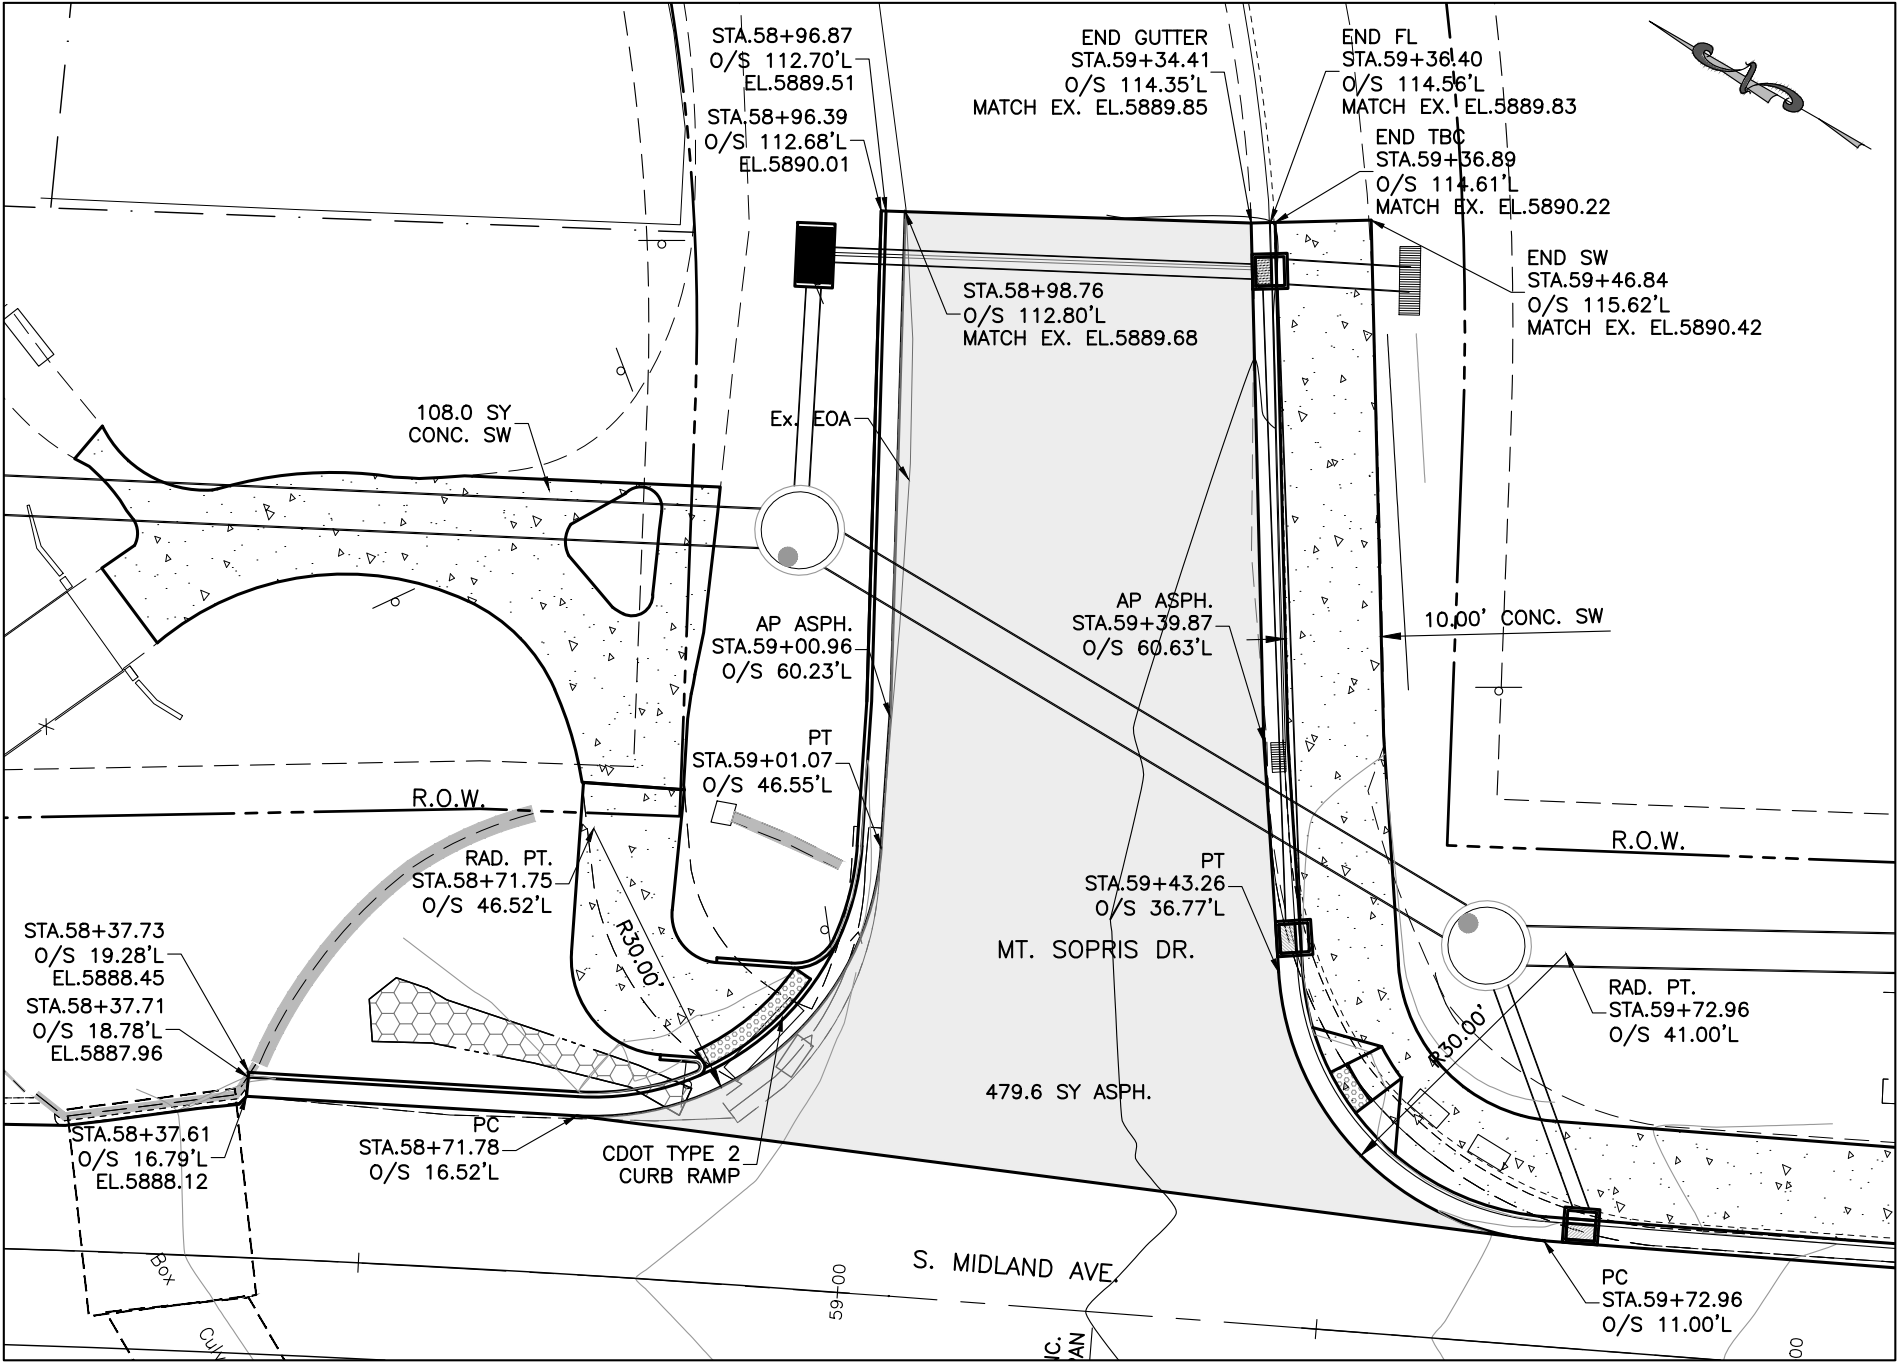


MT. SOPRIS DRIVE INTERSECTION
SCALE: 1" = 20'


Computer File Information		Sheet Revisions				As Constructed		South Midland Ave. Improvements Mt. Sopris Drive Intersection			Project No./Code	
Print Date: 7/14/20	Last Modification Date: 4/23/2019	Rev.	Date	Comments	Init.						No.: BUILD M535-006	
Drawing File Name: SMidland-IntersectionDetails		1				No Revisions:	-	Engineer: MDF	Structure	---	Code: 22933	
Autocad Ver. 2018	Scale: As Shown					Revised:	-	Drawn By: AMC	Numbers	---		
SGM Project No.: 2017-211.001	Quality Control: RGN					Void:	-	Sheet Subset: RDWY	Subset Sheets:	35 of 45	Sheet Number: 79	



I:\2017\2017-211-GWSSOMIDLAND\001-MIDLAND4MILERO27THST\H-DWGS\CIVIL\PS-SHEETSET\MIDLAND-INTERSECTIONDETAILS.DWG Plotted: 7/14/2020 3:38 PM By: Ashley Cline

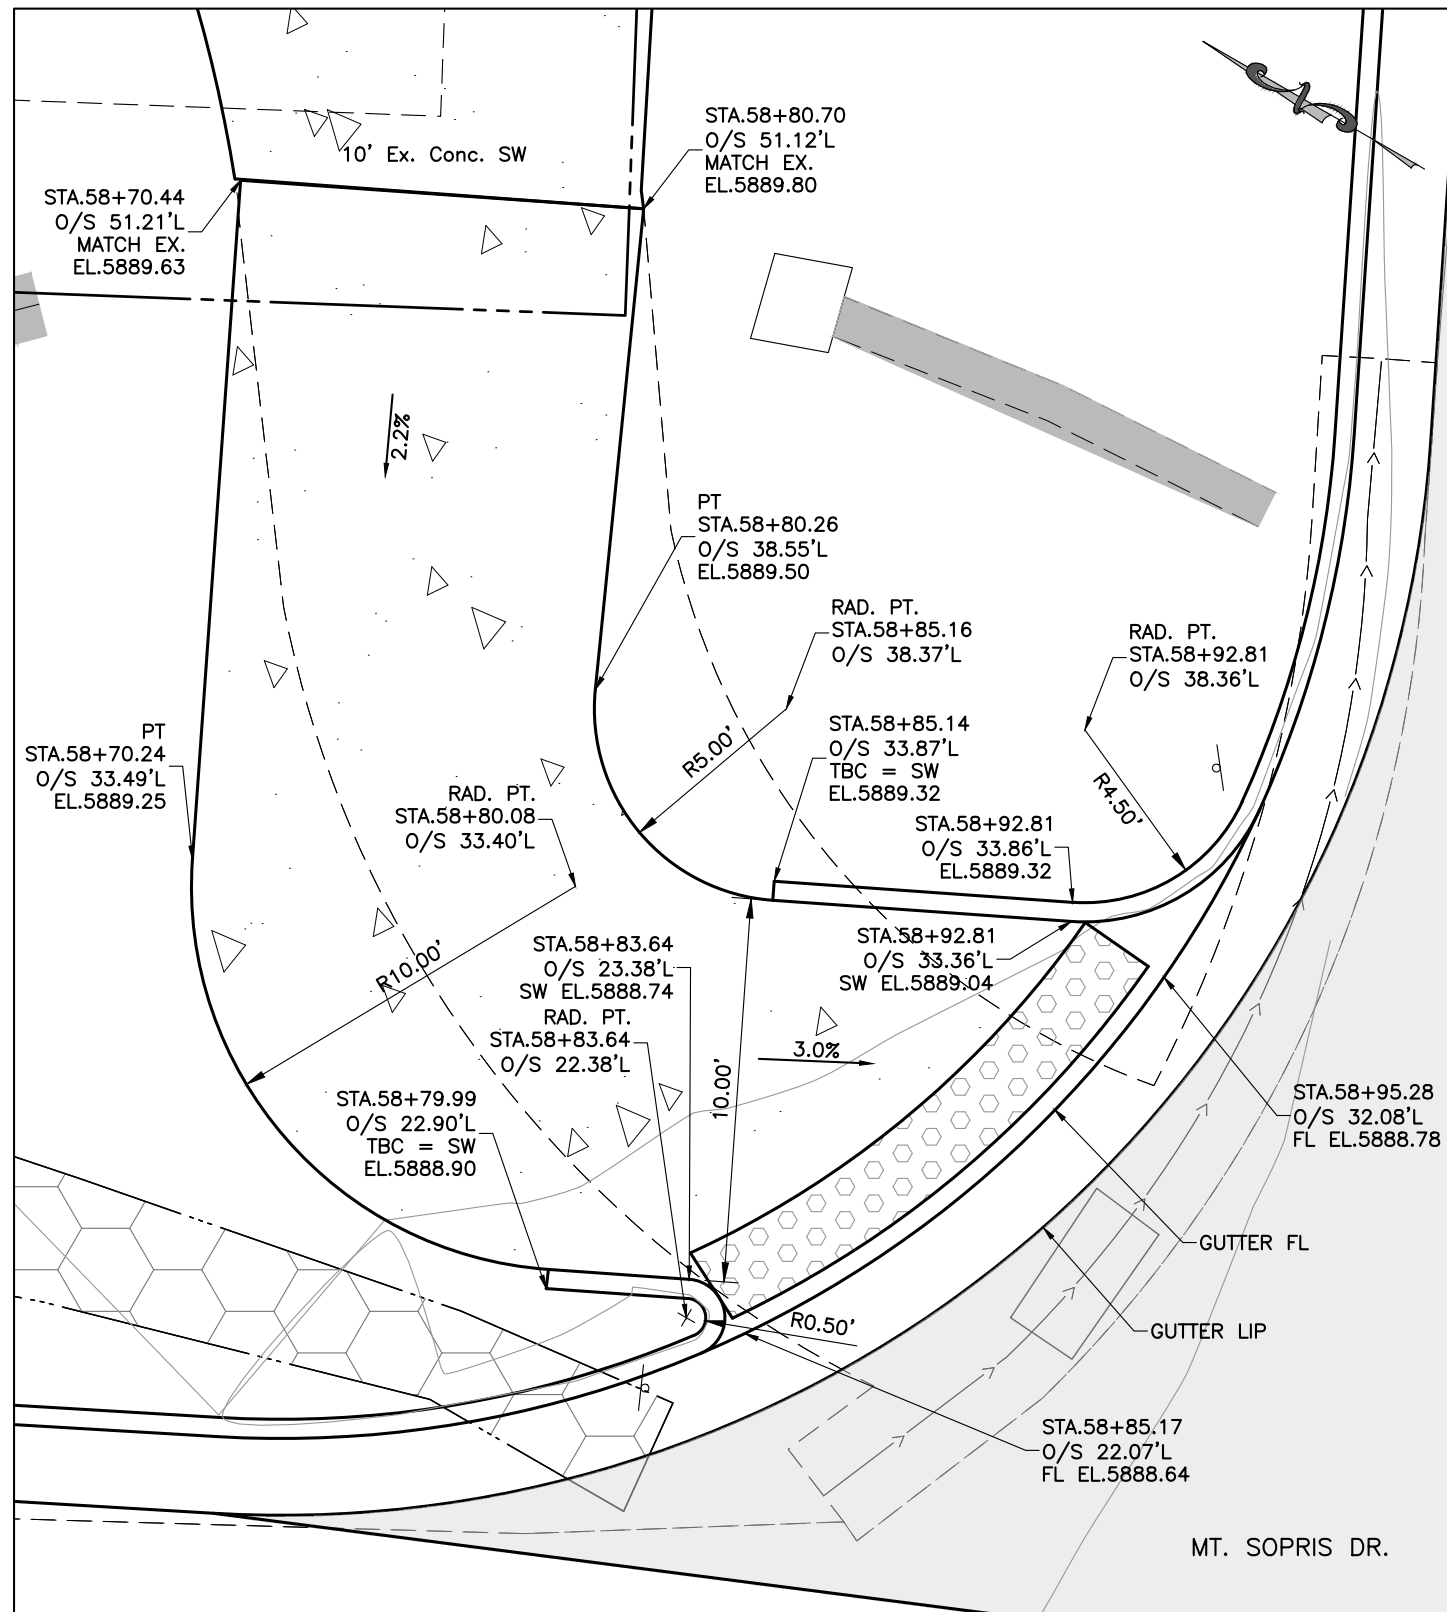

MT SOPRIS DRIVE CURB RAMP - NORTH
CDOT TYPE 2
SCALE: 1" = 5'

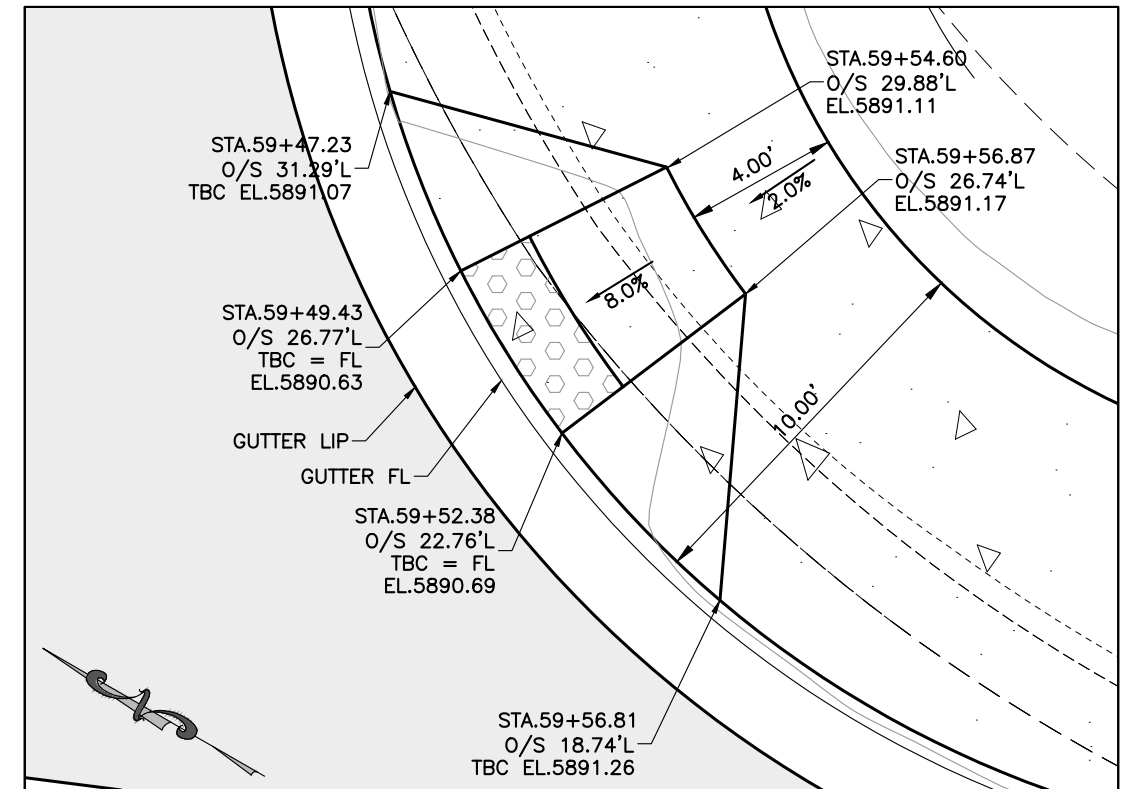


MT. SOPRIS DRIVE CURB RAMP
CDOT TYPE 1
SCALE: 1" = 5'

Computer File Information		Sheet Revisions			
Print Date: 7/14/20		Rev.	Date	Comments	Init.
Last Modification Date: 4/23/2019		1			
Drawing File Name: SMidland-IntersectionDetails					
Autocad Ver. 2018 Scale: As Shown Units: English					
SGM Project No.: 2017-211.001 Quality Control: RGN					



As Constructed		South Midland Ave. Improvements				Project No./Code	
No Revisions: -		Mt. Sopris Drive Curb Ramps				No.: BUILD M535-006	
Revised: -	-	Engineer:	MDF	Structure	---	Code: 22933	
		Drawn By:	AMC	Numbers	---	Sheet Number: 80	
		Sheet Subset:	RDWY	Subset Sheets:	36 of 45		
Void:	-						

I:\2017\2017-211-GWSSOMIDLAND\001-MIDLAND4MILERO27THST\H-DWGS\CIVIL\PS-SHEETSET\SMIDLAND-INTERSECTIONDETAILS.DWG Plotted: 7/14/2020 3:39 PM By: Ashley Cline

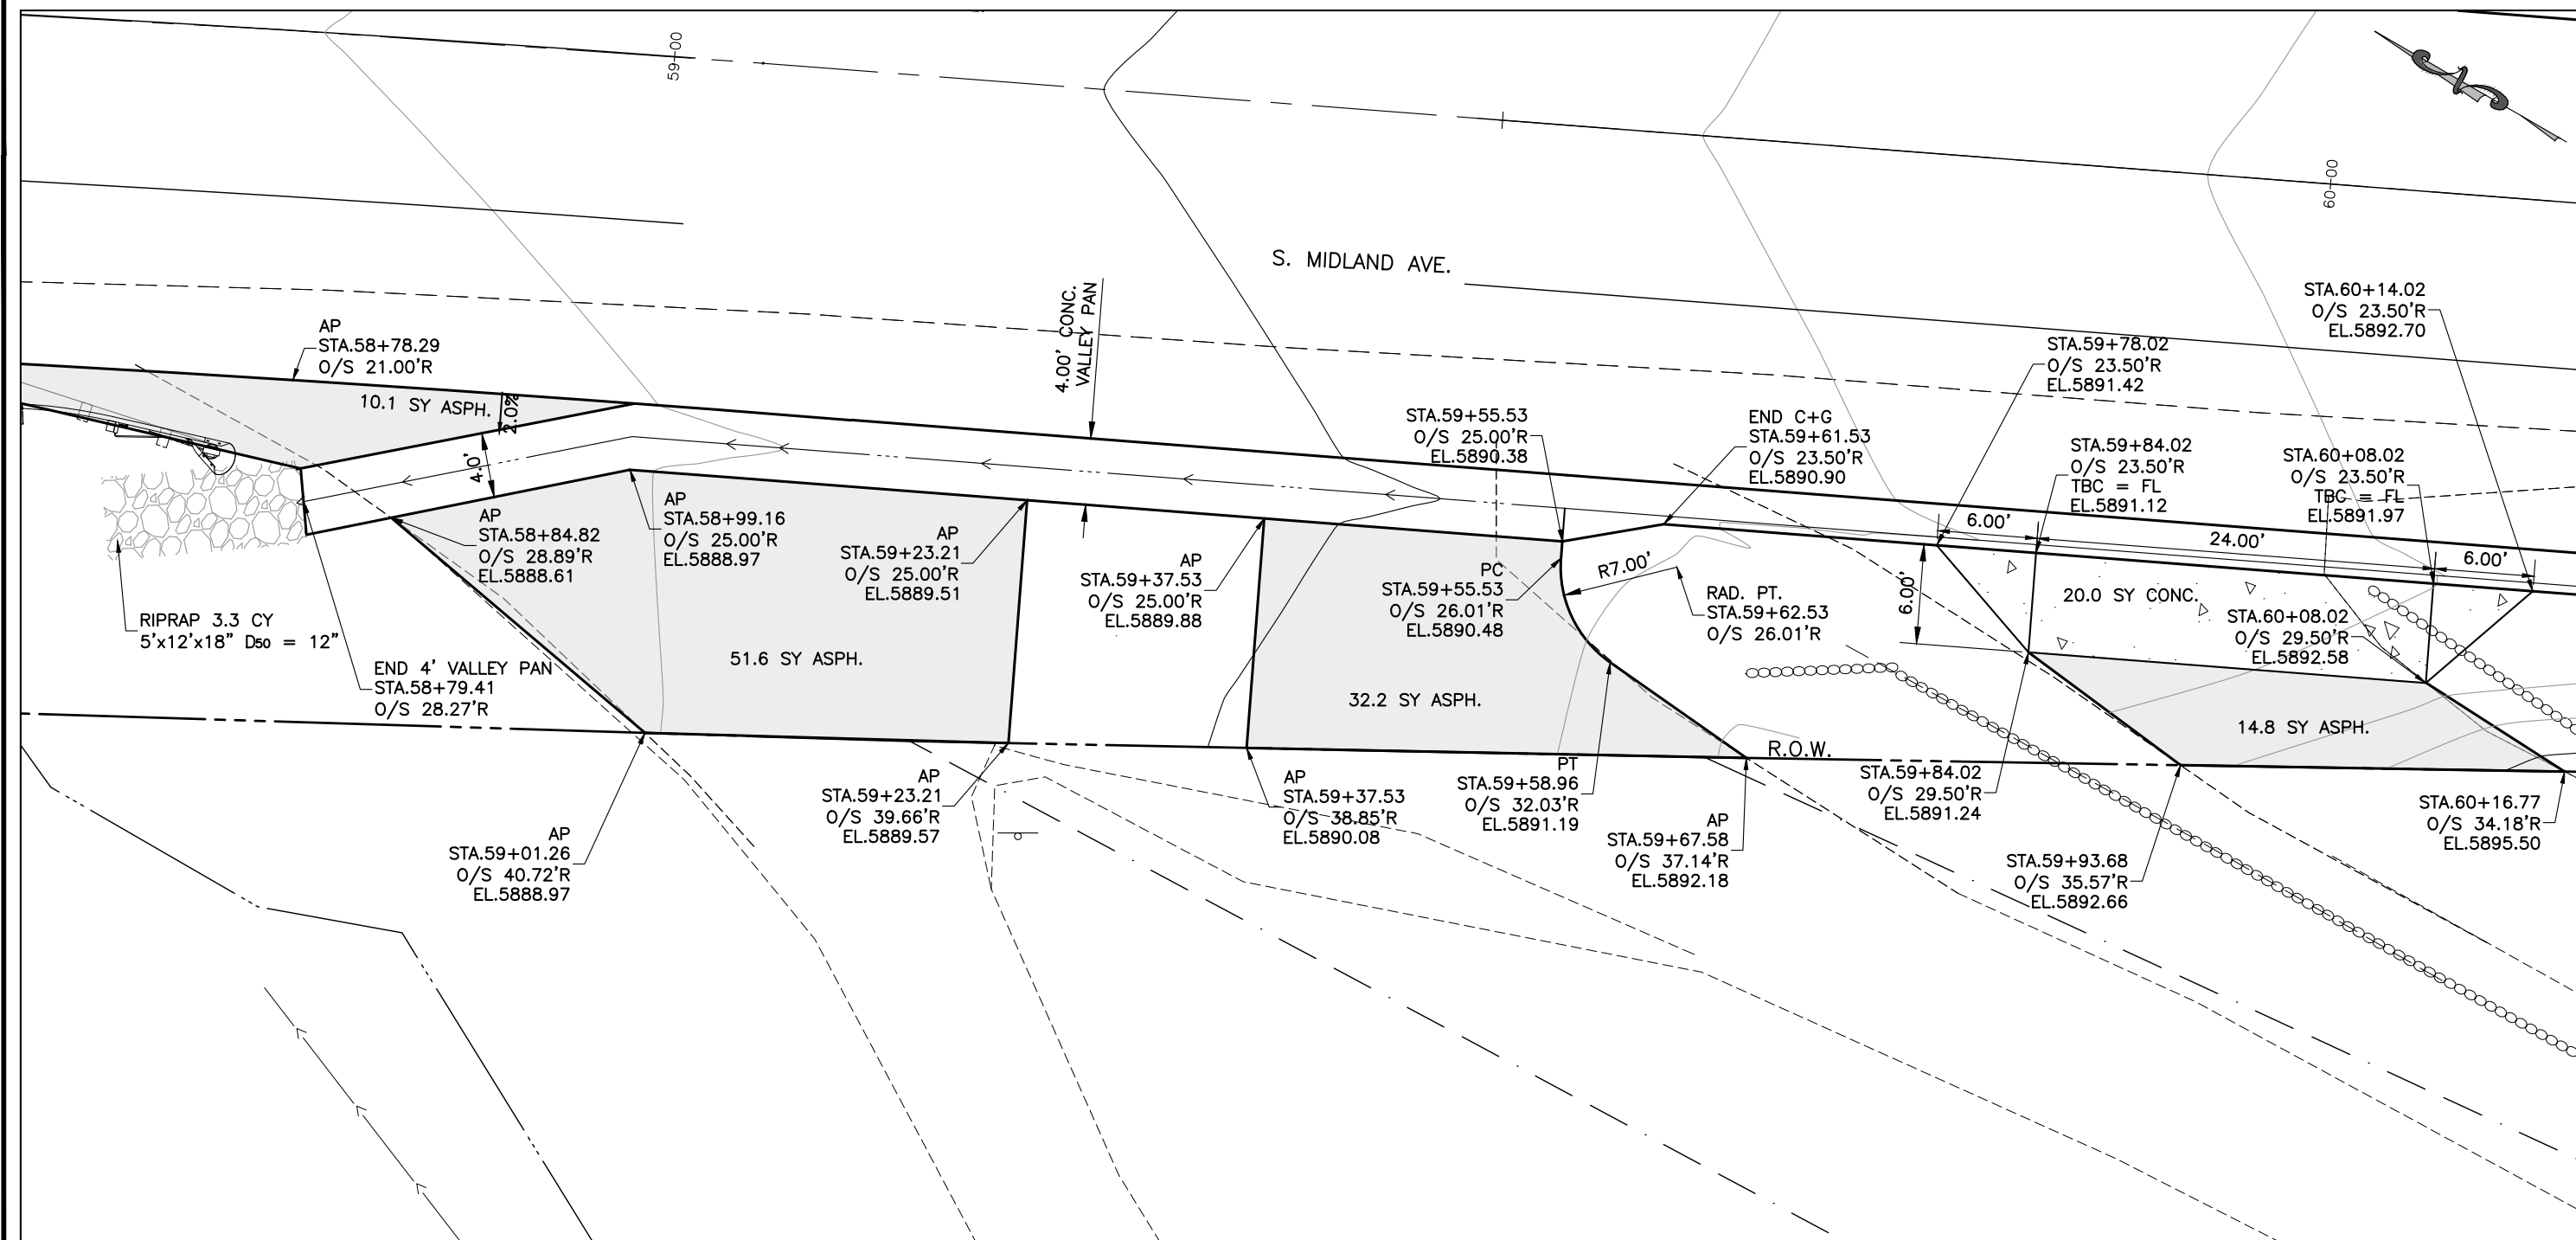


MT. SOPRIS DRIVEWAYS
SCALE: 1" = 10'


Computer File Information		Sheet Revisions				As Constructed		South Midland Ave. Improvements Mt. Sopris Drive Driveways			Project No./Code	
Print Date: 7/14/20	Last Modification Date: 4/23/2019	Rev.	Date	Comments	Init.						No.: BUILD M535-006	
Drawing File Name: SMidland-IntersectionDetails		1				No Revisions:	-	Engineer: MDF	Structure	---	Code: 22933	
Autocad Ver. 2018	Scale: As Shown					Revised:	-	Drawn By: AMC	Numbers	---	Sheet Number: 81	
SGM Project No.: 2017-211.001	Quality Control: RGN					Void:	-	Sheet Subset: RDWY	Subset Sheets:	37 of 45		



I:\2017\2017-211-GWSSOMIDLAND\001-MIDLAND4MILERO27THST\H-DWGS\CIVIL\PS-SHEETSET\MIDLAND-INTERSECTIONDETAILS.DWG Plotted: 7/14/2020 3:39 PM By: Ashley Cline

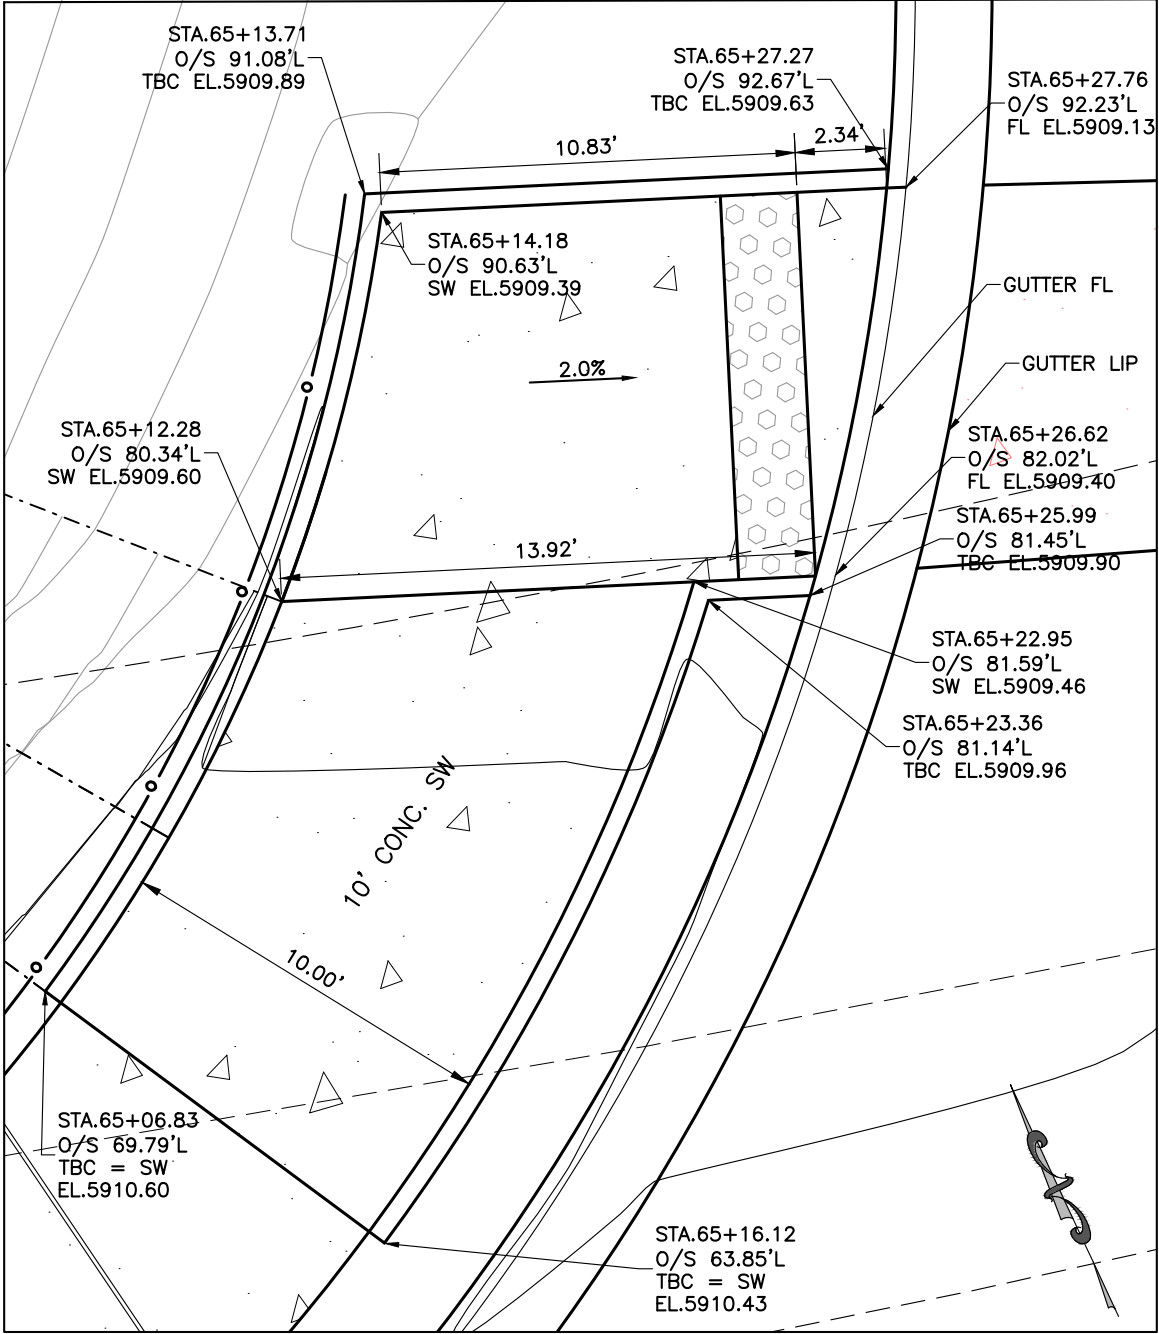

ROUNDABOUT CURB RAMP 1
CDOT TYPE 1 / 2 COMBINATION
SCALE: 1" = 5'

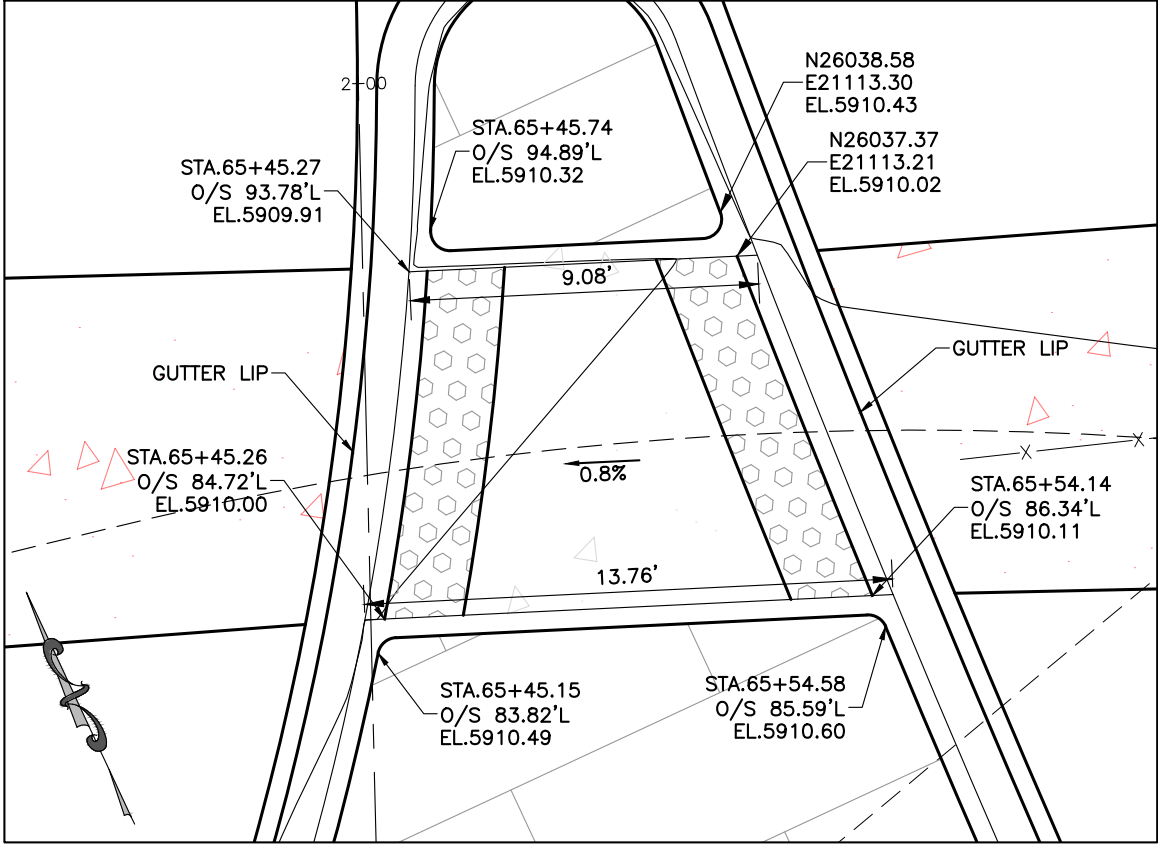


ROUNDABOUT CURB RAMP 2
CDOT CURB RAMPS FOR CROSSING ISLANDS
SCALE: 1" = 5'

Computer File Information		Sheet Revisions					 118 West Sixth Street, Suite 200 Glenwood Springs, CO 81601 970.945.1004 www.sgm-inc.com	As Constructed		South Midland Ave. Improvements Roundabout Curb Ramps				Project No./Code	
Print Date: 7/14/20		Rev.	Date	Comments	Init.			No Revisions: -		No.: BUILD M535-006					
Last Modification Date: 4/23/2019		1						Revised: -		Engineer: MDF		Structure	Code: 22933		
Drawing File Name: SMidland-IntersectionDetails								Drawn By: AMC		Numbers			Sheet Number: 82		
Autocad Ver. 2018 Scale: As Shown Units: English								Void: -		Sheet Subset: Roadway	Subset Sheets:	38 of 45			
SGM Project No.: 2017-211.001 Quality Control: RGN															



I:\2017\2017-211-GWSSOMIDLAND\001-MIDLAND4MILERO27THST\H-DWGS\CIVIL\PS-SHEETSET\SMIDLAND-INTERSECTIONDETAILS.DWG Plotted: 7/14/2020 3:40 PM By: Ashley Cline


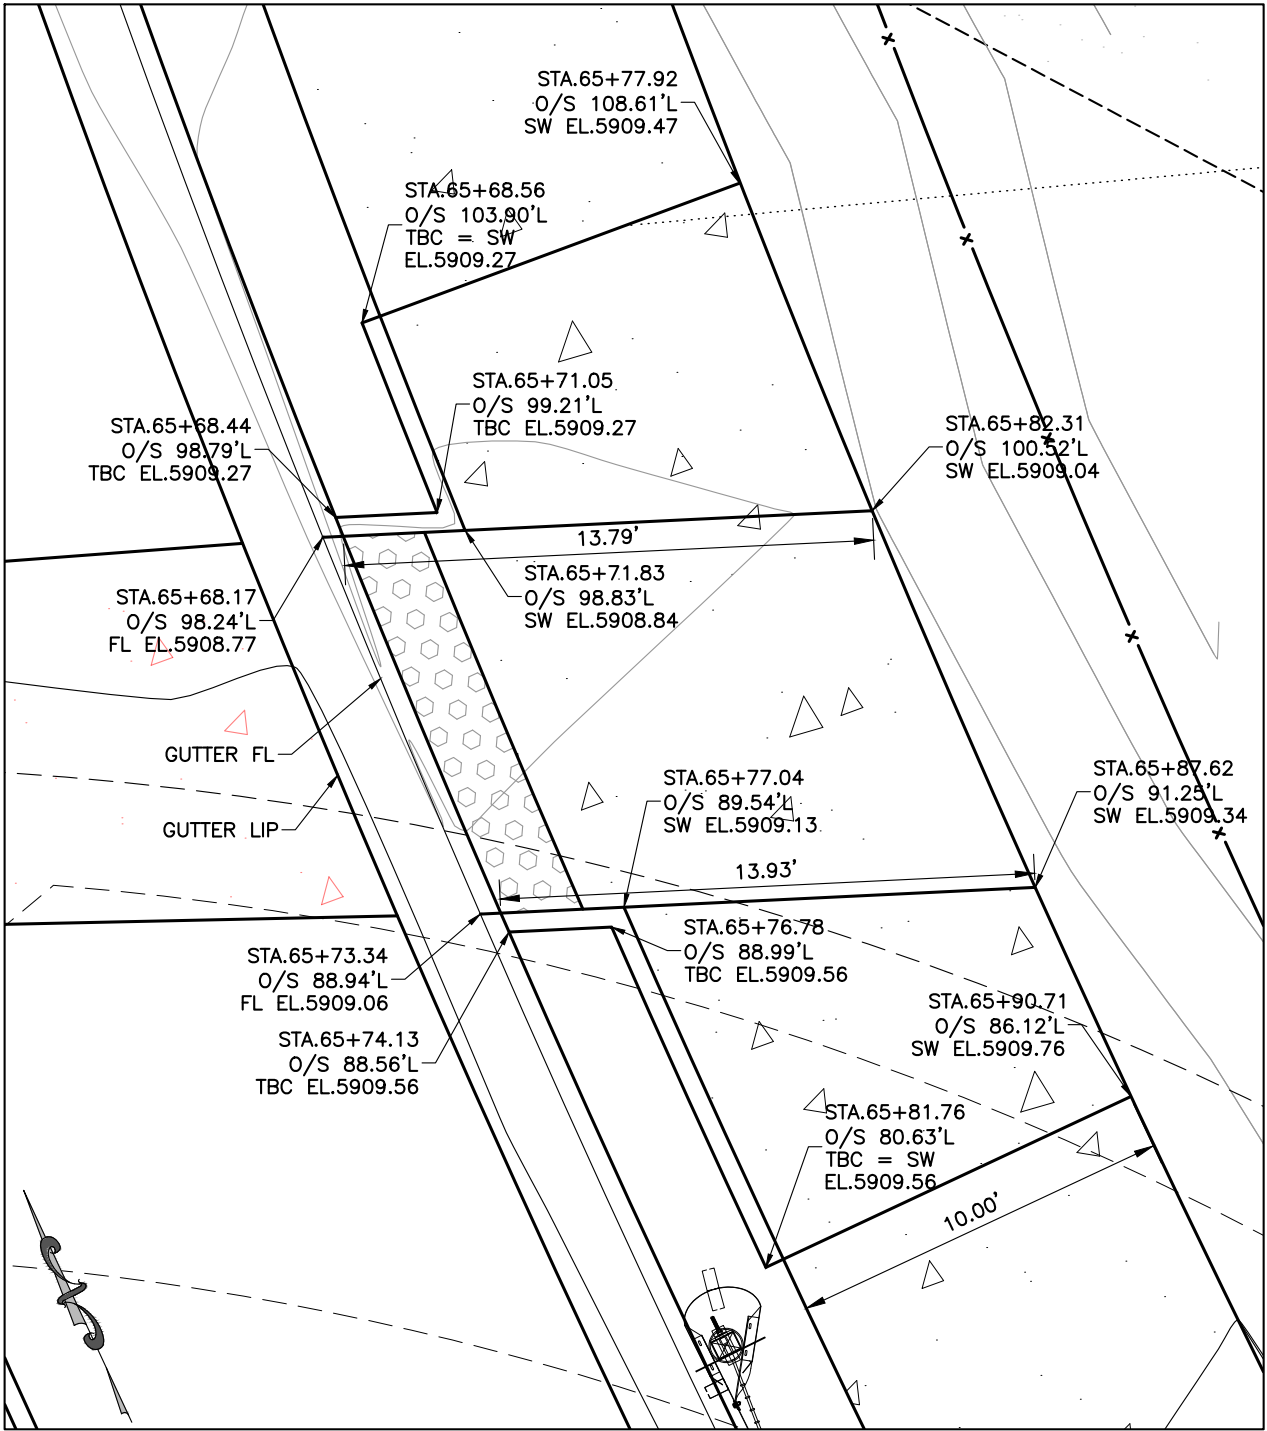


ROUNDBOUT CURB RAMP 3
CDOT TYPE 1 / 2 COMBINATION
SCALE: 1" = 5'

Computer File Information		Sheet Revisions				As Constructed		South Midland Ave. Improvements Roundabout Curb Ramps (2)			Project No./Code	
Print Date: 7/14/20		Rev.	Date	Comments	Init.						No.:	BUILD M535-006
Last Modification Date: 4/23/2019		1				No Revisions:	-					
Drawing File Name: SMidland-IntersectionDetails						Revised:	-	Engineer:	MDF	Structure	Code: 22933	
Autocad Ver. 2018 Scale: As Shown Units: English						Void:	-	Drawn By:	AMC	Numbers		
SGM Project No.: 2017-211.001 Quality Control: RGN								Sheet Subset:	RWDY	Subset Sheets:	39 of 45	Sheet Number: 83



- NOTE:
1. CONTRACTOR TO RE-GRADE EXISTING IRRIGATION DITCH FOR ADEQUATE DITCH FLOW TO AND FROM PROPOSED PIPES.
 2. LAVEN FIELD ACCESS DRIVE (AFTER R.O.W.) TO BE 6" CLASS 2 ABC.
 3. SEE SHEET 89 FOR DRIVEWAY ACCESS DETAILS.

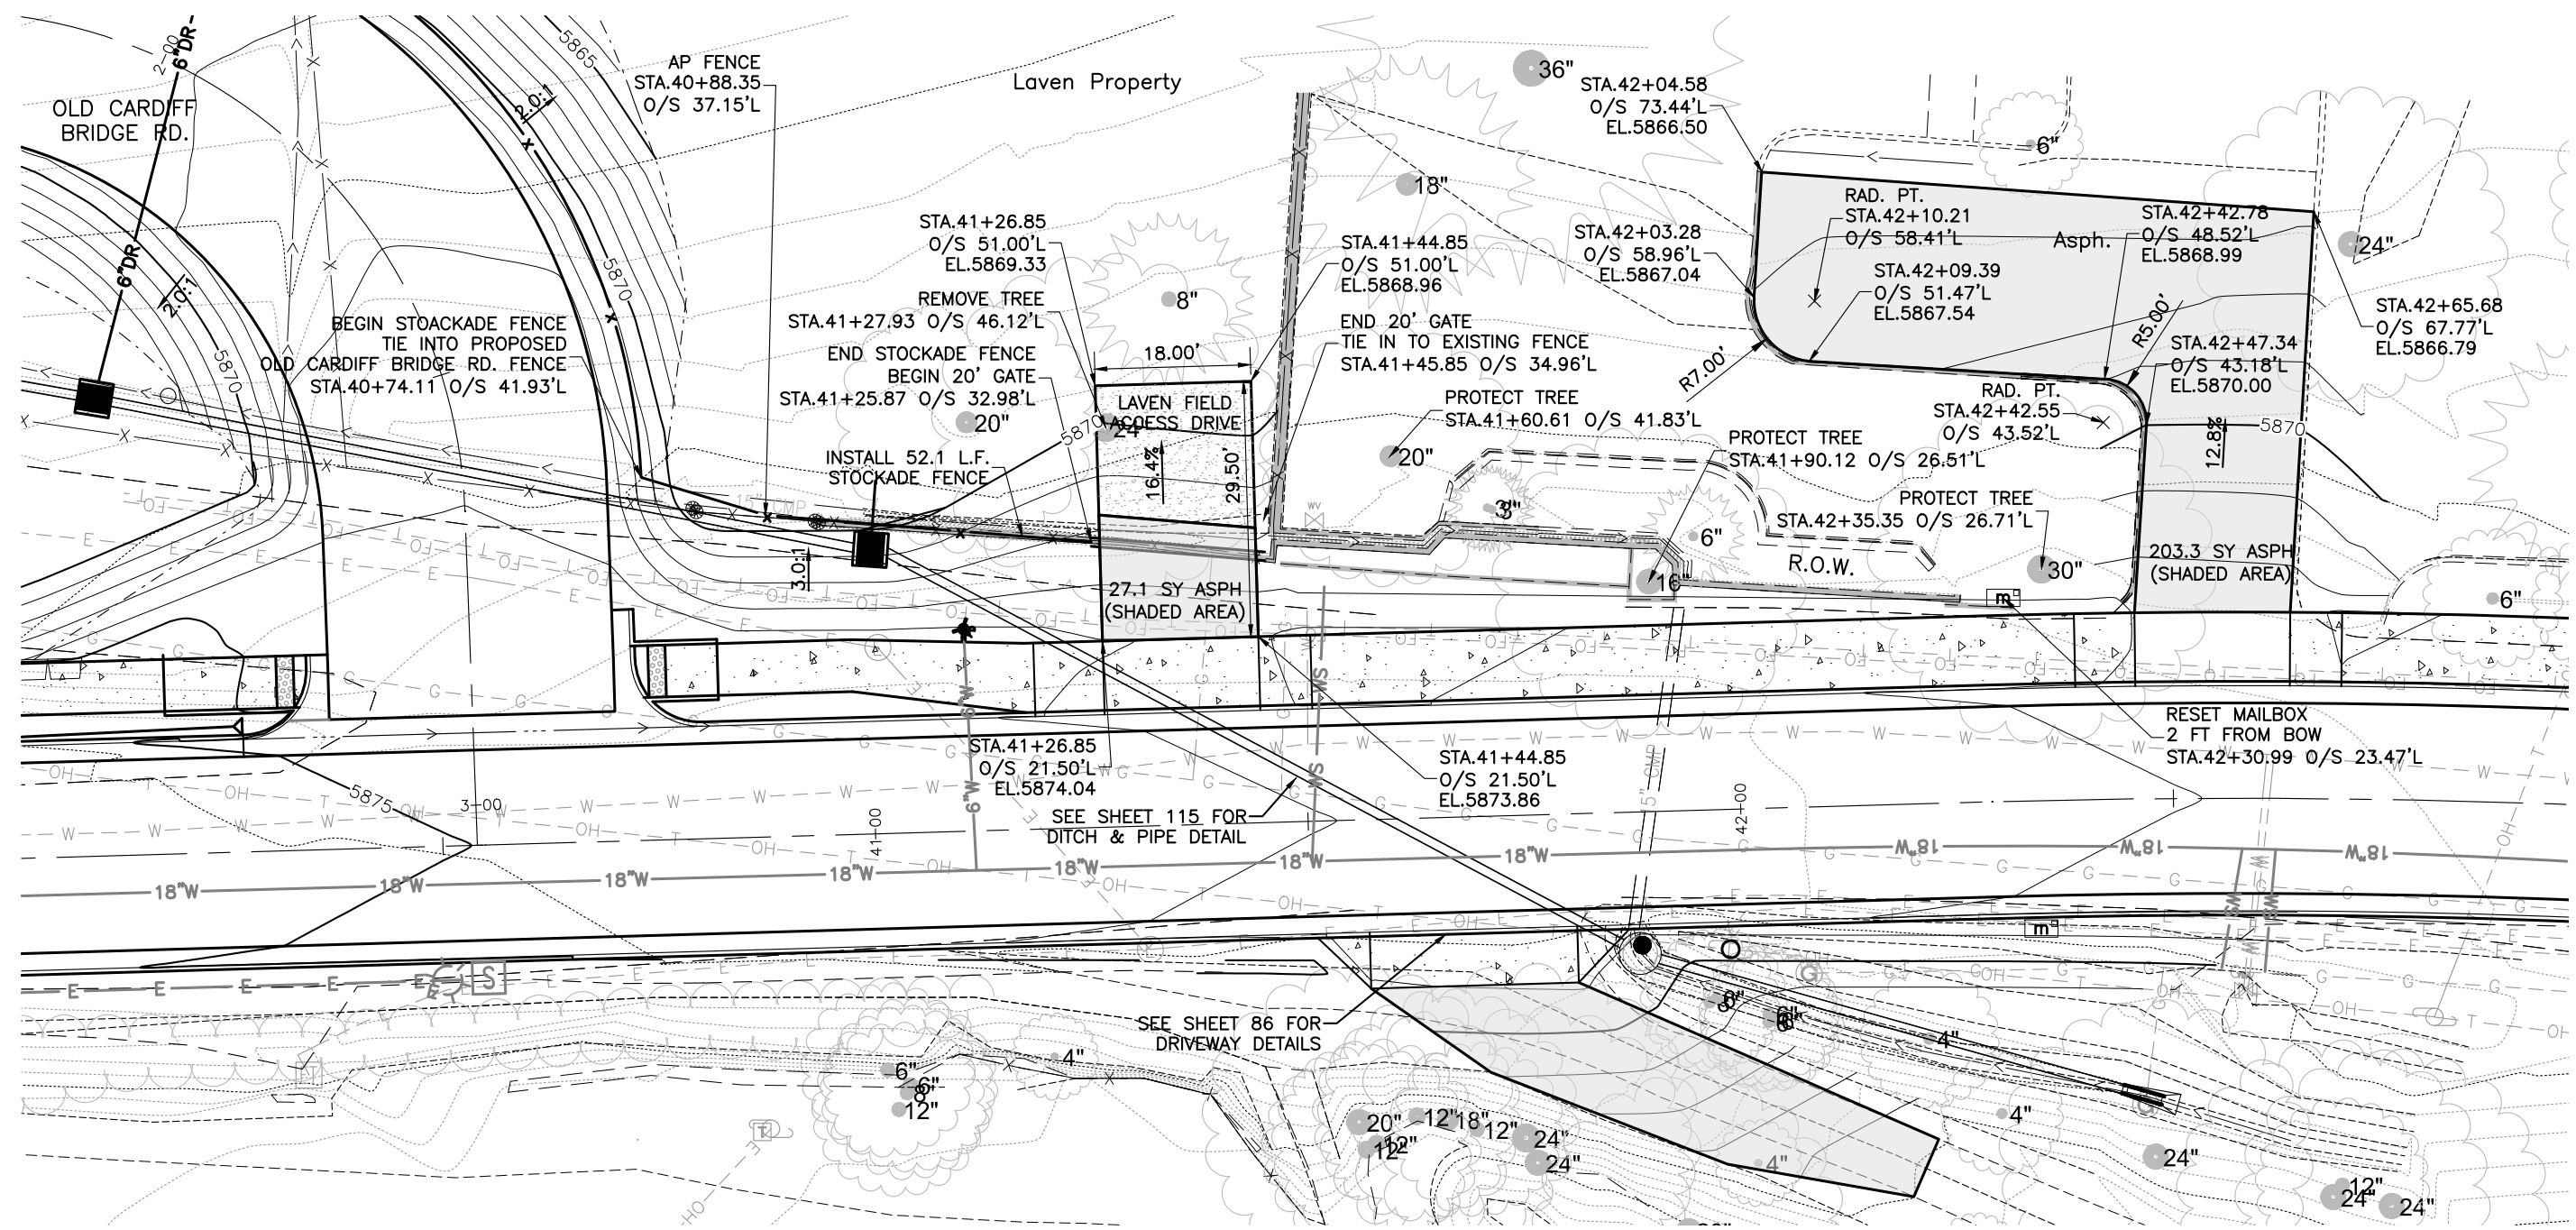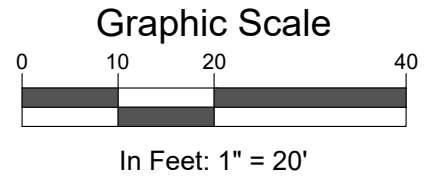

LAVEN PROPERTY ACCESS DETAIL

I:\2017\2017-211-GWSSOMIDLAND\001-MIDLAND4MILE RD27TH ST-H-DWGS\CIVIL\PS-SHEETSET\MIDLAND-DRIVEWAYDETAILS.DWG Plotted: 7/14/2020 3:41 PM By: Ashley Cline

Computer File Information		Sheet Revisions				As Constructed		South Midland Ave. Improvements Laven Property Detail			Project No./Code	
Print Date: 7/14/20	Last Modification Date: 4/23/2019	Rev.	Date	Comments	Init.						No.: BUILD M535-006	No.
Drawing File Name: SMidland-DrivewayDetails		1				No Revisions:	-	Engineer: MDF	Structure	---	Code: 22933	
Autocad Ver. 2018	Scale: As Shown					Revised:	-	Drawn By: AMC	Numbers	---	Sheet Number: 84	
SGM Project No.: 2017-211.001	Quality Control: RGN					Void:	-	Sheet Subset: RDWY	Subset Sheets:	40 of 45		




GLENWOOD SPRINGS
COLORADO




SGM
118 West Sixth Street, Suite 200
Glenwood Springs, CO 81601
970.945.1004 www.sgm-inc.com


I:\2017\211-211-GWSSMIDLAND\001-MIDLAND4MILERD27TH\H-DWGS\CIVIL\PS-SHEETSET\SMIDLAND-DRIVEWAYDETAILS.DWG Plotted: 7/14/2020 3:42 PM By: Ashley Cline

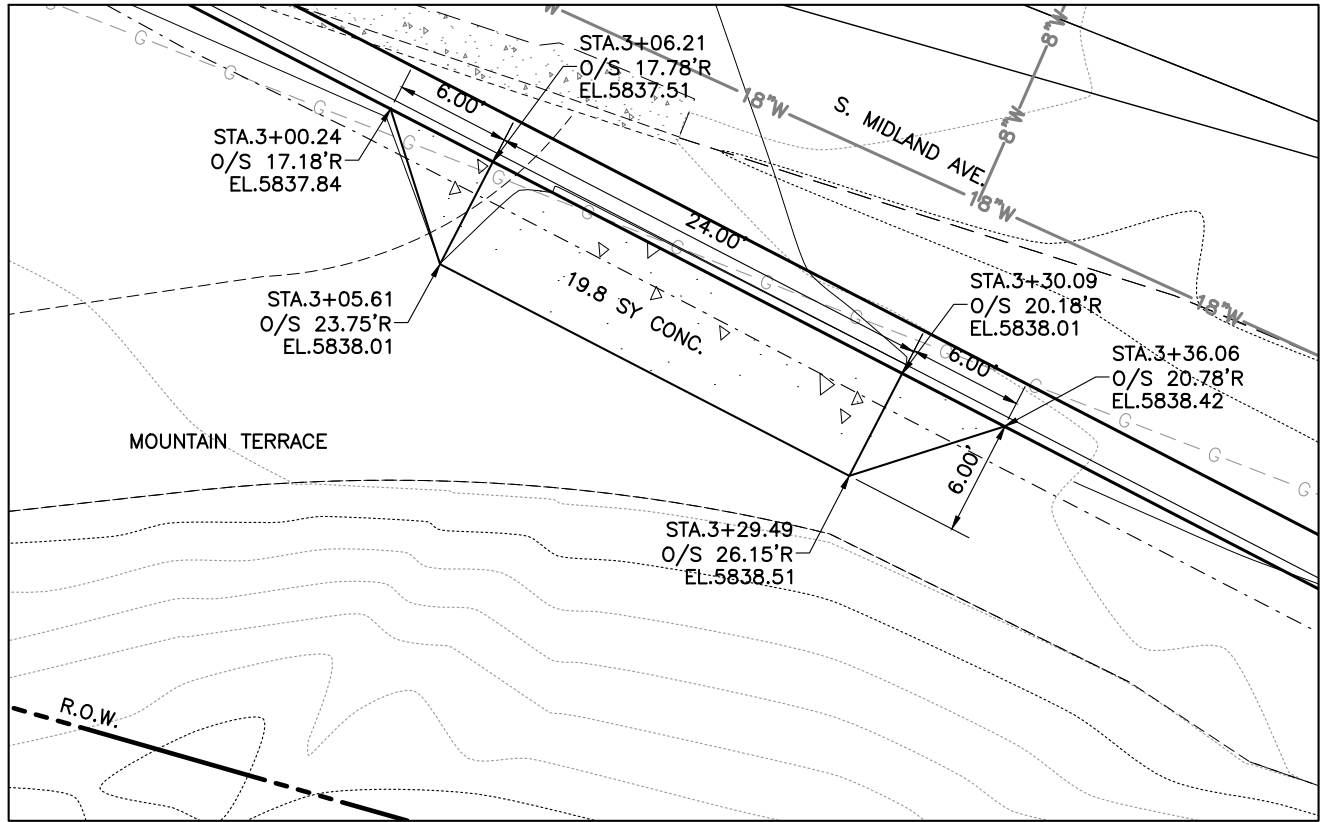


MOUNTAIN TERRACE DRIVEWAY
SCALE: 1" = 10'

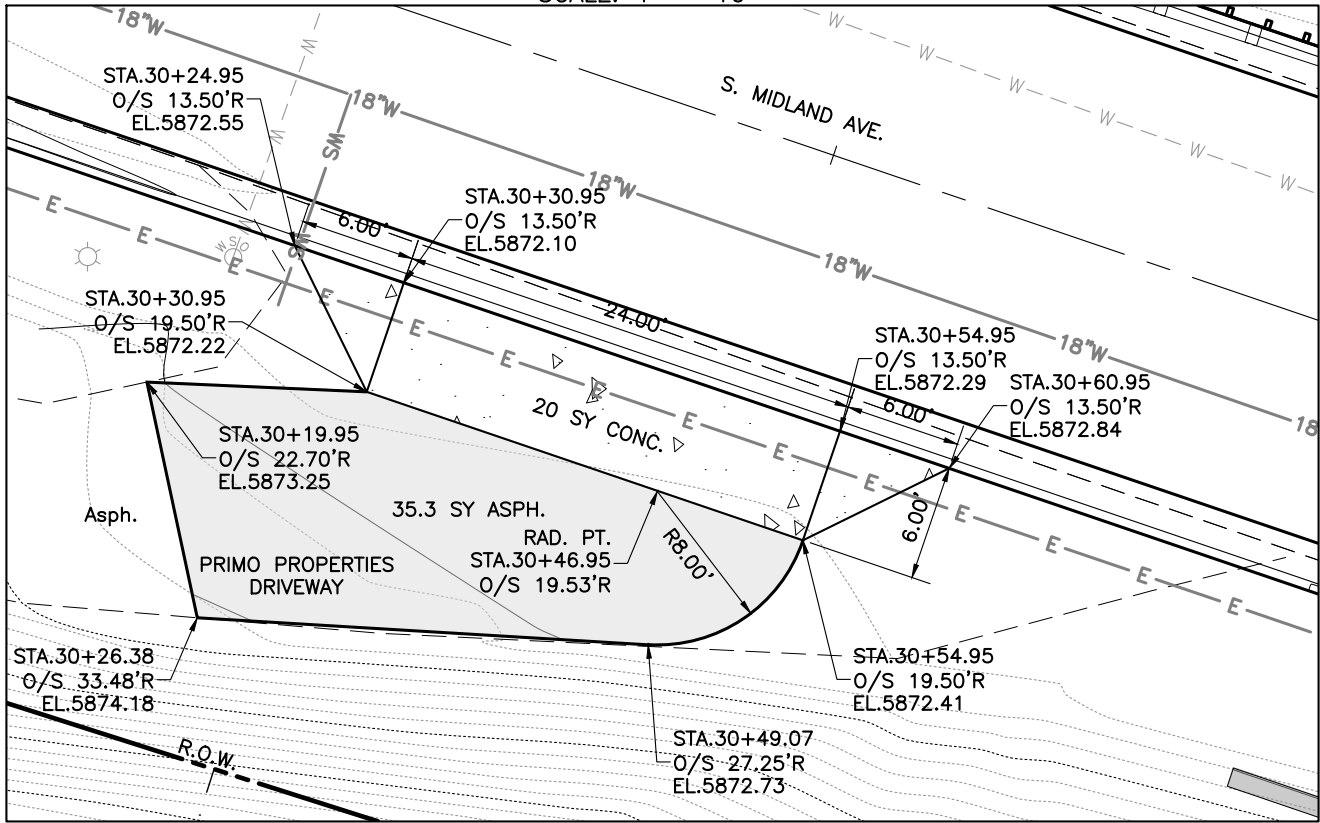

PRIMO PROPERTIES DRIVEWAY
SCALE: 1" = 10'

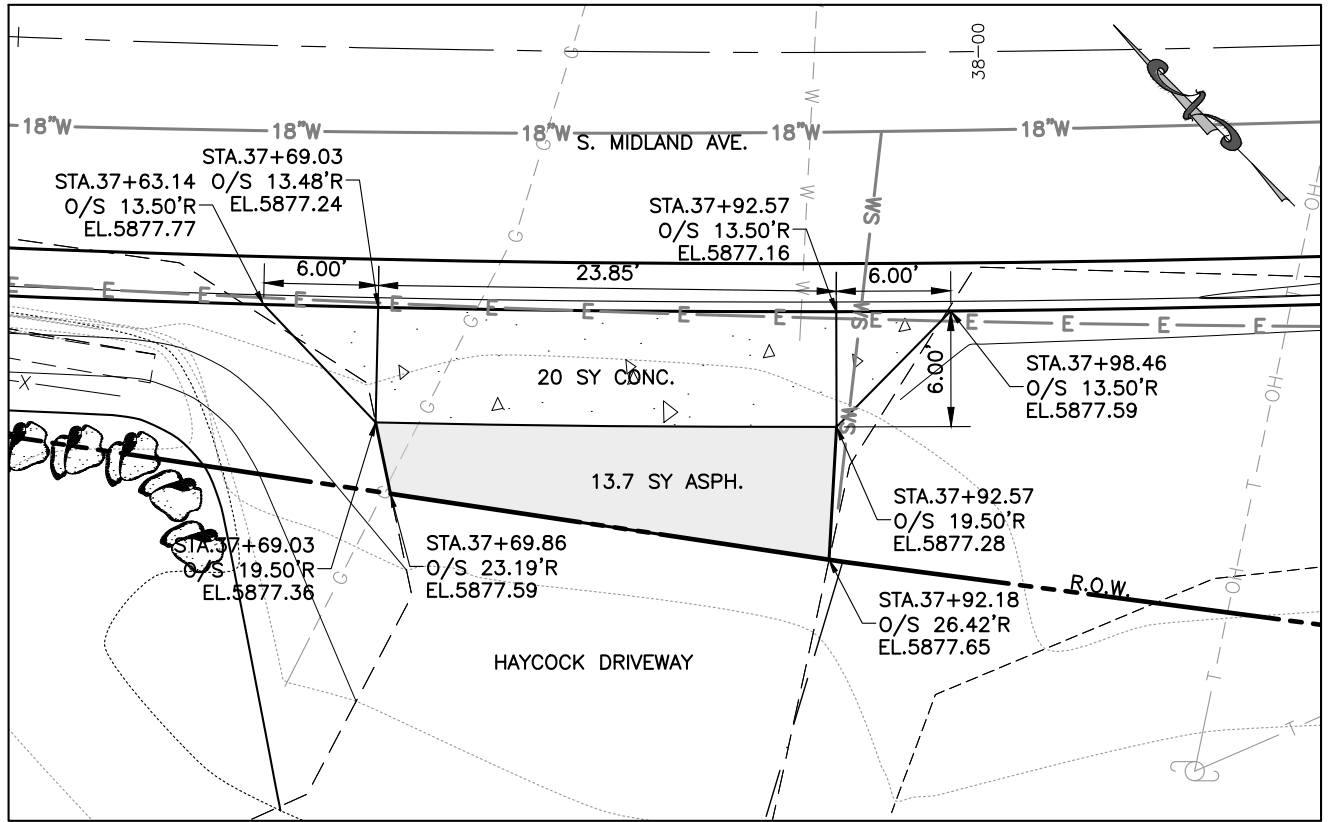

HAYCOCK DRIVEWAY
SCALE: 1" = 10'

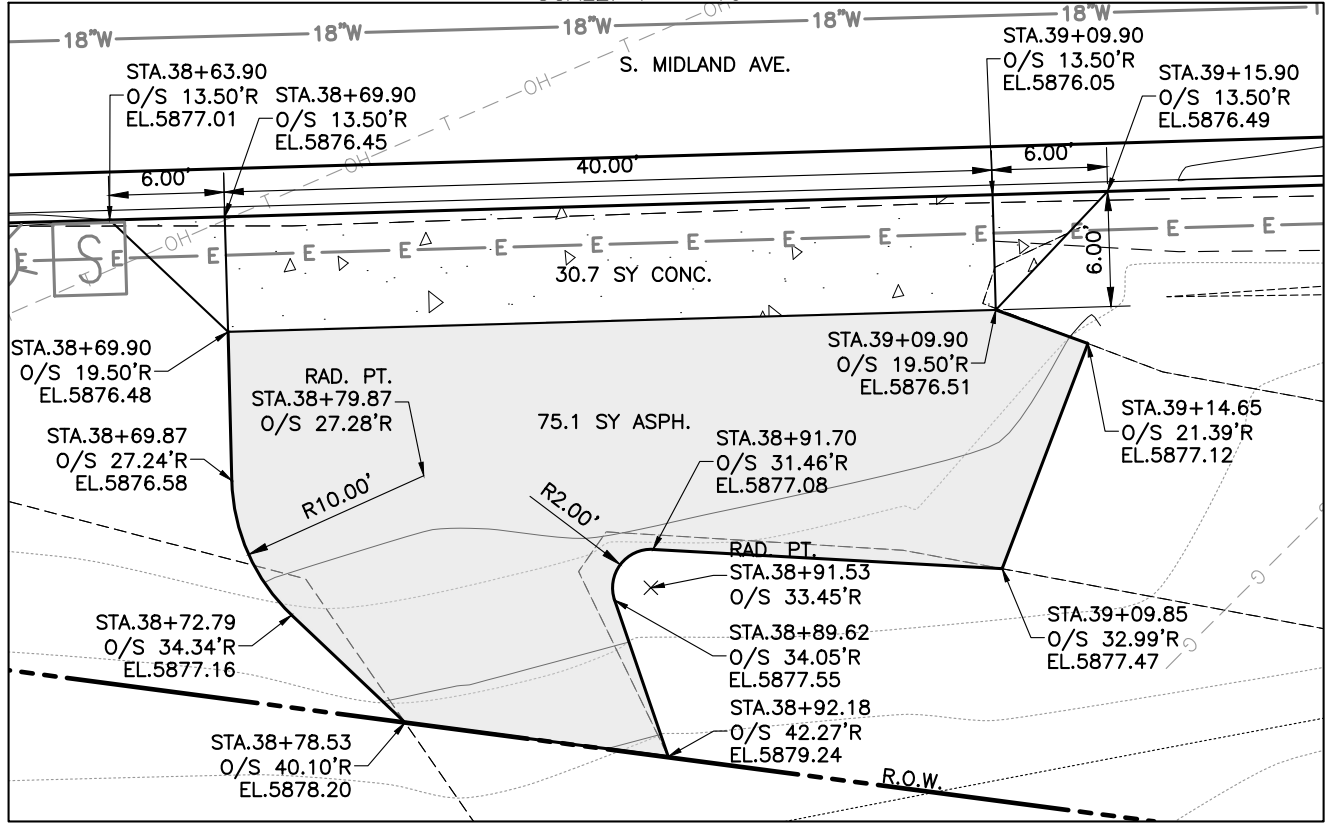


CROUSE/MILLER DRIVEWAY
SCALE: 1" = 10'

Computer File Information		Sheet Revisions			
Print Date:	7/14/20	Rev.	Date	Comments	Init.
Last Modification Date:	4/23/2019	1			
Drawing File Name:	SMidland-DrivewayDetails				
Autocad Ver.	2018				
Scale:	As Shown				
Units:	English				
SGM Project No.:	2017-211.001				
Quality Control:	RGN				




As Constructed		South Midland Ave. Improvements				Project No./Code	
No Revisions:		Driveway Details (1)				No.:	BUILD M535-006
Revised:		Engineer:	MDF	Structure	---	Code:	22933
Void:		Drawn By:	AMC	Numbers	---	Sheet Number:	85
		Sheet Subset:	RDWY	Subset Sheets:	41 of 45		


I:\2017\2017-211-GWSSMIDLAND\001-MIDLAND4MILE\RD27\THST\H-DWGS\CIVIL\PS-SHEETSET\SMIDLAND-DRIVEWAYDETAILS.DWG Plotted: 7/14/2020 3:43 PM By: Ashley Cline

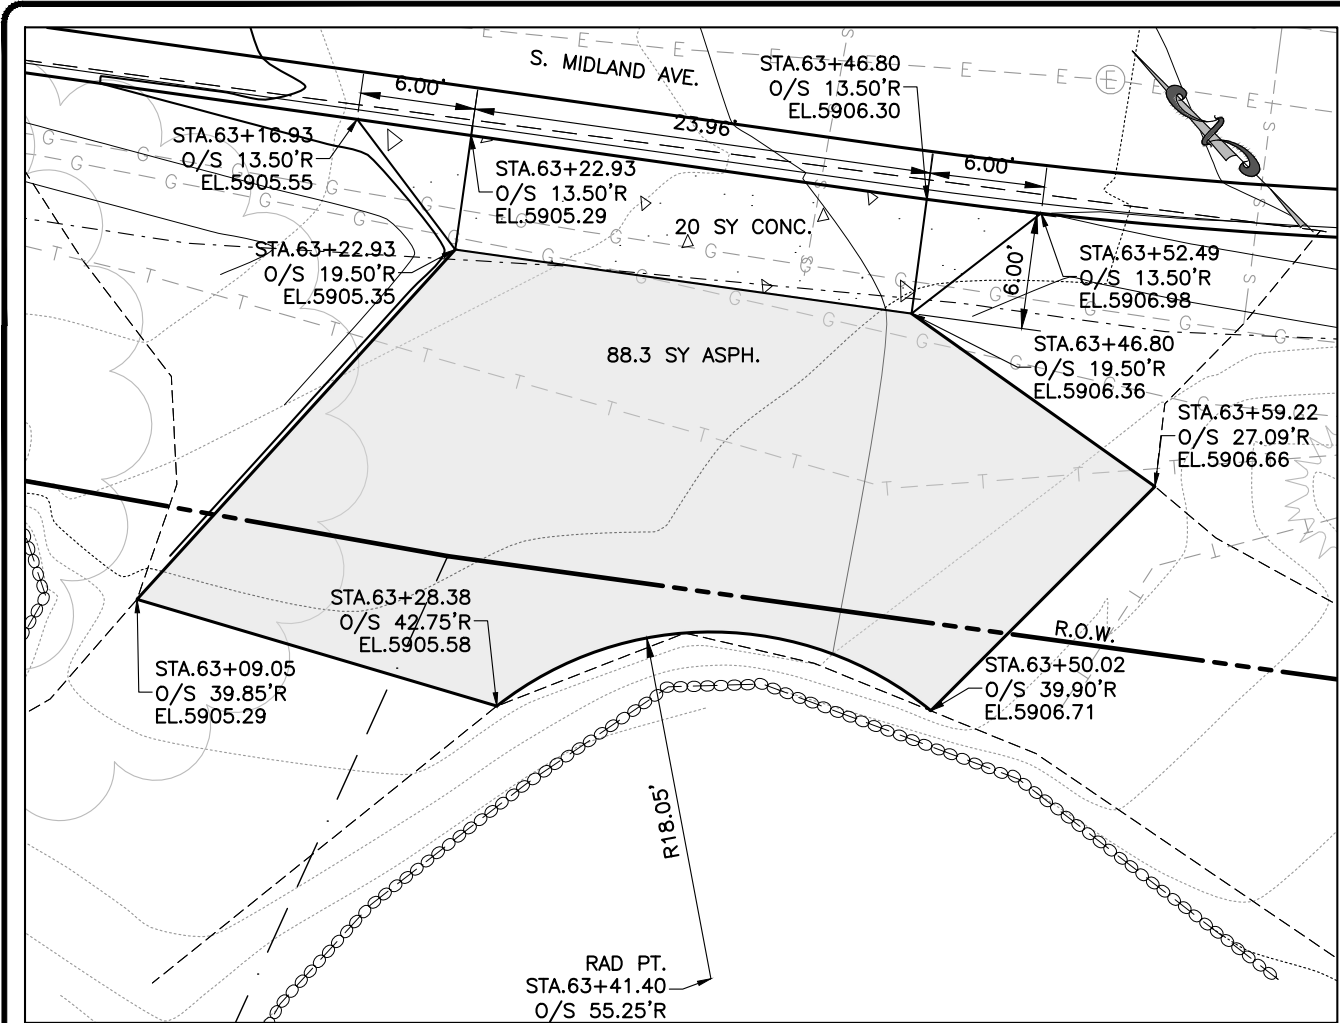

PORTILLA/RIVIERA DRIVEWAY
SCALE: 1" = 10'

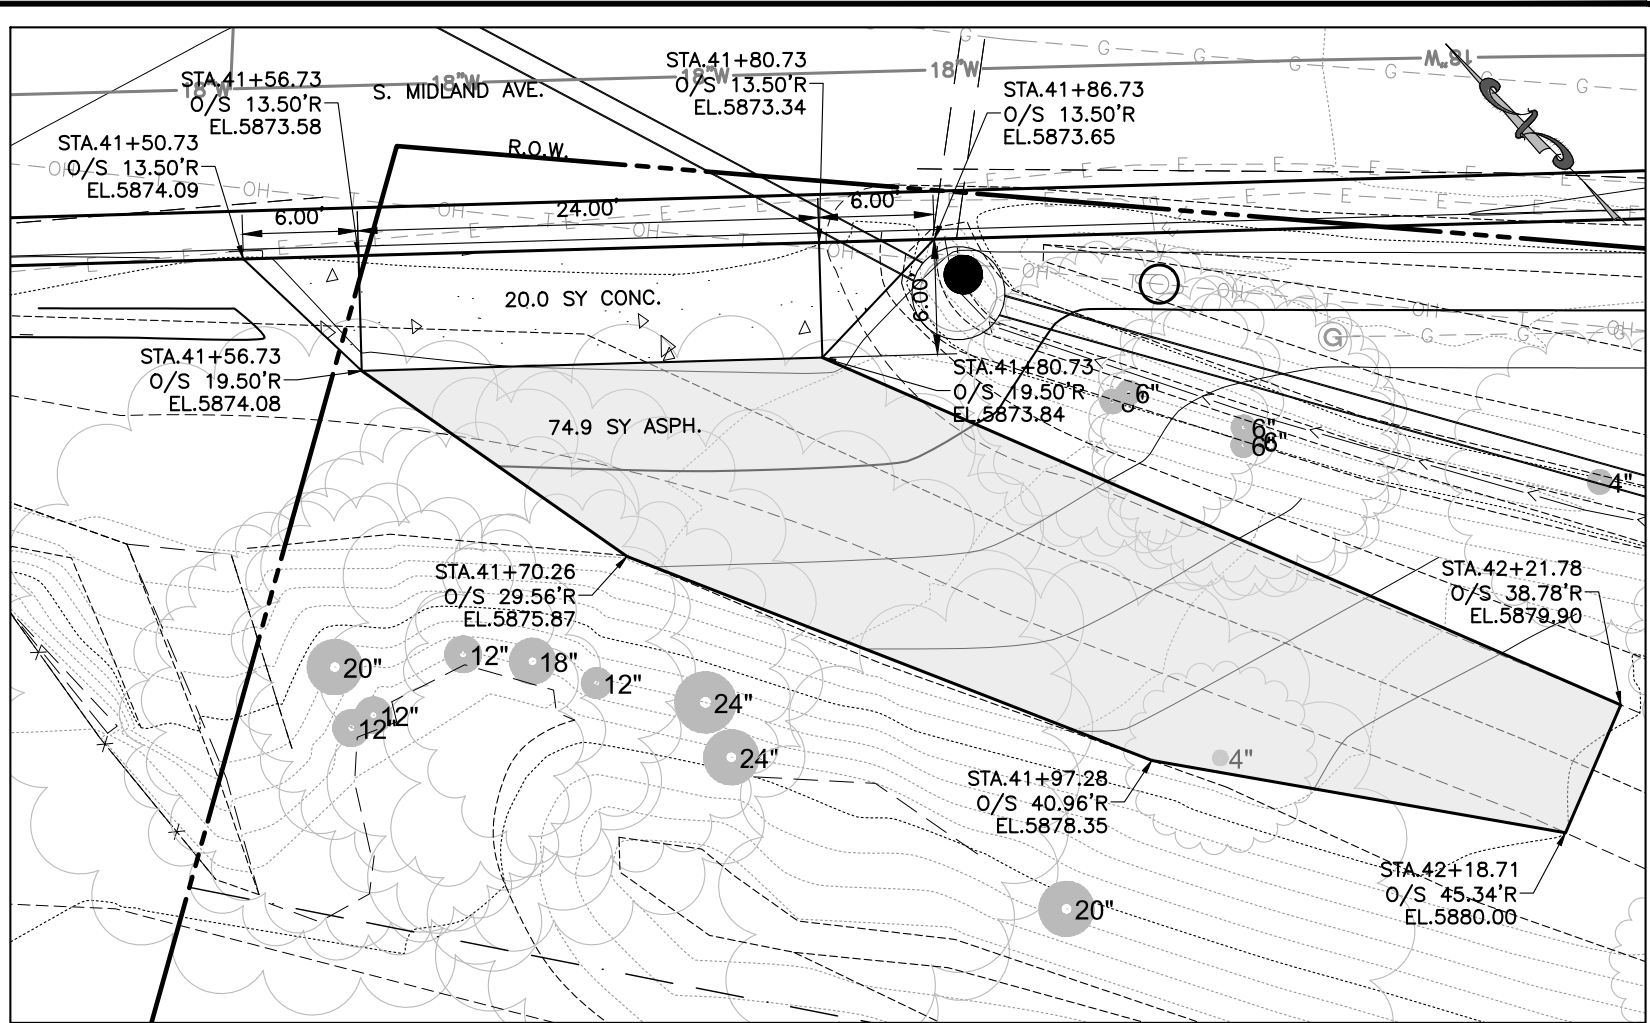

DOUBLE R PROPERTIES DRIVEWAY
SCALE: 1" = 10'

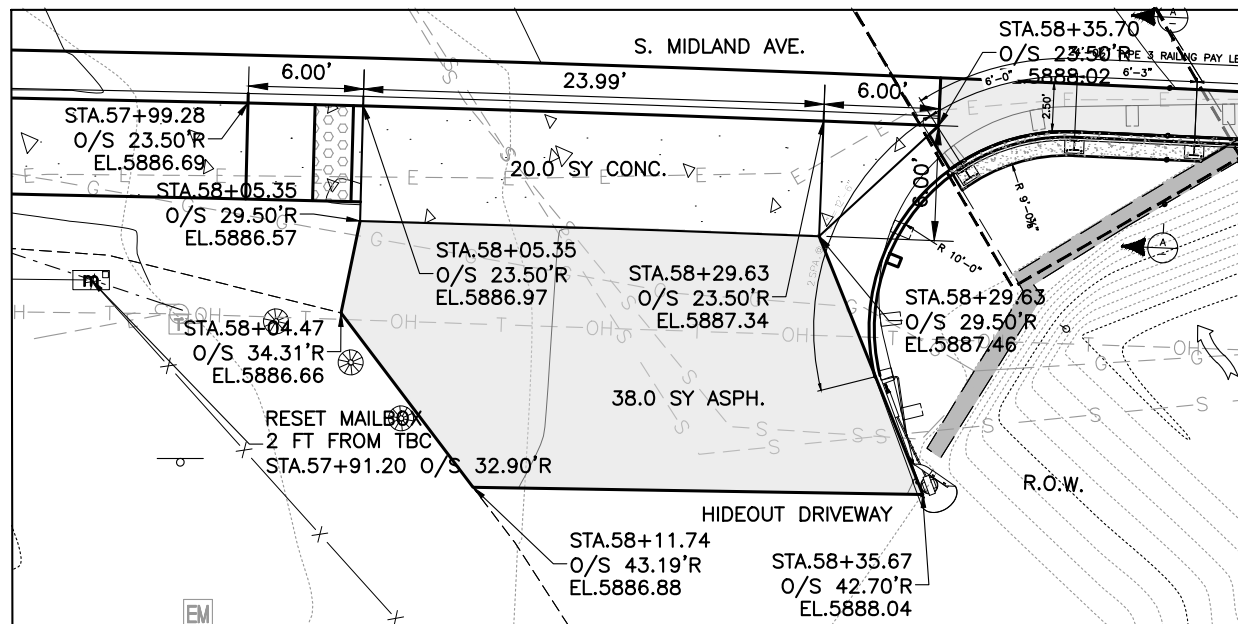

HIDEOUT DRIVEWAY
SCALE: 1" = 10'

Computer File Information			
Print Date:	7/14/20		
Last Modification Date:	4/23/2019		
Drawing File Name:	SMidland-DrivewayDetails		
Autocad Ver.	2018	Scale: As Shown	Units: English
SGM Project No.:	2017-211.001	Quality Control:	RGH

Sheet Revisions			
Rev.	Date	Comments	Init.
1			




As Constructed	
No Revisions:	-
Revised:	-
Void:	-


South Midland Ave. Improvements Driveway Details (2)			
Engineer:	MDF	Structure	---
Drawn By:	AMC	Numbers	---
Sheet Subset:	RDWY	Subset Sheets:	42 of 45

Project No./Code	
No.:	BUILD M535-006
Code:	22933
Sheet Number:	86


I:\2017\2017-211-GWSSMIDLAND\001-MIDLAND4MILERD27THST-H-DWGS\CIVIL\PS-SHEETSET\MIDLAND-DRIVEWAYDETAILS.DWG Plotted: 7/14/2020 3:43 PM By: Ashley Cline

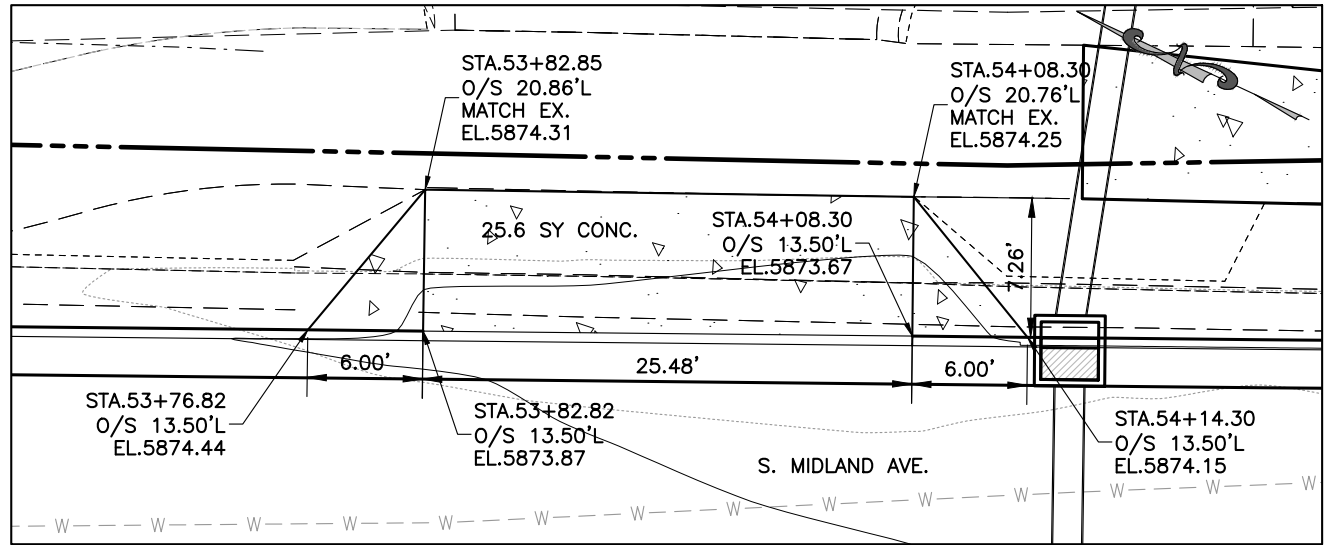

3-MILE CREEK TRAILHEAD ACCESS DRIVEWAY
SCALE: 1" = 10'

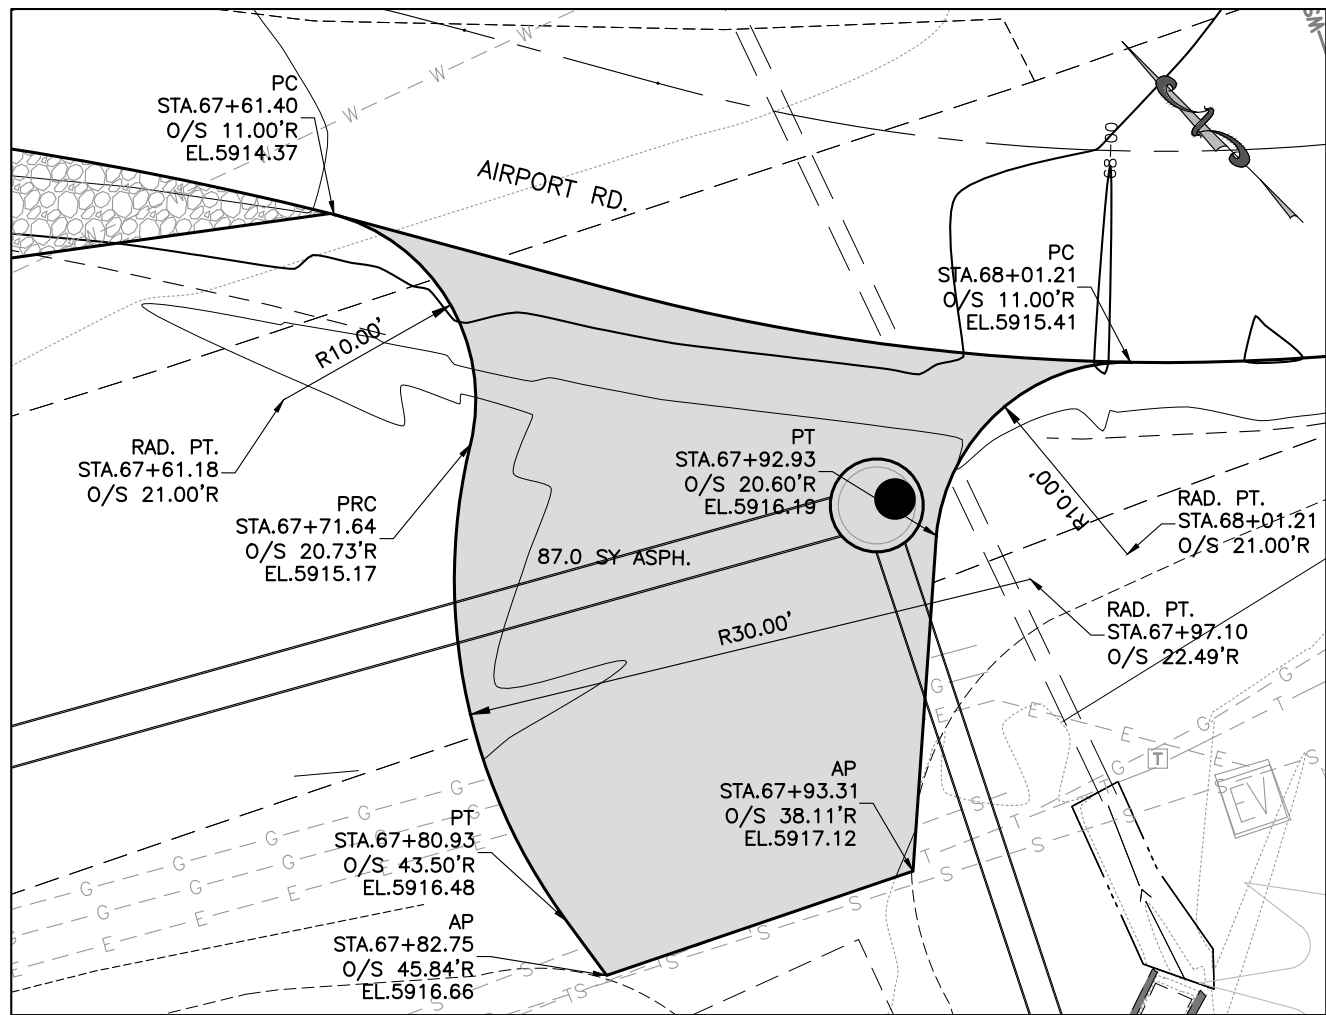


AIRPORT ROAD DRIVEWAY
SCALE: 1" = 10'

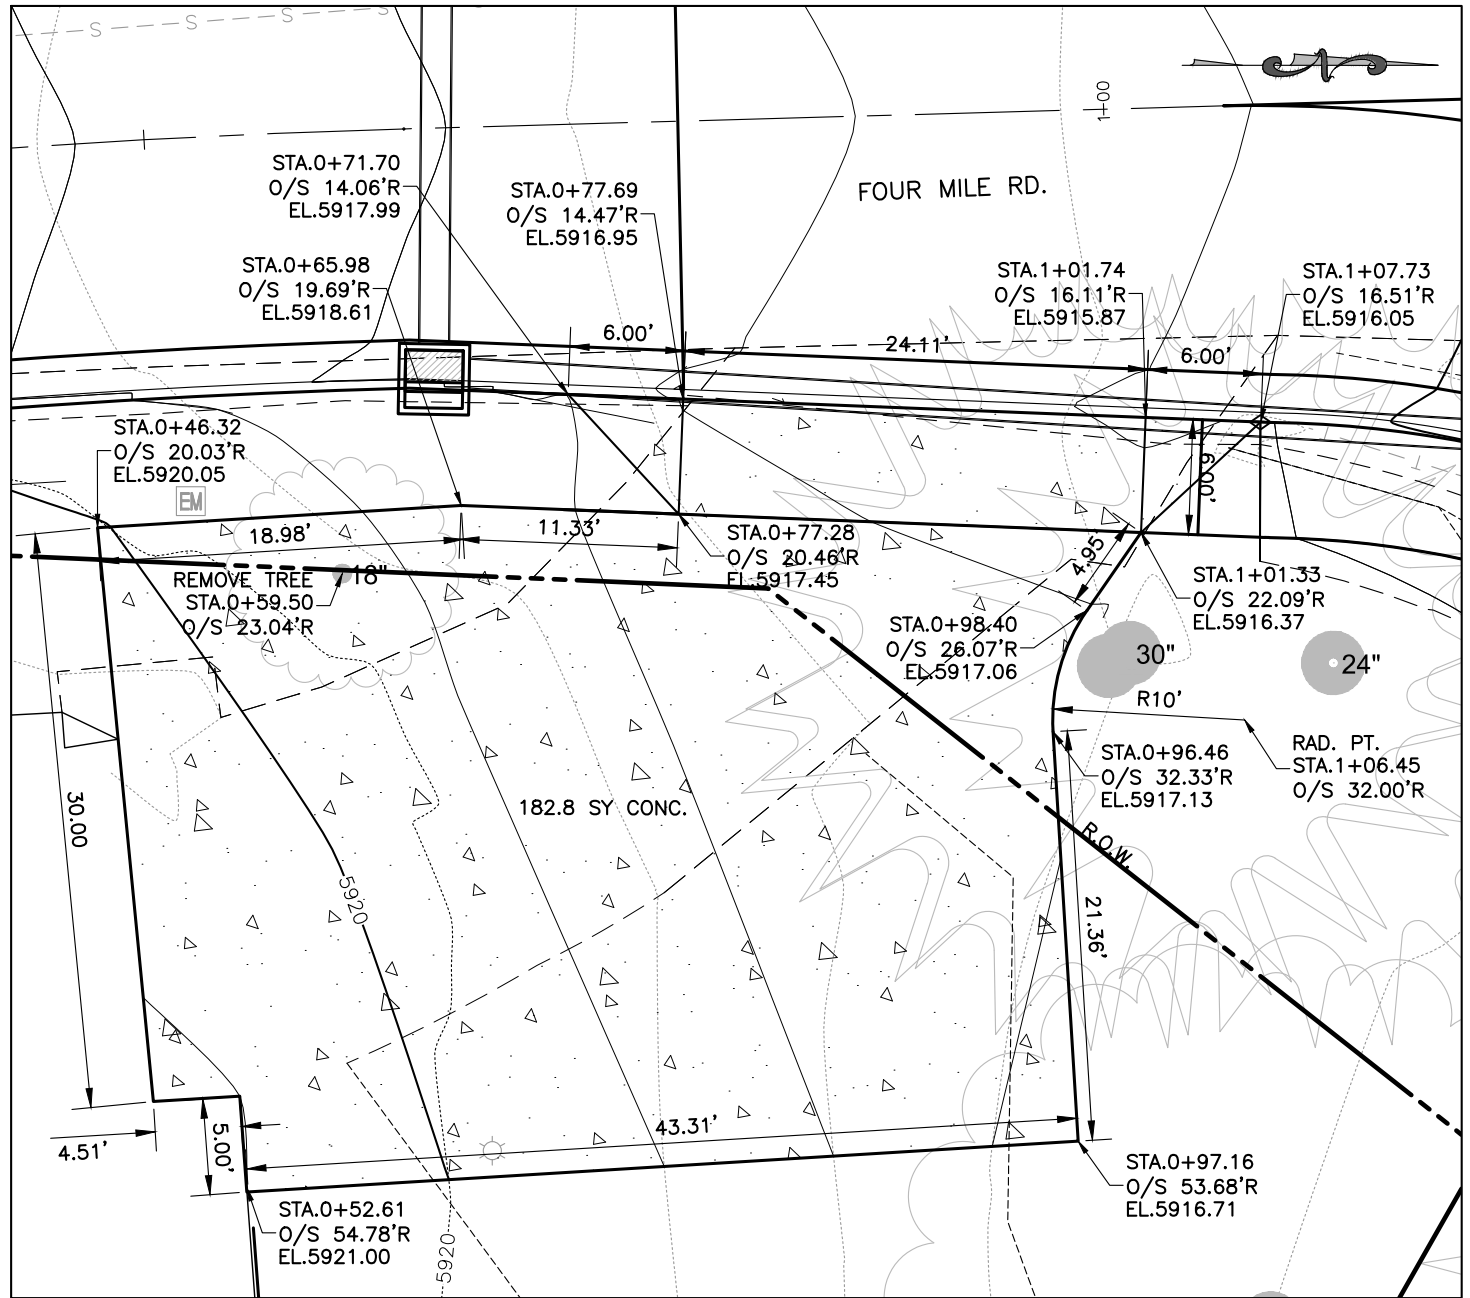

4-MILE ROAD DRIVEWAY
SCALE: 1" = 10'

Computer File Information		Sheet Revisions					 118 West Sixth Street, Suite 200 Glenwood Springs, CO 81601 970.945.1004 www.sgm-inc.com	As Constructed		South Midland Ave. Improvements Driveway Details (3)				Project No./Code	
Print Date: 7/14/20		Rev.	Date	Comments	Init.			No Revisions:	-					No.: BUILD M535-006	
Last Modification Date: 4/23/2019		1													
Drawing File Name: SMidland-DrivewayDetails															
Autocad Ver. 2018 Scale: As Shown Units: English															
SGM Project No.: 2017-211.001 Quality Control: RGN								Revised:	-	Engineer:	MDF	Structure	---	Code: 22933	
										Drawn By:	AMC	Numbers	---		
								Void:	-	Sheet Subset:	RDWY	Subset Sheets:	43 of 45	Sheet Number: 87	

I:\2017\2017-211-GWSSOMIDLAND\001-MIDLAND4MILERO27TH\H-DWGS\CIVIL\PS-SHEETSET\SMIDLAND-DRIVEWAYDETAILS.DWG Plotted: 7/14/2020 3:44 PM By: Ashley Cline

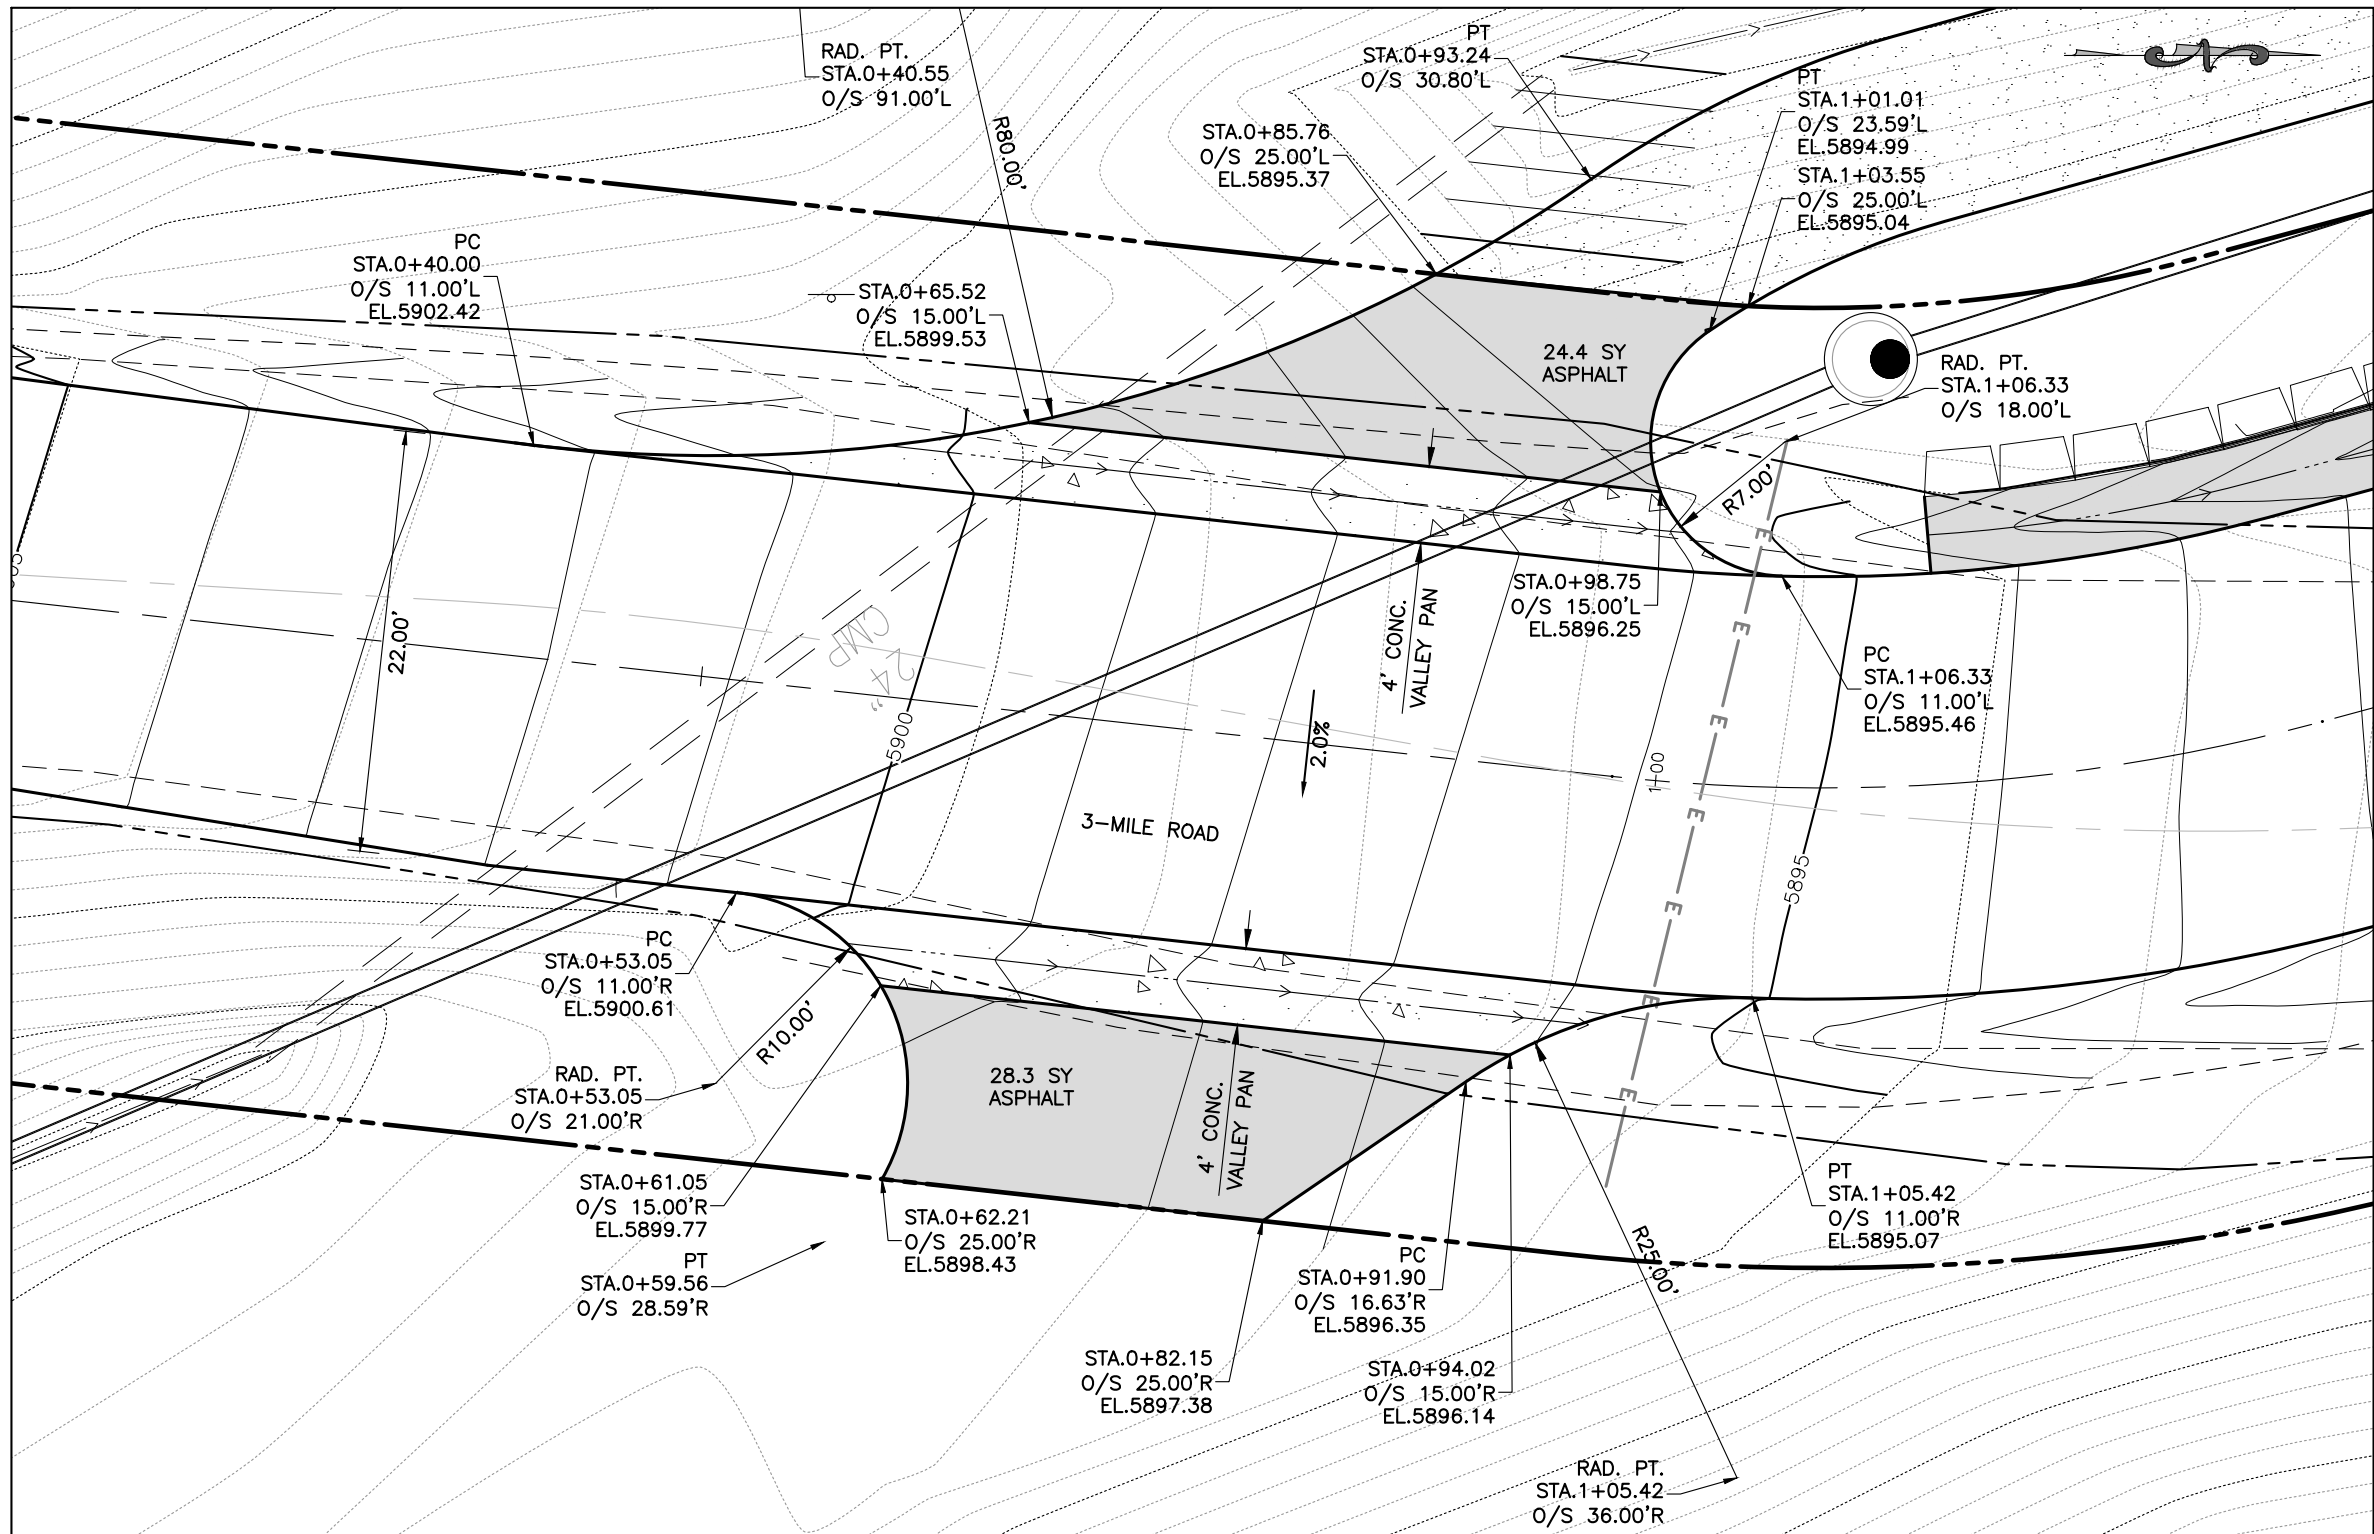

GLENWOOD LAND COMPANY ACCESS DRIVEWAYS
SCALE: 1" = 10'

Computer File Information		Sheet Revisions				As Constructed		South Midland Ave. Improvements Driveway Details (4)			Project No./Code	
Print Date: 7/14/20	Last Modification Date: 4/23/2019	Rev.	Date	Comments	Init.						No.: BUILD M535-006	
Drawing File Name: SMidland-DrivewayDetails		1				No Revisions:	-	Engineer: MDF	Structure	---	Code: 22933	
Autocad Ver. 2018	Scale: As Shown					Revised:	-	Drawn By: AMC	Numbers	---		
SGM Project No.: 2017-211.001	Quality Control: RGN					Void:	-	Sheet Subset: RDWY	Subset Sheets:	44 of 45	Sheet Number: 88	





GLENWOOD
SPRINGS
COLORADO



118 West Sixth Street, Suite 200
Glenwood Springs, CO 81601
970.945.1004 www.sgm-inc.com

NOTE:

- 1. DRIVEWAY CUTS SHALL BE IN COMPLIANCE WITH CITY OF GLENWOOD ENGINEERING STANDARDS. REFER TO DETAIL T7 OF THE CITY OF GLENWOOD SPRINGS TRANSPORTATION STANDARD DETAILS.
- 2. SEE SHEET 84 FOR LAVEN PROPERTY DETAIL.
- 3. DRIVEWAY CUTS WILL BE PAID FOR UNDER ITEM 608-00000 CONCRETE SIDEWALK.

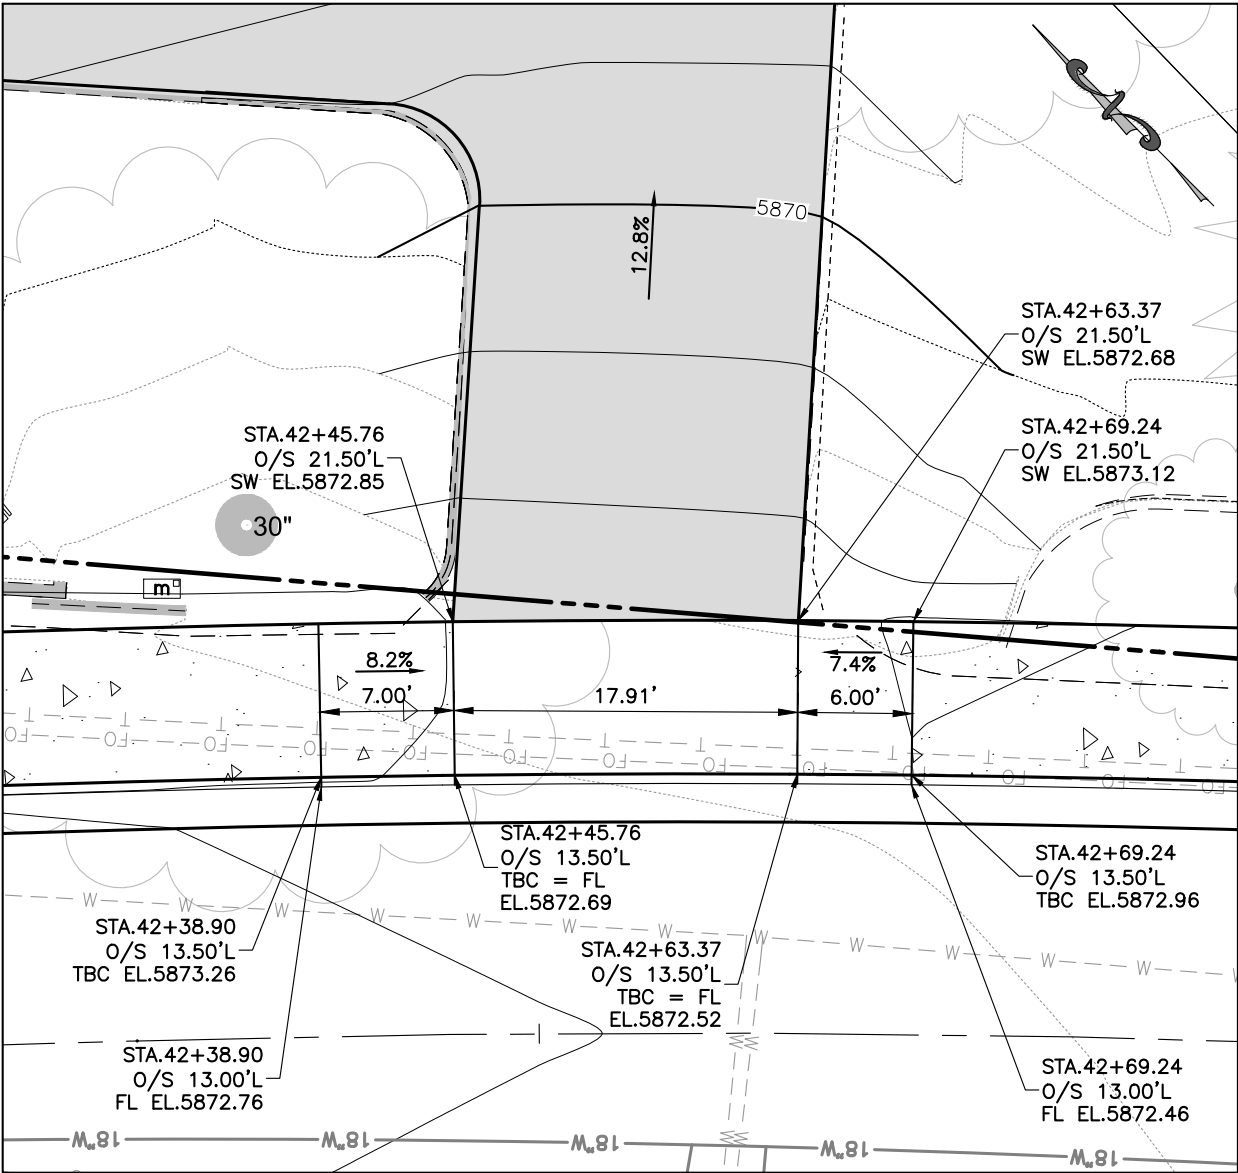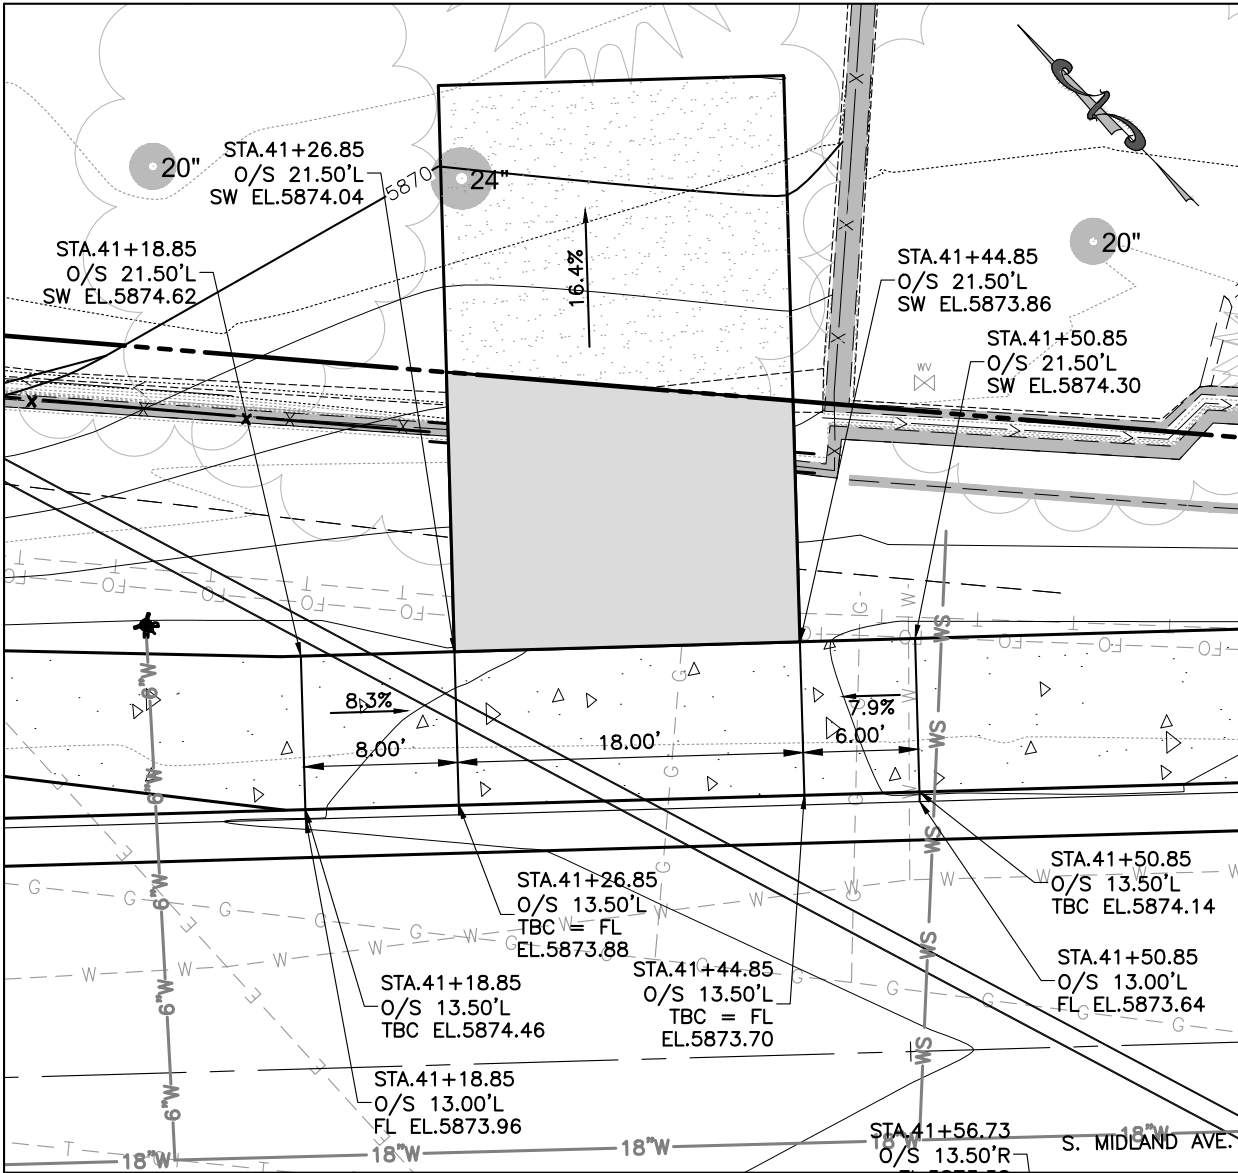


LAVEN PROPERTY ACCESS DRIVEWAYS
SCALE: 1" = 10'

I:\2017\2017-211-GWSSOMIDLAND\001-MIDLAND4MILERD27THST\H-DWGS\CIVIL\PS-SHEETSET\SMIDLAND-DRIVEWAYDETAILS.DWG Plotted: 7/14/2020 3:45 PM By: Ashley Cline

Computer File Information		Sheet Revisions				As Constructed		South Midland Ave. Improvements Driveway Details (5)			Project No./Code	
Print Date: 7/14/20	Last Modification Date: 4/23/2019	Rev.	Date	Comments	Init.						No.: BUILD M535-006	
Drawing File Name: SMidland-DrivewayDetails		1				No Revisions:	-	Engineer: MDF	Structure	---	Code: 22933	
Autocad Ver. 2018	Scale: As Shown					Revised:	-	Drawn By: AMC	Numbers	---		
SGM Project No.: 2017-211.001	Quality Control: RGN					Void:	-	Sheet Subset: ROADWAY	Subset Sheets:	45 of 45	Sheet Number: 89	





I:\2017\2017-211-GWSSOMIDLAND\001-MIDLAND4MILERD27THST\H-DWGS\CIVIL\PS-SHEETSET\SMIDLAND-DRIVEWAYDETAILS.DWG Plotted: 7/14/2020 3:45 PM By: Ashley Cline

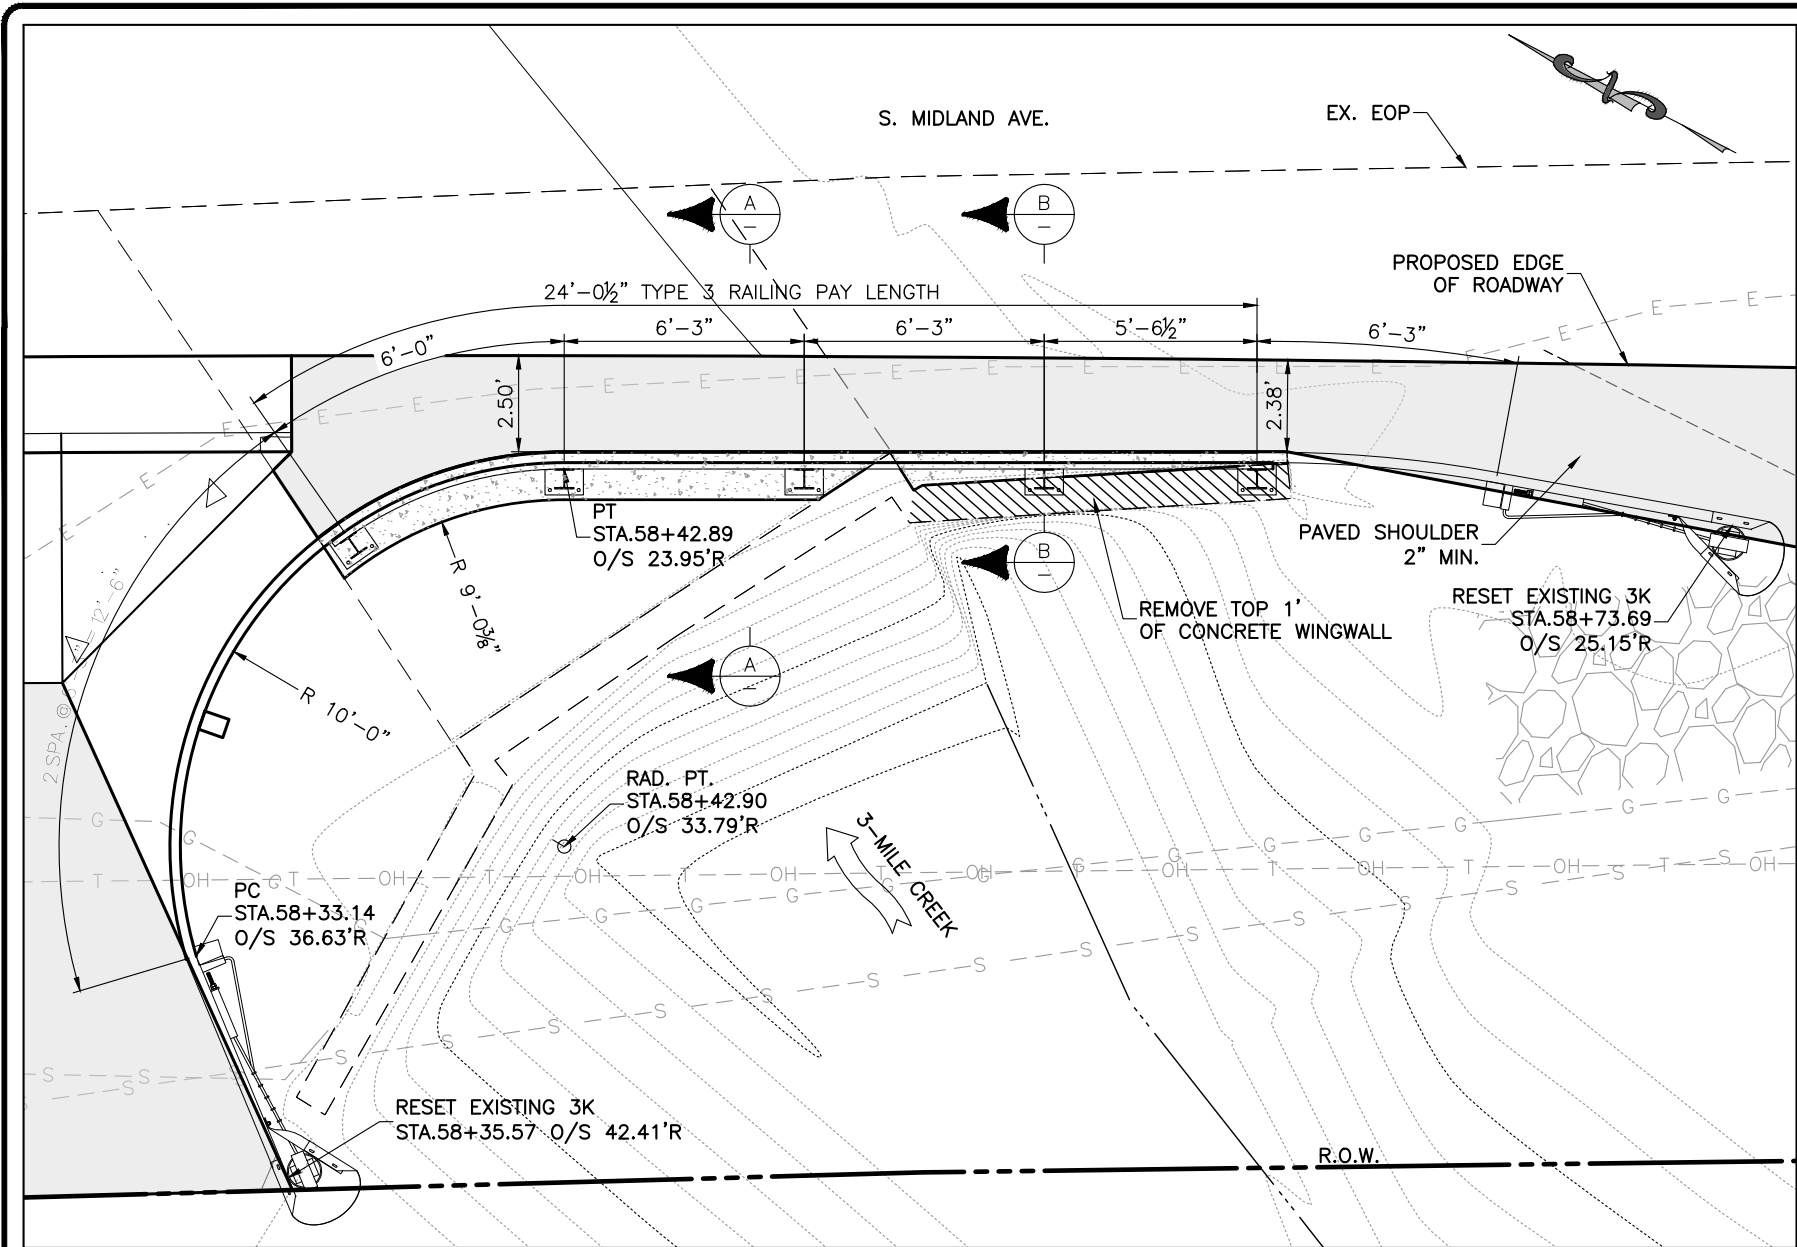

3-MILE CREEK BOX CULVERT GUARDRAIL DETAIL
SCALE: 1" = 5'

TYPE 3 BRIDGE RAILING NOTES:

1. SEE RETAINING WALL DETAILS FOR ADDITIONAL INFO FOR THE TYPE 3 BRIDGE RAIL.
2. ALL BRIDGE RAIL TYPE 3 RAIL BACKING TUBES SHALL BE FABRICATED FROM ASTM A500 GRADE B. ALL POSTS, BASE PLATES, AND ANCHOR BOLTS SHALL BE FABRICATED FROM ASTM A36 STEEL. THE ABOVE MATERIAL SHALL BE GALVANIZED AFTER FABRICATION IN ACCORDANCE WITH SECTION 509 AND STAINED IN ACCORDANCE WITH THE PROJECT SPECIAL PROVISION. HARDWARE SHALL BE GALVANIZED AND NEED NOT BE STAINED.
3. CONTRACTOR SHALL VERIFY POST HEIGHTS PRIOR TO FABRICATION. ALTERNATIVELY, THE POSTS CAN BE FIELD CUT AND FIELD WELDED TO OBTAIN THE CORRECT HEIGHT ABOVE ROADWAY.
4. CURB CONCRETE SHALL BE CDOT CLASS D.
5. REINFORCING STEEL SHALL BE EPOXY COATED.
6. CURB CONCRETE AND REINFORCING STEEL SHALL BE INCIDENTAL TO TYPE 3 RAIL AND WILL NOT BE PAID FOR SEPARATELY.
7. PRIOR TO FABRICATION OF BRIDGE RAIL, WORKING DRAWINGS WHICH COMPLY WITH THE REQUIREMENTS OF SECTION 105 SHALL BE SUBMITTED TO THE ENGINEER FOR INFORMATION ONLY.
8. BACKING TUBES SHALL BE CONTINUOUS WITHOUT SPLICES. 4. THE ENDS OF THE BACKING TUBES SHALL EXTEND 5" BEYOND END POSTS.
9. W-BEAM GUARDRAIL GUARDRAIL WILL NOT BE PAID FOR SEPARATELY BUT SHALL BE INCLUDED IN THE WORK.

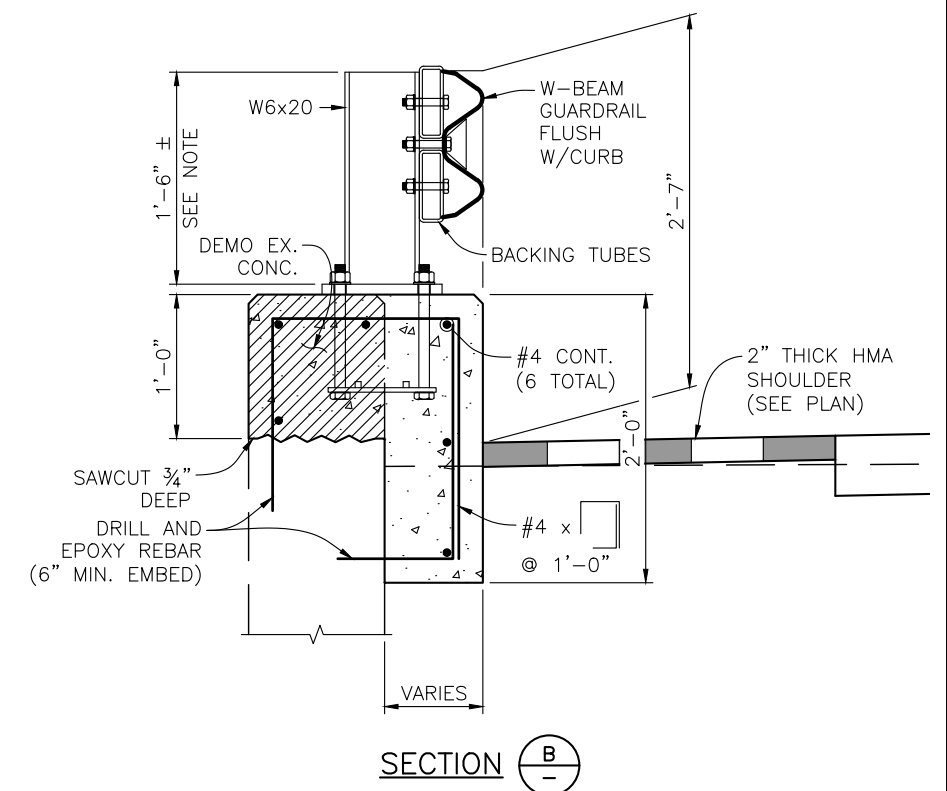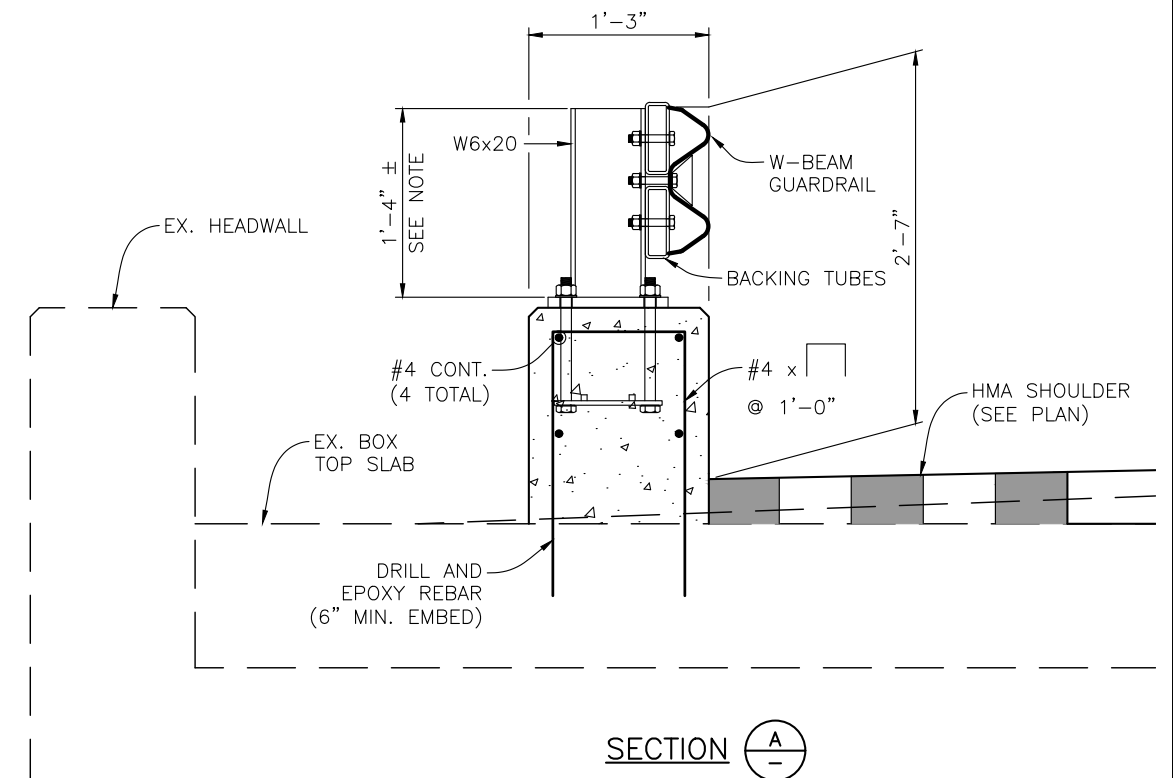

Computer File Information		Sheet Revisions			GLENWOOD SPRINGS COLORADO	SGM	As Constructed		South Midland Ave. Improvements 3-Mile Creek Guardrail Detail			Project No./Code	
Print Date: 7/14/20		Rev.	Date	Comments			No Revisions:	-				No.:	BUILD M535-006
Last Modification Date: 4/23/2019		1					Revised:	-	Engineer:	MDF	Structure	Code:	22933
Drawing File Name: SMidland-DrivewayDetails							Void:	-	Drawn By:	AMC	Numbers	Sheet Number:	90
Autocad Ver. 2018 Scale: As Shown Units: English									Sheet Subset:	GUARDRAIL	Subset Sheets:	1 of 1	
SGM Project No.: 2017-211.001 Quality Control: RGN													

South Midland Improvements Project

City of Glenwood Springs
Ryan Johnson

Project Start Date:	11/10/2020
---------------------	------------

Scrolling Increment:	0
----------------------	---

11/10/2020

0

Legend:

On Track

Low Risk

Med Risk

High Risk

Unassigned

November

December

Milestone Description	Category	Assigned To	Progress	Start	No. Days
South Midland anticipated pre-construction schedule					
Council Approval	Goal		0%	11/10/2020	1
CDOT Concurrence and NTP	On Track		0%	11/11/2020	7
Issue NTP to Contractor	Goal		0%	11/18/2020	1
Contractor Submits Preliminary or baseline Schedule	On Track		0%	11/18/2020	14
Preconstruction Meeting	Goal		0%	11/19/2020	2
Actual Construction Start	On Track		0%	11/29/2020	16
Initial Public Information Meeting	Milestone		0%	11/12/2020	1

[illegible]